


Akira Back

Level 2, Northern end of the Overseas Passenger Terminal, Circular Quay W, The Rocks NSW 2000

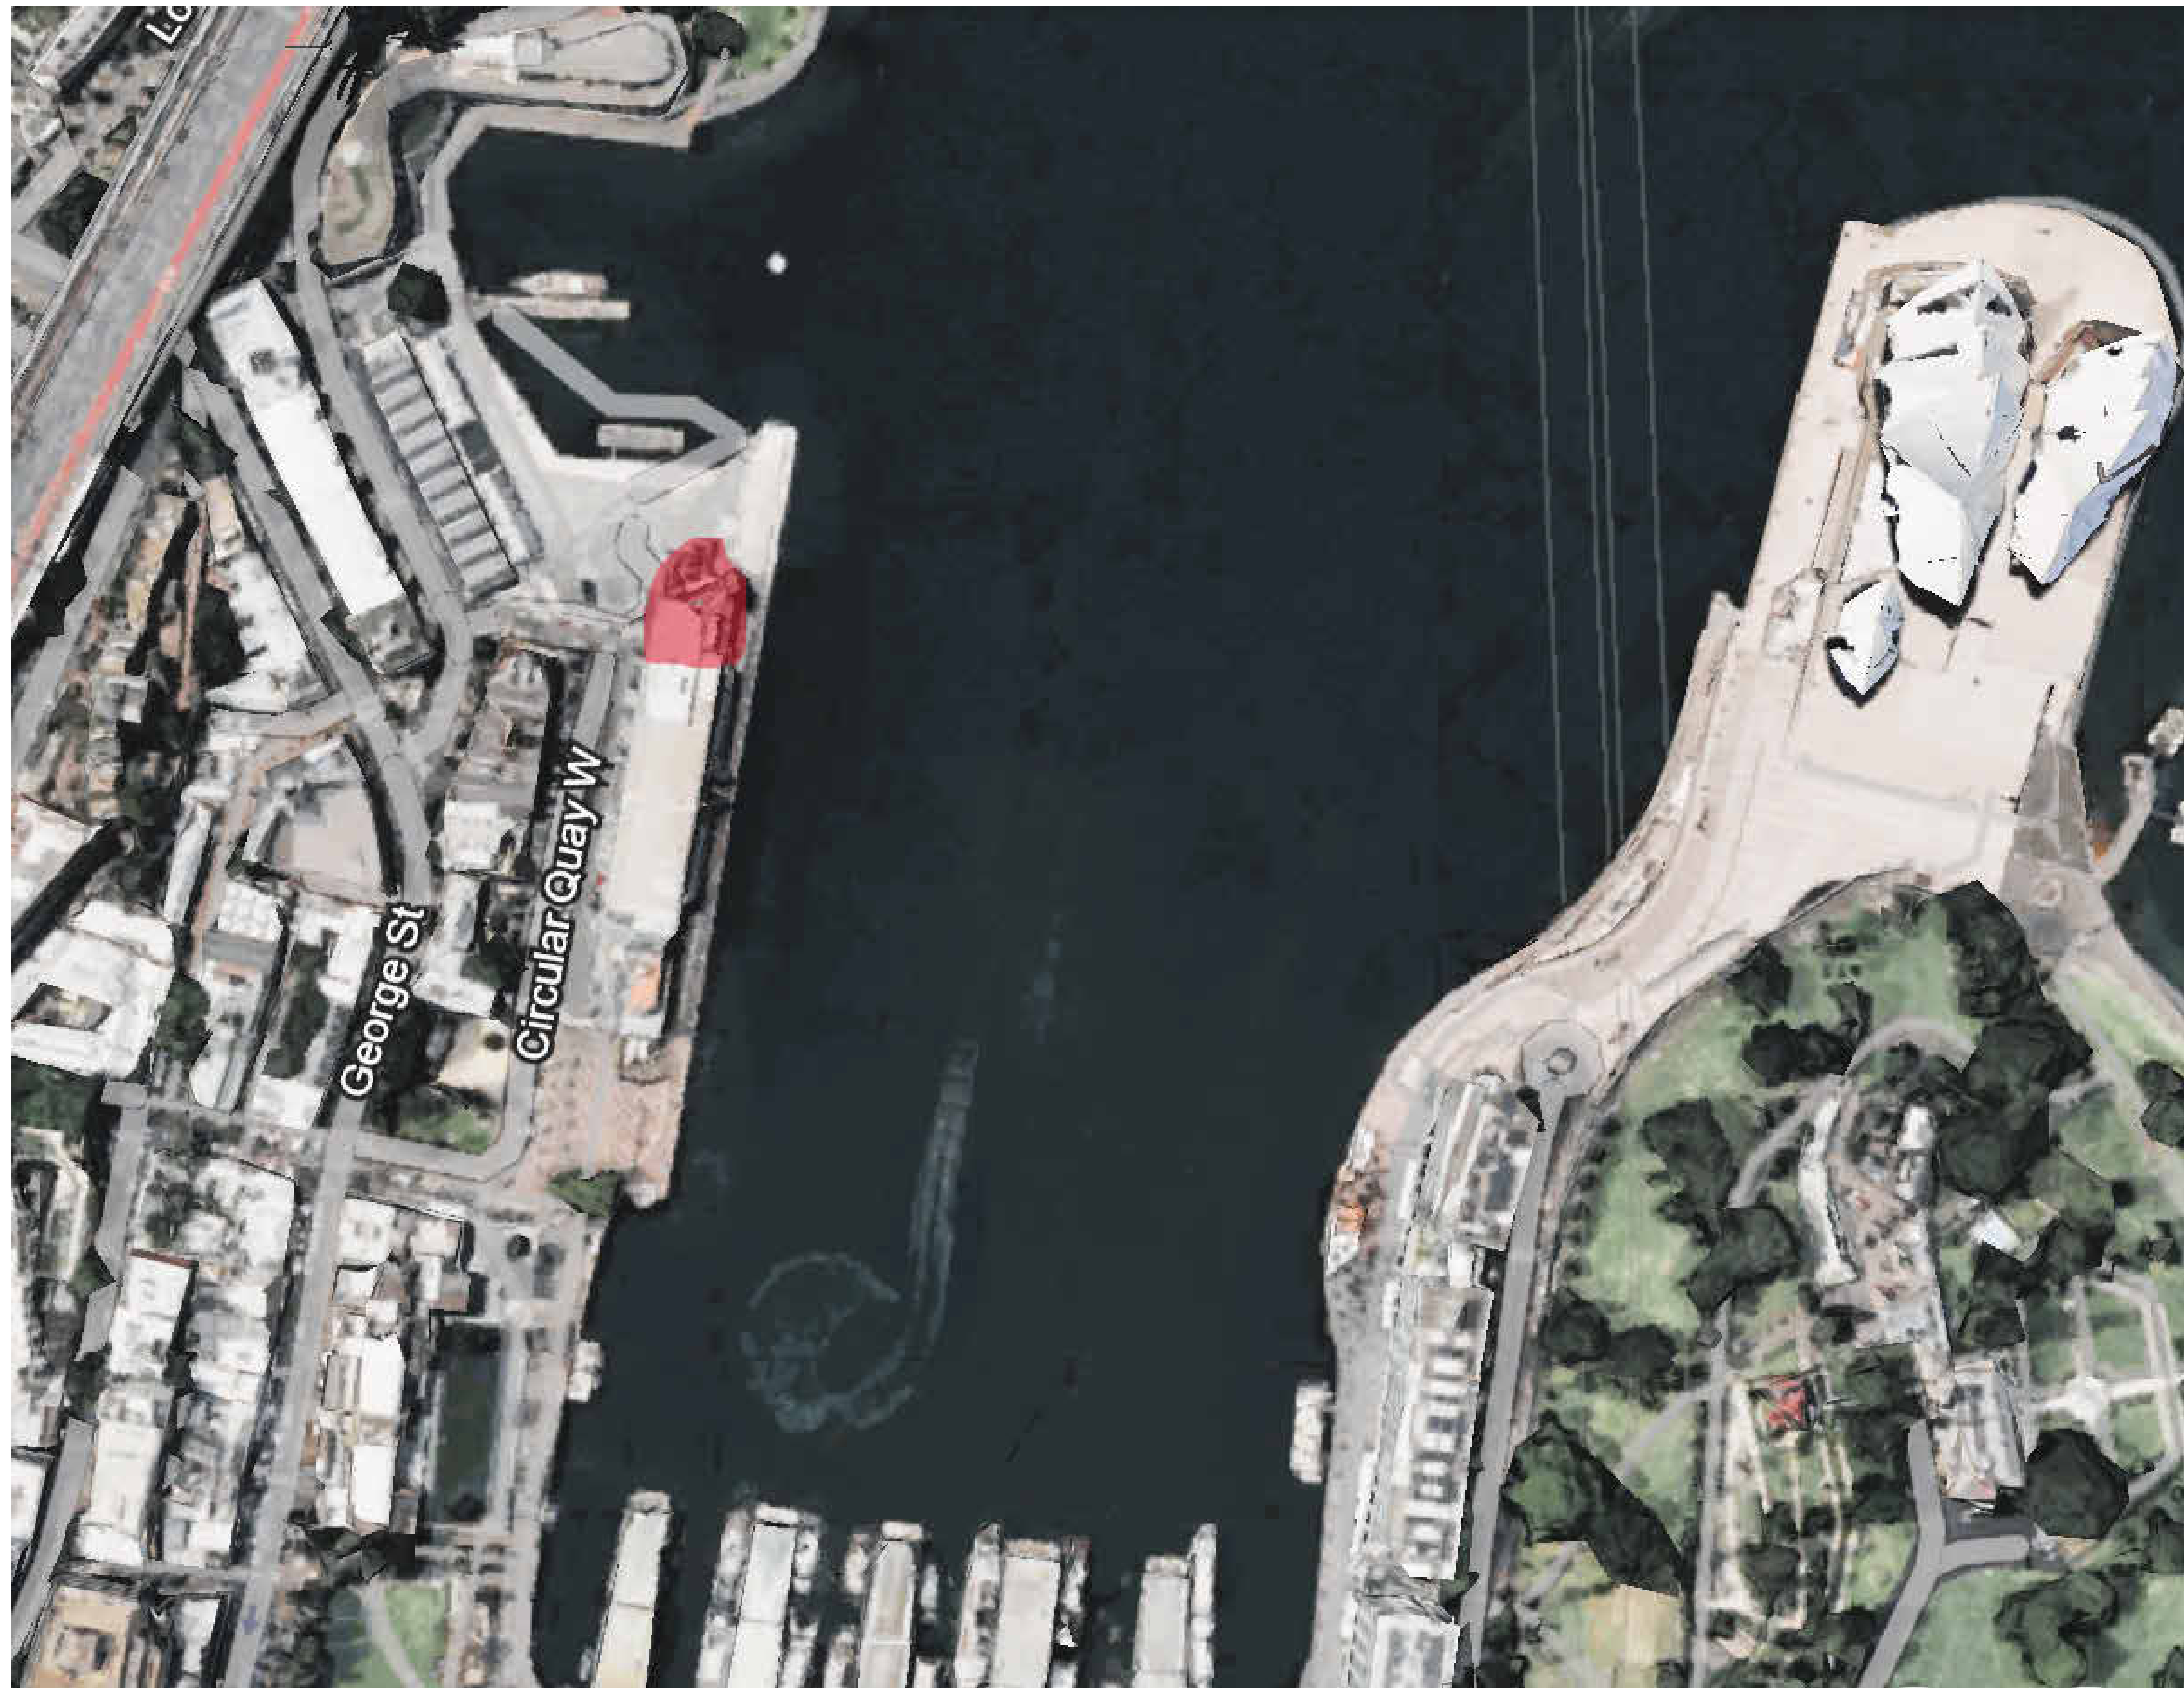

Location Map

Sheet Number	Sheet Name	Scale
A00	Cover Page	N/A
A01	Site Plan	1:100
A02	Zoning Plan	1:100
A03	Demolition Plan Level 2A	1:50
A04	Demolition Plan Level 2B	1:50
A05	Floor Plan Level 2A	1:50
A06	Floor Plan Level 2B	1:50
A07	Furniture Plan Level 2A	1:50
A08	Furniture Plan Level 2B	1:50
A09	RCP Level 2A	1:50
A10	RCP Level 2B	1:50
A11	Electrical Plan Level 2A	1:50
A12	Electrical Plan Level 2B	1:50
A13	Section 1-3	1:50
A14	External Elevations	1:50
A15	Entry Isometric View	N/A
A16	Cocktail Bar Plan/RCP & Isometrics	1:20
A17	Cocktail Bar Elevation 1-4	1:20
A18	Cocktail Bar Detail Section 1-2 & Detail Drawings	1:20 & 1:5
A19	Water Feature Wall Plan & RCP	1:20
A20	Water Feature Wall Elevations	1:20
A21	Water Feature Wall Section & Isometric	1:10 & 1:5
A22	Building Isometric View	N/A

Room Schedule Number	Name	Area
01	Main Dining Area	365 m ²
02	Terrace	160 m ²
03	Rounded Private Dining	125 m ²
04	Kitchen	123 m ²
05	Dining Terrace	110 m ²
06	Entry/Reception	103 m ²
07	Trangular Private Dining	98 m ²
08	Cocktail Terrace	93 m ²
09	Female WC	43 m ²
10	Bar	43 m ²
11	Hallways	40 m ²
12	Male WC	31 m ²
13	Cocktail Bar	29 m ²
14	Sushi Bar	18 m ²
15	Storage	14 m ²
16	Cool Room	9 m ²
17	Accessible WC	7 m ²
18	Beverage Storage	6 m ²
19	Staff Room	6 m ²
20	Garbage Room	4 m ²
21	Staff WC	4 m ²

Total Floor Area: 1338 m²

LEGEND

Hatch Types

Existing

Concrete

Tile

Plaster Board

MDF

Earth

Timber

Metal

Wall Types

STW1

STW2

STW3

13mm Plaster Board, 90mm Timber Stud Frame, 13mm Plaster Board

13mm Plaster Board, 90mm Timber Stud Frame, 13mm FC, 2mm Glue, 10mm Tie

10mm Tile, 2mm Glue, 13mm FC, 90mm Timber Stud Frame, 13mm FC, 2mm Glue, 10mm Tie

Door Types

D01

D02

D03

D04

D05

D06

Flush Interior Door 910 x 2110mm

Flush Interior Door 810 x 2110mm

Flush Interior Door 1010 x 2110mm

Double Flush Exterior Door 1510 x 2110mm

Double Flush Interior Door 1510 x 2110mm

Curtain Glass Wall Flush Doors (Refer to FF&E for specification)

Abbreviations

FFL

FCL

COS

MA

FU

EQ

AP

LI

SA

Finished Floor Level

Finished Ceiling Level

Confirm On Site

Material

Furniture

Specialty Equipment

Appliances

Lighting Fixtures

Plumbing Fixtures

Keynote Legend

Key Value

Keynote Text

AP02

AP10

AP11

AP12

EQ07

EQ12

EQ17

EQ18

EQ19

EQ21

EQ22

EQ23

 EQ1117

[illegible]

 
A0 05/12/2023 14:31:48


[illegible]


By Room Name Legend



- Accessible WC
- Bar
- Beverage Storage
- Cocktail Bar
- Cocktail Terrace
- Cool Room
- Dining Terrace
- Entry/Reception
- Female WC
- Garbage Room
- Hallways
- Kitchen
- Main Dining Area
- Male WC
- Rounded Private Dining
- Staff Room
- Staff WC
- Storage
- Sushi Bar
- Terrace
- Triangular Private Dining

AC



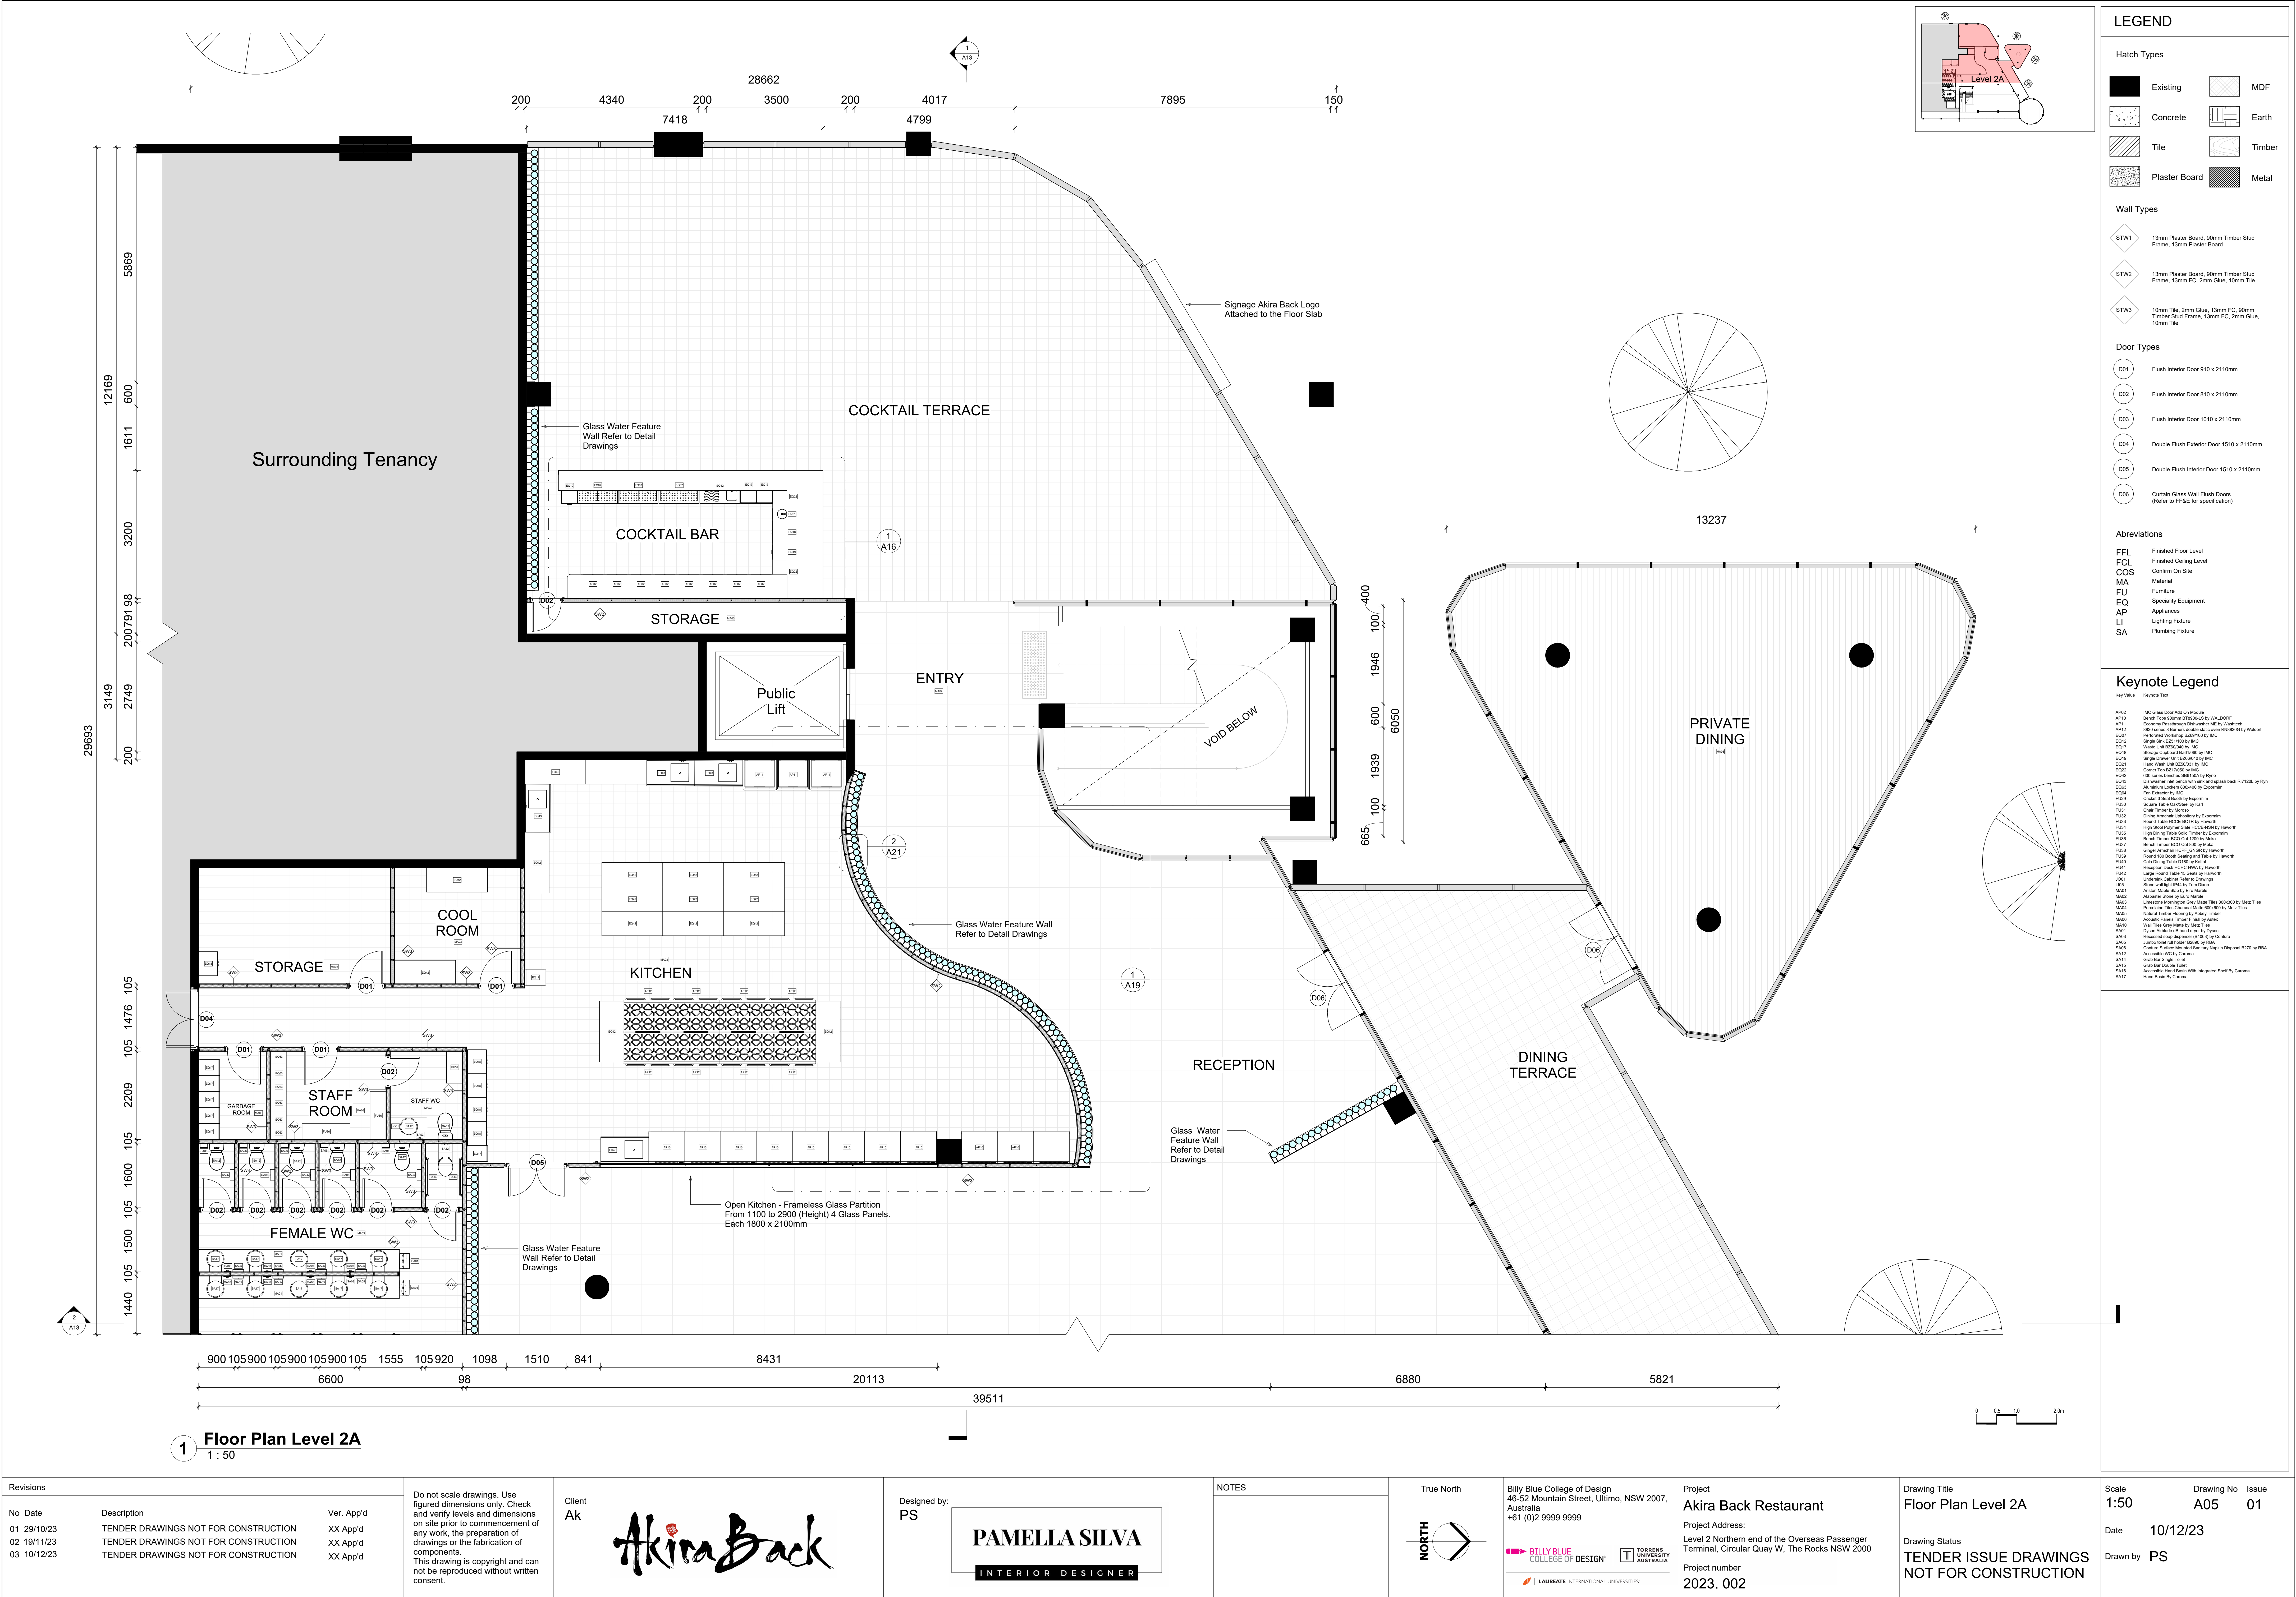

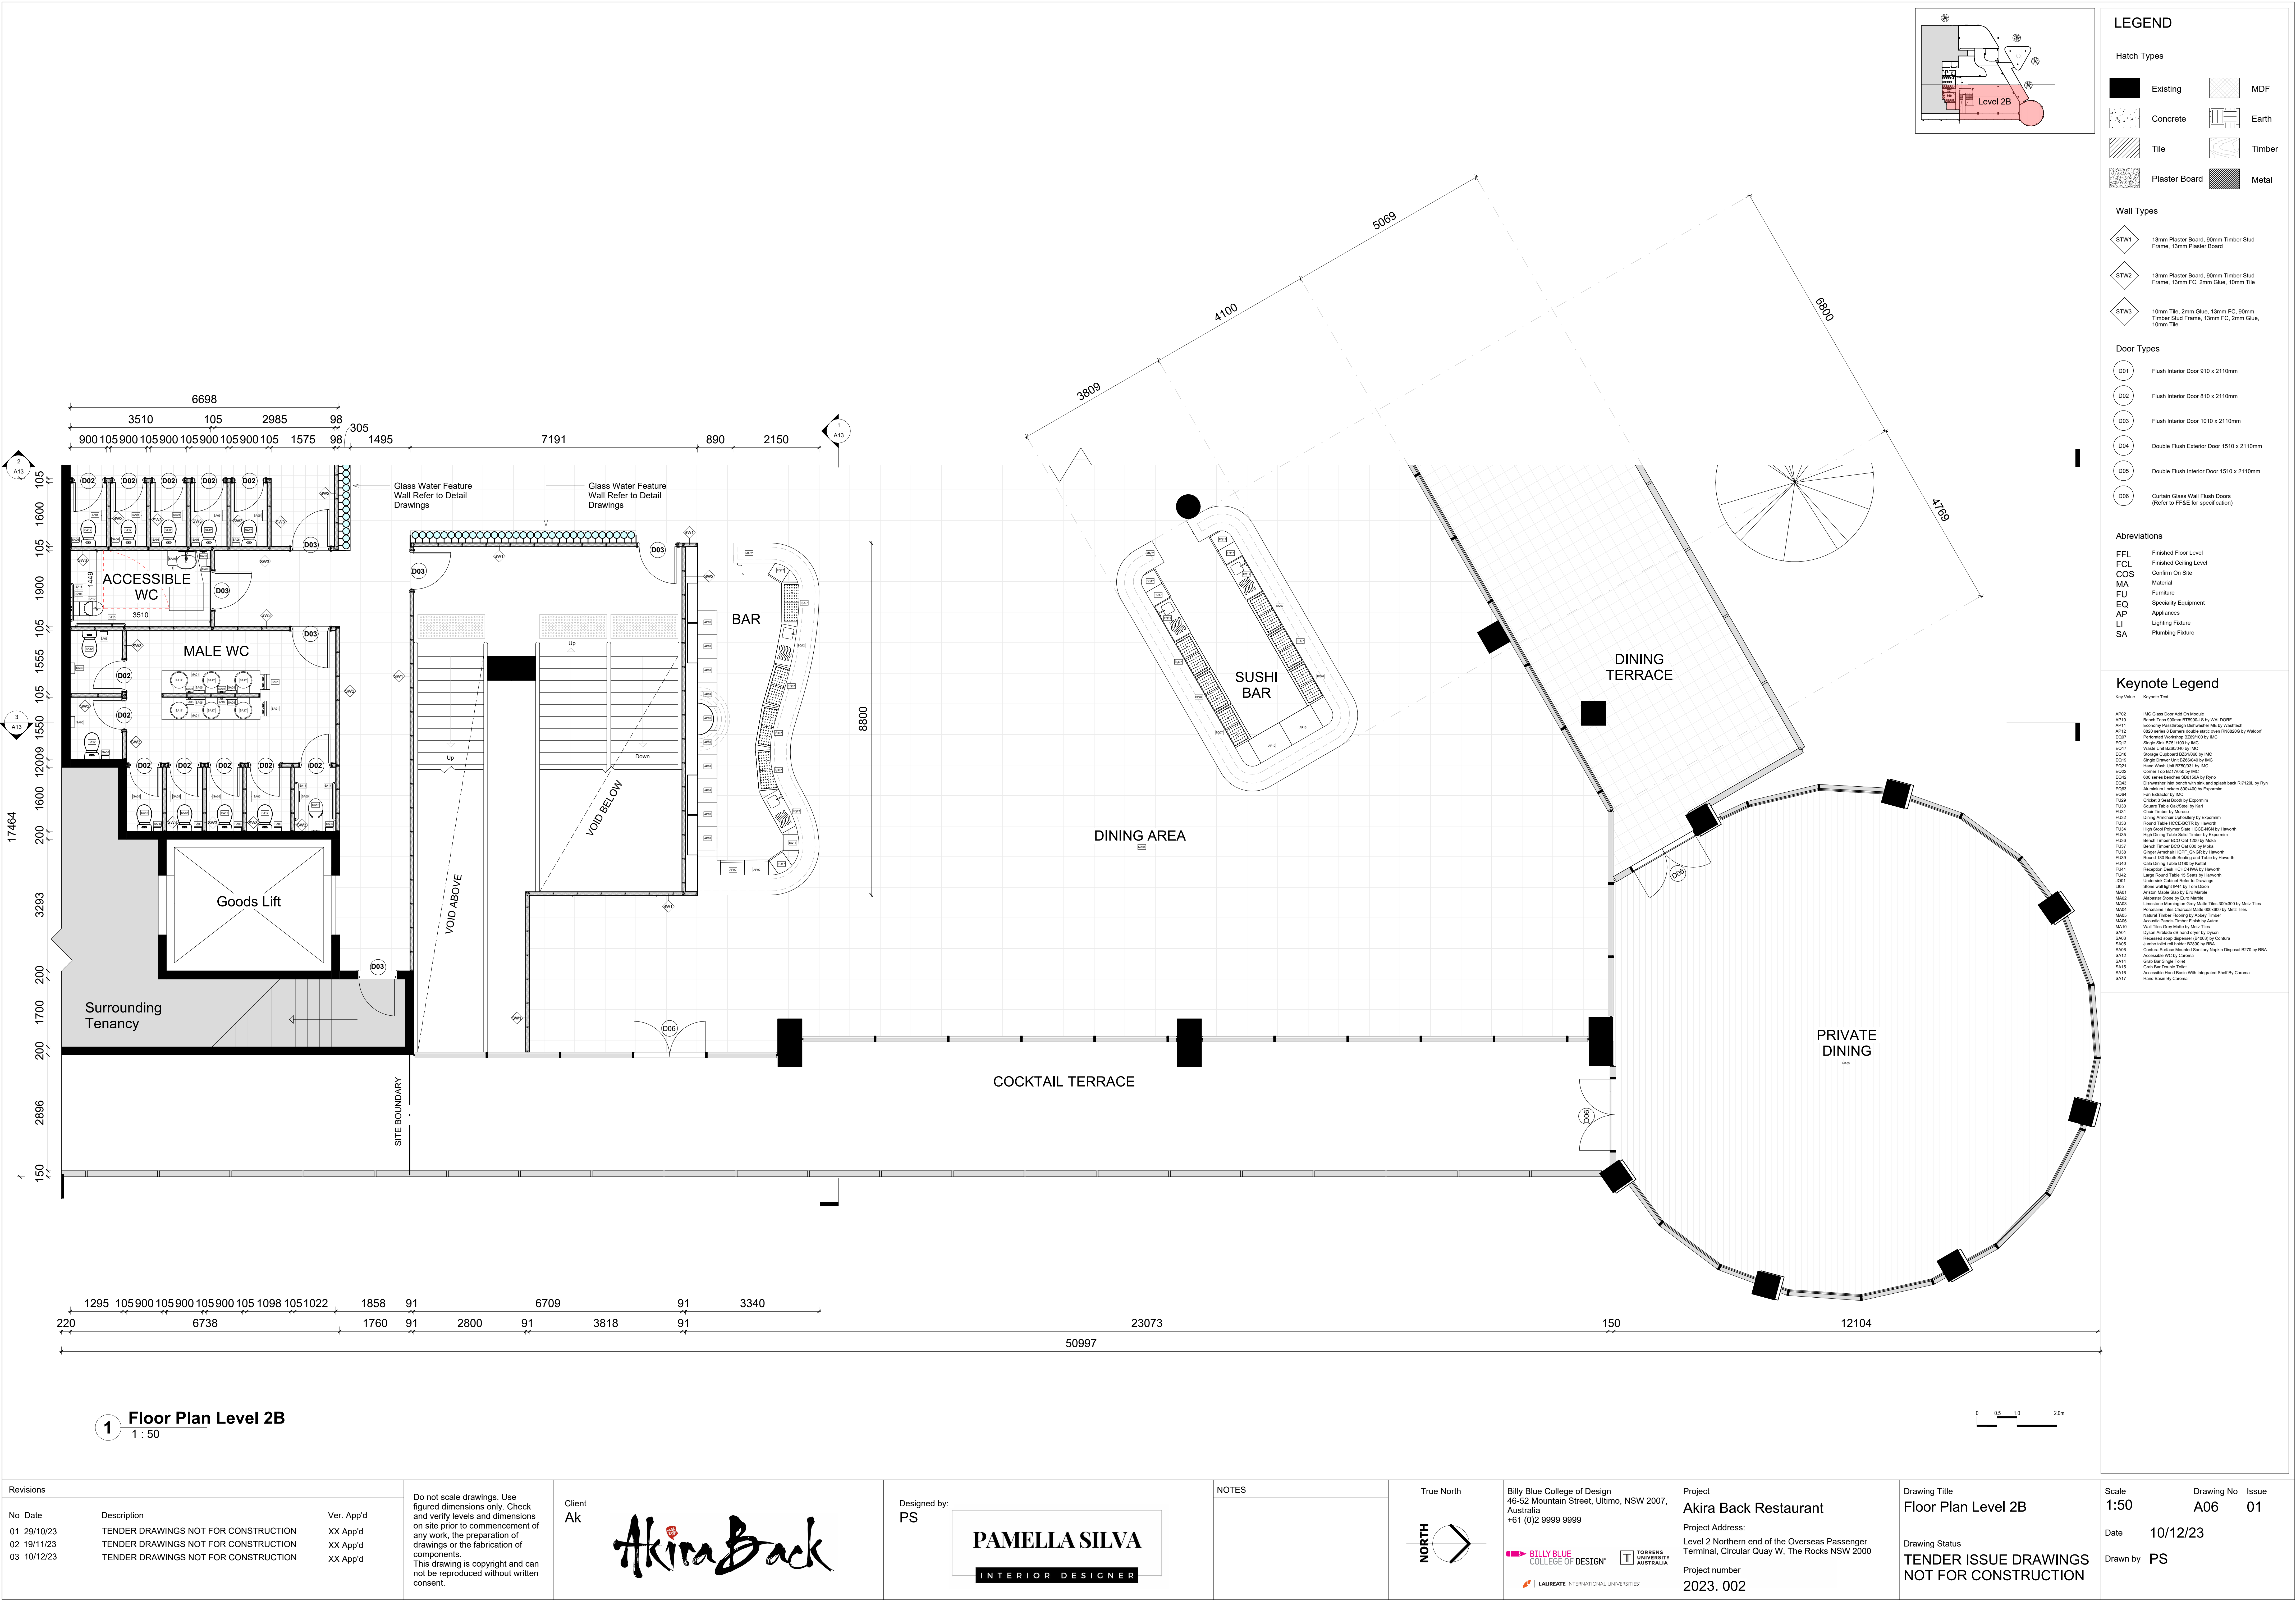

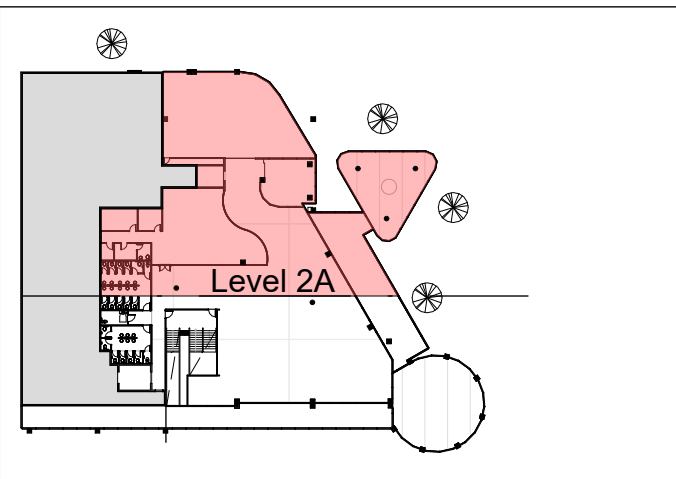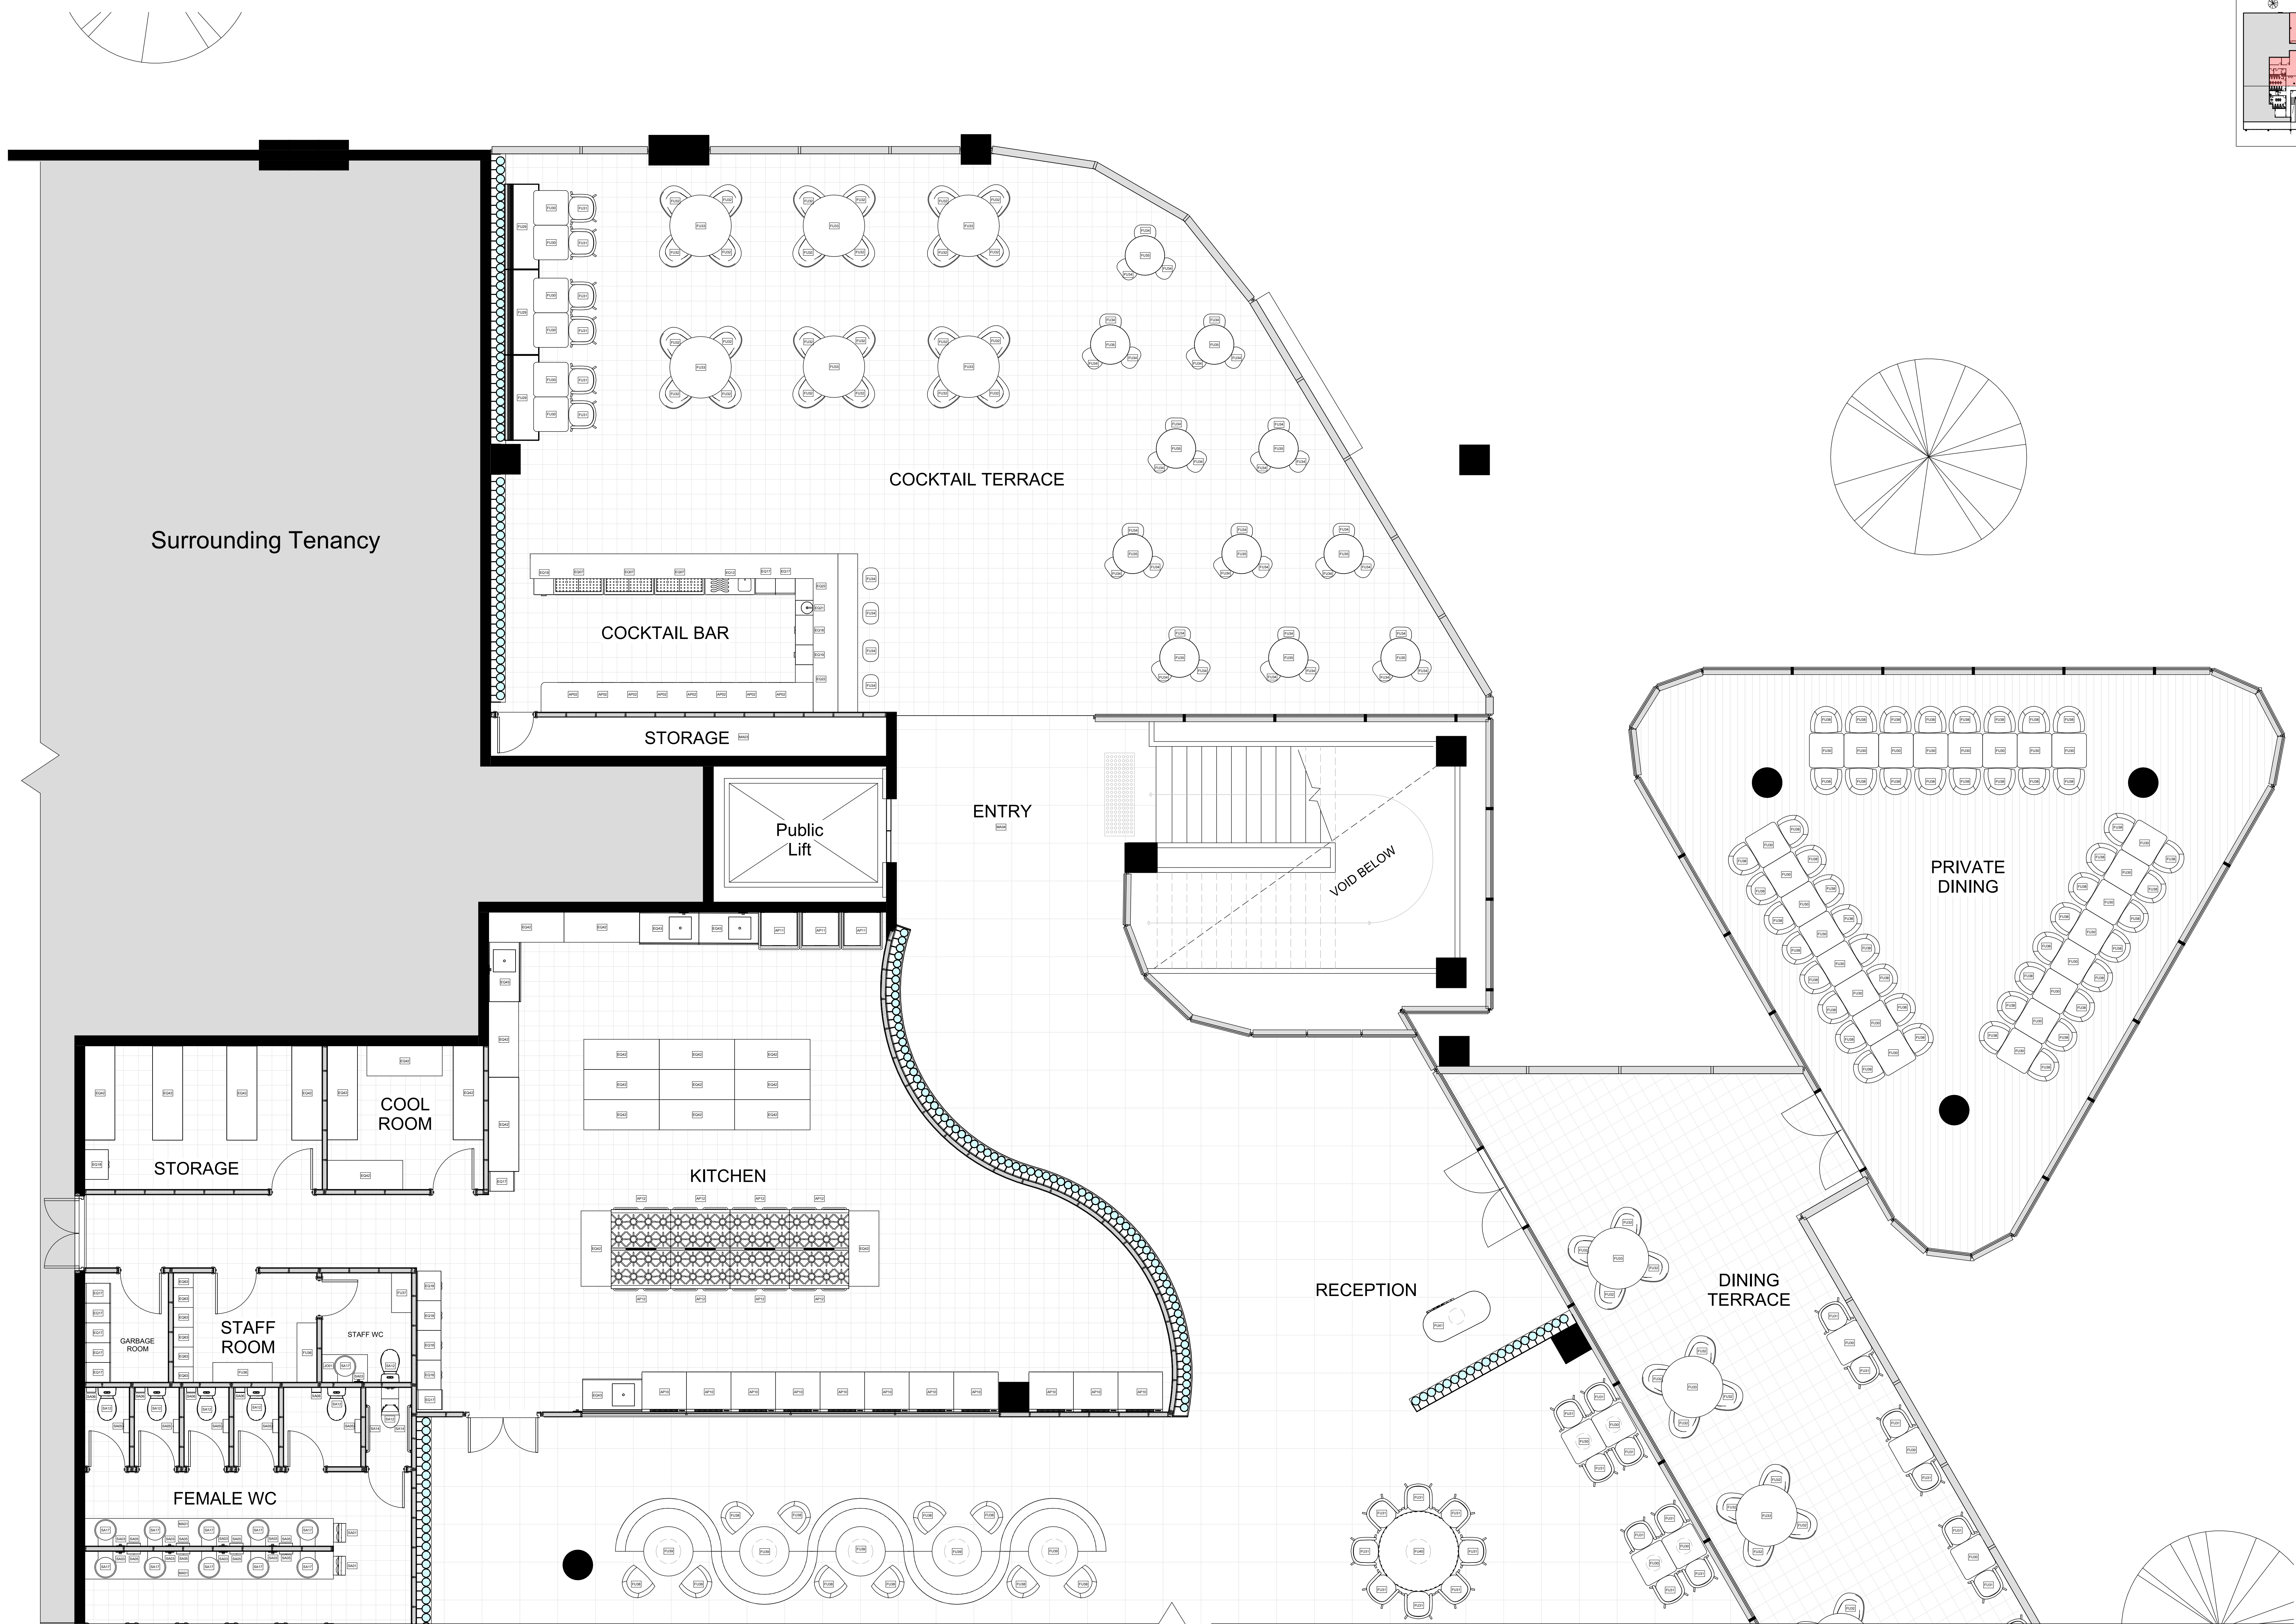

LEGEND

Hatch Types

- | | |
|---------------|--------|
| Existing | MDF |
| Concrete | Earth |
| Tile | Timber |
| Plaster Board | Metal |

Wall Types

- | | |
|------|--|
| STW1 | 13mm Plaster Board, 90mm Timber Stud Frame, 13mm Plaster Board |
| STW2 | 13mm Plaster Board, 90mm Timber Stud Frame, 13mm FC, 2mm Glue, 10mm Tile |
| STW3 | 10mm Tile, 2mm Glue, 13mm FC, 90mm Timber Stud Frame, 13mm FC, 2mm Glue, 10mm Tile |

Door Types

- | | |
|-----|--|
| D01 | Flush Interior Door 910 x 2110mm |
| D02 | Flush Interior Door 810 x 2110mm |
| D03 | Flush Interior Door 1010 x 2110mm |
| D04 | Double Flush Exterior Door 1510 x 2110mm |
| D05 | Double Flush Interior Door 1510 x 2110mm |
| D06 | Curtain Glass Wall Flush Doors (Refer to FF&E for specification) |

Abbreviations

- | | |
|-----|------------------------|
| FFL | Finished Floor Level |
| FCL | Finished Ceiling Level |
| COS | Confirm On Site |
| MA | Material |
| FU | Furniture |
| EQ | Specialty Equipment |
| AP | Appliances |
| LI | Lighting Fixtures |
| SA | Plumbing Fixtures |

Keynote Legend

- | | |
|-----------|--|
| Key Value | Keynote Text |
| AP02 | M/C Glass Door Add On Module |
| AP10 | Brass Vase (H=1000) by H&L/DOP |
| AP11 | Brass Vase (H=1000) by H&L/DOP |
| AP12 | 800 series 4 Burner stainless steel cooktop (ENB200) by Westcott |
| EQ07 | Professional Worktop (E200) by M/C |
| EQ12 | Single Sink (E200) by M/C |
| EQ17 | Waste Unit (E200) by M/C |
| EQ18 | Storage Cabinet (E200) by M/C |
| EQ19 | Single Drawer Unit (E200) by M/C |
| EQ21 | Hand Wash Unit (E200) by M/C |
| EQ22 | Cover Top (E200) by M/C |
| EQ23 | 800 series (H=1000) by Ryn |
| EQ24 | Chamber and bench with sink and splash back (H=1000) by Ryn |
| EQ25 | Appliances (H=1000) by Ryn |
| EQ26 | For Exterior by M/C |
| EQ27 | Clean Table (H=1000) by Ryn |
| EQ28 | Square Table (H=1000) by Ryn |
| EQ29 | Round Table (H=1000) by Ryn |
| EQ30 | High Speed Plaster (H=1000) by Ryn |
| EQ31 | High Speed Plaster (H=1000) by Ryn |
| EQ32 | Round Table (H=1000) by Ryn |
| EQ33 | Round Table (H=1000) by Ryn |
| EQ34 | Round Table (H=1000) by Ryn |
| EQ100 | Round Table (H=1000) by Ryn |

1 Furniture Plan Level 2A
1 : 50

0 0.5 1.0 2.0m

Revisions

No	Date	Description	Ver.	App'd
01	29/10/23	TENDER DRAWINGS NOT FOR CONSTRUCTION	XX	App'd
02	19/11/23	TENDER DRAWINGS NOT FOR CONSTRUCTION	XX	App'd
03	10/12/23	TENDER DRAWINGS NOT FOR CONSTRUCTION	XX	App'd

Do not scale drawings. Use figured dimensions only. Check and verify levels and dimensions on site prior to commencement of any work, the preparation of drawings or the fabrication of components. This drawing is copyright and can not be reproduced without written consent.

Client
Ak


Akira Back

Designed by:
PS

PAMELLA SILVA
INTERIOR DESIGNER

NOTES

True North

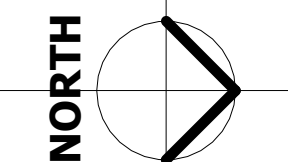

Billy Blue College of Design
46-52 Mountain Street, Ultimo, NSW 2007,
Australia
+61 (0)2 9999 9999



Project
Akira Back Restaurant

Project Address:
Level 2 Northern end of the Overseas Passenger
Terminal, Circular Quay W, The Rocks NSW 2000

Project number
2023. 002

Drawing Title
Furniture Plan Level 2A

Drawing Status
TENDER ISSUE DRAWINGS
NOT FOR CONSTRUCTION

Scale
1:50

Date
10/12/23


Drawn by
PS

Drawing No
A07

Issue
01

05/12/2023 14:32:57

A0

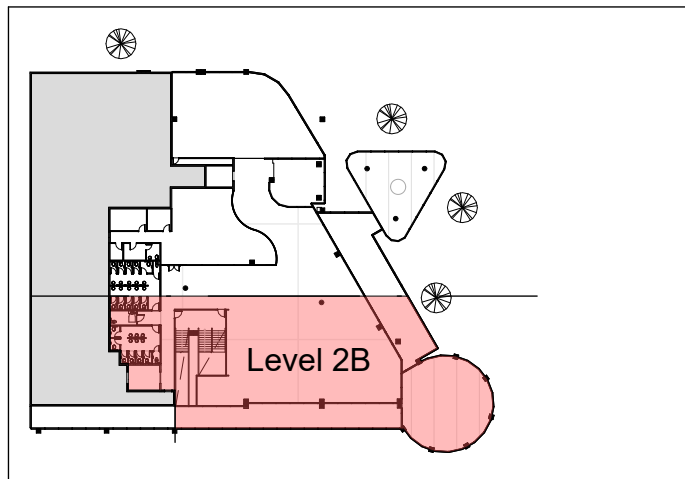

LEGEND

Hatch Types

- Existing

Concrete

Tile

Plaster Board
- MDF

Earth

Timber

Metal

Wall Types

- STW1

13mm Plaster Board, 50mm Timber Stud Frame, 13mm Plaster Board
- STW2

13mm Plaster Board, 90mm Timber Stud Frame, 13mm FC, 2mm Glue, 10mm Tie
- STW3

10mm Tile, 2mm Glue, 13mm FC, 90mm Timber Stud Frame, 13mm FC, 2mm Glue, 10mm Tie

Door Types

- D01

Flush Interior Door 910 x 2110mm
- D02

Flush Interior Door 810 x 2110mm
- D03

Flush Interior Door 1010 x 2110mm
- D04

Double Flush Exterior Door 1510 x 2110mm
- D05

Double Flush Interior Door 1510 x 2110mm
- D06

Curtain Glass Wall Flush Doors (Refer to FF&E for specification)

Abbreviations

- FFL

Finished Floor Level
- FCL

Finished Ceiling Level
- COS

Confirm On Site
- MA

Material
- FU

Furniture
- EQ

Specialty Equipment
- AP

Appliances
- LI

Lighting Fixtures
- SA

Plumbing Fixtures

Keynote Legend

- Key Value

Keynote Text
- AK01

MC Glass Door Add On Module
- AK02

Brass Vase (AK01) (AK02) by H&M/DOFF
- AK03

Brass Vase (AK01) (AK02) by H&M/DOFF
- AK04

Brass Vase (AK01) (AK02) by H&M/DOFF
- AK05

Brass Vase (AK01) (AK02) by H&M/DOFF
- AK06

Brass Vase (AK01) (AK02) by H&M/DOFF
- AK07

Brass Vase (AK01) (AK02) by H&M/DOFF
- AK08

Brass Vase (AK01) (AK02) by H&M/DOFF
- AK09

Brass Vase (AK01) (AK02) by H&M/DOFF
- AK10

Brass Vase (AK01) (AK02) by H&M/DOFF
- AK11

Brass Vase (AK01) (AK02) by H&M/DOFF
- AK12

Brass Vase (AK01) (AK02) by H&M/DOFF
- AK13

Brass Vase (AK01) (AK02) by H&M/DOFF
- AK14

Brass Vase (AK01) (AK02) by H&M/DOFF
- AK15

Brass Vase (AK01) (AK02) by H&M/DOFF
- AK16

Brass Vase (AK01) (AK02) by H&M/DOFF
- AK17

Brass Vase (AK01) (AK02) by H&M/DOFF
- AK18

Brass Vase (AK01) (AK02) by H&M/DOFF
- AK19

Brass Vase (AK01) (AK02) by H&M/DOFF
- AK20

Brass Vase (AK01) (AK02) by H&M/DOFF
- AK21

Brass Vase (AK01) (AK02) by H&M/DOFF
- AK22

Brass Vase (AK01) (AK02) by H&M/DOFF
- AK23

Brass Vase (AK01) (AK02) by H&M/DOFF
- AK24

Brass Vase (AK01) (AK02) by H&M/DOFF
- AK25

Brass Vase (AK01) (AK02) by H&M/DOFF
- AK26

Brass Vase (AK01) (AK02) by H&M/DOFF
- AK27

Brass Vase (AK01) (AK02) by H&M/DOFF
- AK28

Brass Vase (AK01) (AK02) by H&M/DOFF
- AK29

Brass Vase (AK01) (AK02) by H&M/DOFF
- AK30

Brass Vase (AK01) (AK02) by H&M/DOFF
- AK31

Brass Vase (AK01) (AK02) by H&M/DOFF
- AK32

Brass Vase (AK01) (AK02) by H&M/DOFF
- AK33

Brass Vase (AK01) (AK02) by H&M/DOFF
- AK34

Brass Vase (AK01) (AK02) by H&M/DOFF
- AK35

Brass Vase (AK01) (AK02) by H&M/DOFF
- AK36

Brass Vase (AK01) (AK02) by H&M/DOFF
- AK37

Brass Vase (AK01) (AK02) by H&M/DOFF
- AK38

Brass Vase (AK01) (AK02) by H&M/DOFF
- AK39

Brass Vase (AK01) (AK02) by H&M/DOFF
- AK40

Brass Vase (AK01) (AK02) by H&M/DOFF
- AK41

Brass Vase (AK01) (AK02) by H&M/DOFF
- AK42

Brass Vase (AK01) (AK02) by H&M/DOFF
- AK43

Brass Vase (AK01) (AK02) by H&M/DOFF
- AK44

Brass Vase (AK01) (AK02) by H&M/DOFF
- AK45

Brass Vase (AK01) (AK02) by H&M/DOFF
- AK46

Brass Vase (AK01) (AK02) by H&M/DOFF
- AK47

Brass Vase (AK01) (AK02) by H&M/DOFF
- AK48

Brass Vase (AK01) (AK02) by H&M/DOFF
- AK49

Brass Vase (AK01) (AK02) by H&M/DOFF
- AK50

Brass Vase (AK01) (AK02) by H&M/DOFF
- AK51

Brass Vase (AK01) (AK02) by H&M/DOFF
- AK52

Brass Vase (AK01) (AK02) by H&M/DOFF
- AK53

Brass Vase (AK01) (AK02) by H&M/DOFF
- AK54

Brass Vase (AK01) (AK02) by H&M/DOFF
- AK55

Brass Vase (AK01) (AK02) by H&M/DOFF
- AK56

Brass Vase (AK01) (AK02) by H&M/DOFF
- AK57

Brass Vase (AK01) (AK02) by H&M/DOFF
- AK58

Brass Vase (AK01) (AK02) by H&M/DOFF
- AK59

Brass Vase (AK01) (AK02) by H&M/DOFF
- AK60

Brass Vase (AK01) (AK02) by H&M/DOFF
- AK61

Brass Vase (AK01) (AK02) by H&M/DOFF
- AK62

Brass Vase (AK01) (AK02) by H&M/DOFF
- AK63

Brass Vase (AK01) (AK02) by H&M/DOFF
- AK64

Brass Vase (AK01) (AK02) by H&M/DOFF
- AK65

Brass Vase (AK01) (AK02) by H&M/DOFF
- AK66

Brass Vase (AK01) (AK02) by H&M/DOFF
- AK67

Brass Vase (AK01) (AK02) by H&M/DOFF
- AK68

Brass Vase (AK01) (AK02) by H&M/DOFF
- AK69

Brass Vase (AK01) (AK02) by H&M/DOFF
- AK70

Brass Vase (AK01) (AK02) by H&M/DOFF
- AK71

Brass Vase (AK01) (AK02) by H&M/DOFF
- AK72

Brass Vase (AK01) (AK02) by H&M/DOFF
- AK73

Brass Vase (AK01) (AK02) by H&M/DOFF
- AK74

Brass Vase (AK01) (AK02) by H&M/DOFF
- AK75

Brass Vase (AK01) (AK02) by H&M/DOFF
- AK76

Brass Vase (AK01) (AK02) by H&M/DOFF
- AK77

Brass Vase (AK01) (AK02) by H&M/DOFF
- AK78

Brass Vase (AK01) (AK02) by H&M/DOFF
- AK79

Brass Vase (AK01) (AK02) by H&M/DOFF
- AK80

Brass Vase (AK01) (AK02) by H&M/DOFF
- AK81

Brass Vase (AK01) (AK02) by H&M/DOFF
- AK82

Brass Vase (AK01) (AK02) by H&M/DOFF
- AK83

Brass Vase (AK01) (AK02) by H&M/DOFF
- AK84

Brass Vase (AK01) (AK02) by H&M/DOFF
- AK85

Brass Vase (AK01) (AK02) by H&M/DOFF
- AK86

Brass Vase (AK01) (AK02) by H&M/DOFF
- AK87

Brass Vase (AK01) (AK02) by H&M/DOFF
- AK88

Brass Vase (AK01) (AK02) by H&M/DOFF
- AK89

Brass Vase (AK01) (AK02) by H&M/DOFF
- AK90

Brass Vase (AK01) (AK02) by H&M/DOFF
- AK91

Brass Vase (AK01) (AK02) by H&M/DOFF
- AK92

Brass Vase (AK01) (AK02) by H&M/DOFF
- AK93

Brass Vase (AK01) (AK02) by H&M/DOFF
- AK94

Brass Vase (AK01) (AK02) by H&M/DOFF
- AK95

Brass Vase (AK01) (AK02) by H&M/DOFF
- AK96


Brass Vase (AK01) (AK02) by H&M/DOFF
- AK97

Brass Vase (AK01) (AK02) by H&M/DOFF
- AK98

Brass Vase (AK01) (AK02) by H&M/DOFF
- AK99

Brass Vase (AK01) (AK02) by H&M/DOFF
- AK100


Brass Vase (AK01) (AK02) by H&M/DOFF

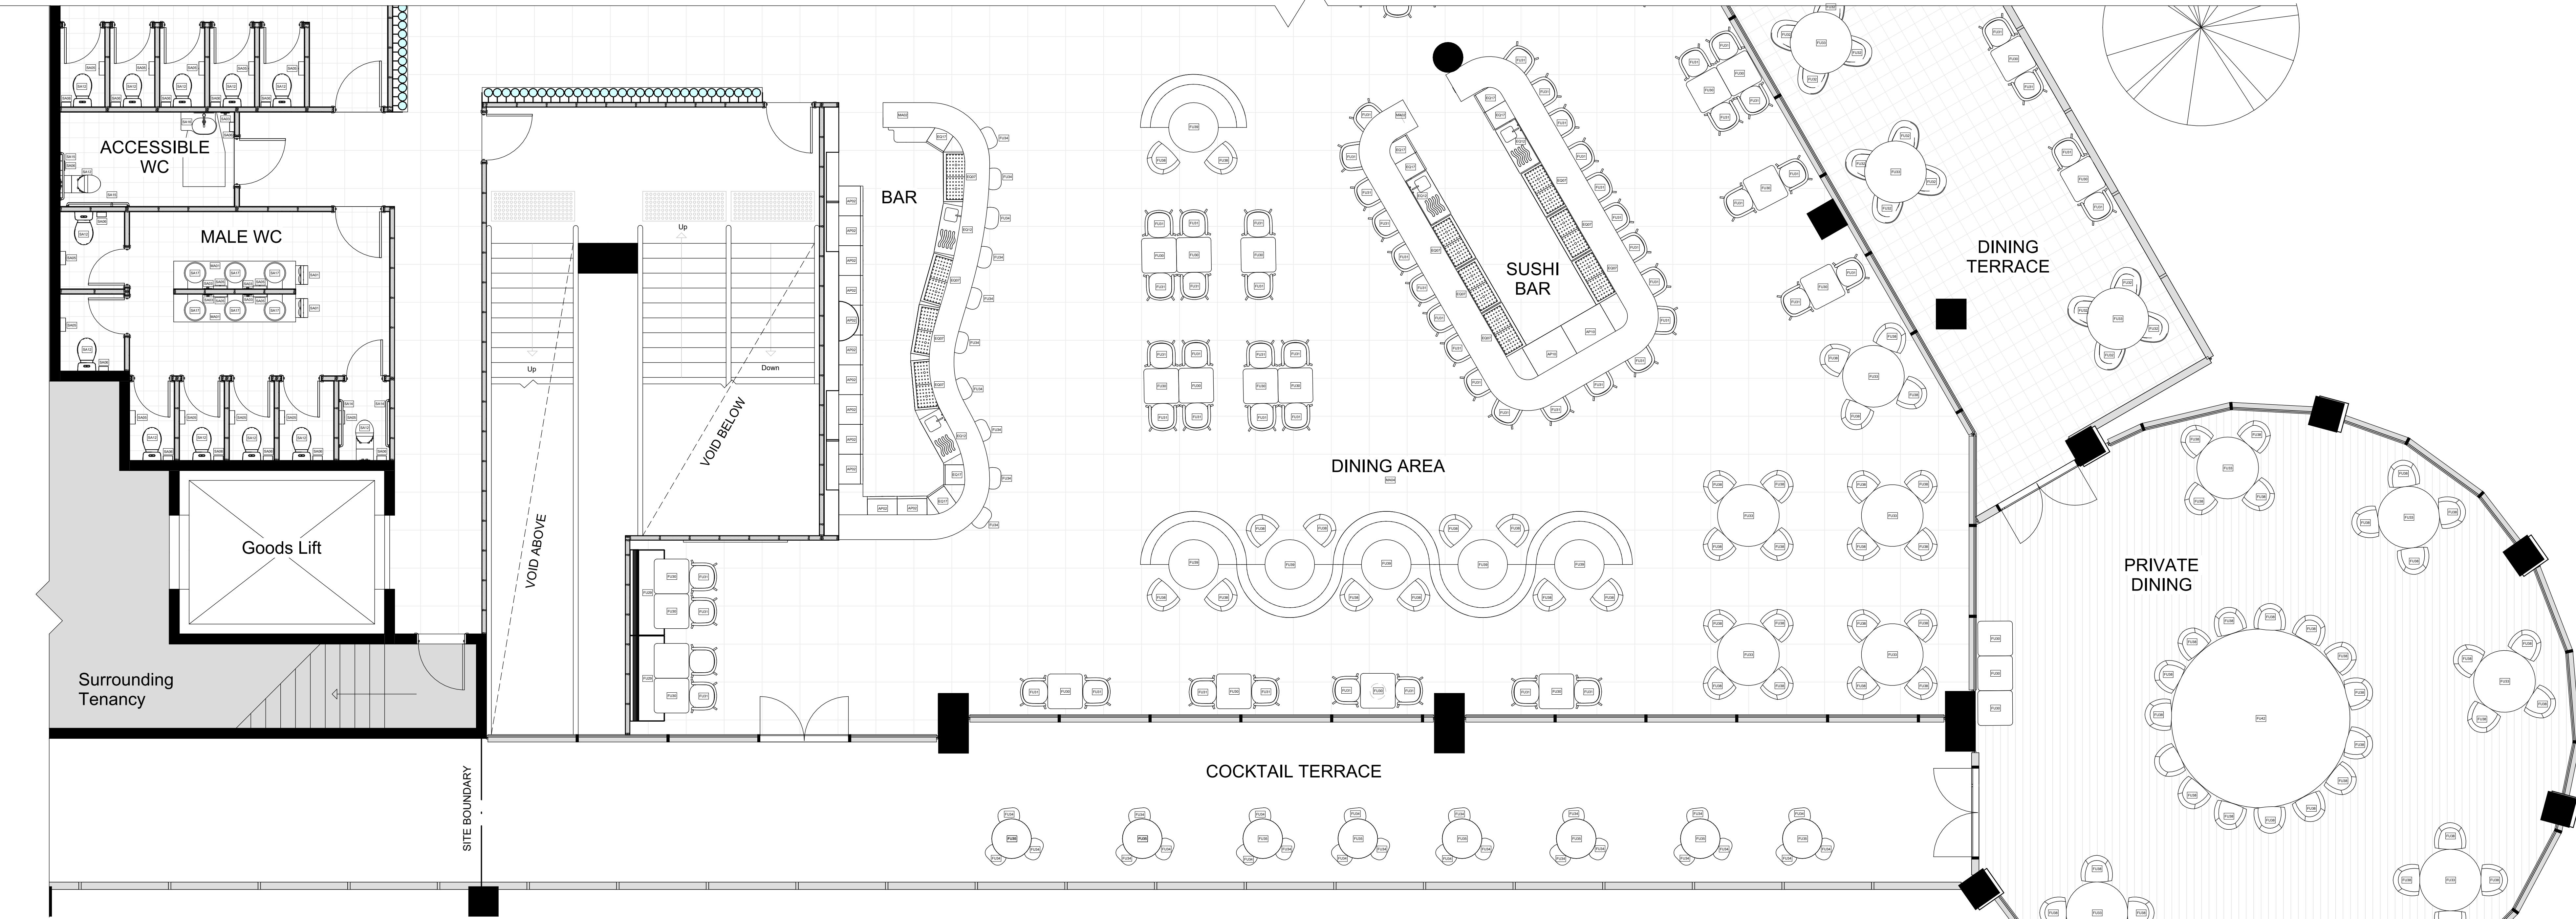

1 Furniture Plan Level 2B
1 : 50




Revisions			Do not scale drawings. Use figured dimensions only. Check and verify levels and dimensions on site prior to commencement of any work, the preparation of drawings or the fabrication of components. This drawing is copyright and can not be reproduced without written consent.	Client Ak	Designed by: PS	<div><div>PAMELLA SILVA</div><div>INTERIOR DESIGNER</div></div>	NOTES	<div>True North</div> <div></div>	<div>Billy Blue College of Design 46-52 Mountain Street, Ultimo, NSW 2007, Australia +61 (0)2 9999 9999</div> <div> BILLY BLUE COLLEGE OF DESIGN</div> <div> TORRENS UNIVERSITY AUSTRALIA</div> <div> LAUREATE INTERNATIONAL UNIVERSITIES</div>	<div>Project Akira Back Restaurant</div> <div>Project Address: Level 2 Northern end of the Overseas Passenger Terminal, Circular Quay W, The Rocks NSW 2000</div> <div>Project number 2023. 002</div>	<div>Drawing Title Furniture Plan Level 2B</div> <div>Drawing Status TENDER ISSUE DRAWINGS NOT FOR CONSTRUCTION</div>	<div>Scale 1:50</div> <div>Date 10/12/23</div> <div>Drawn by PS</div>	<div>Drawing No A08</div> <div>Issue 01</div>	
No	Date	Description												Ver. App'd
01	29/10/23	TENDER DRAWINGS NOT FOR CONSTRUCTION												XX App'd
02	19/11/23	TENDER DRAWINGS NOT FOR CONSTRUCTION												XX App'd
03	10/12/23	TENDER DRAWINGS NOT FOR CONSTRUCTION												XX App'd

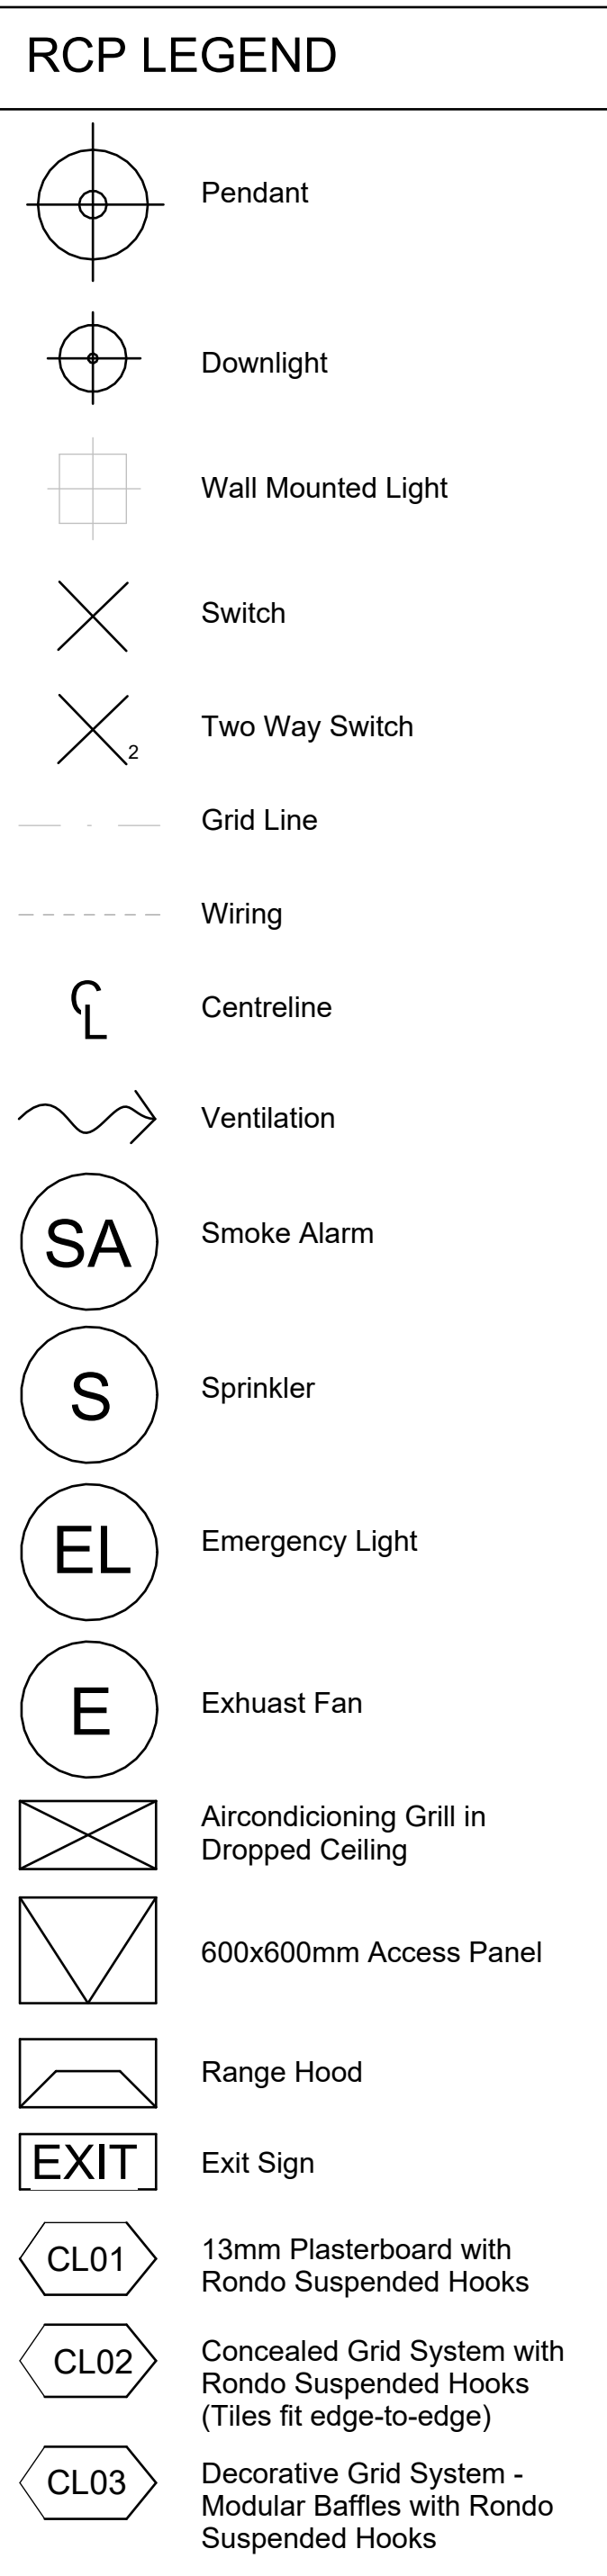


1 RCP Level 2A
1 : 50

[illegible]

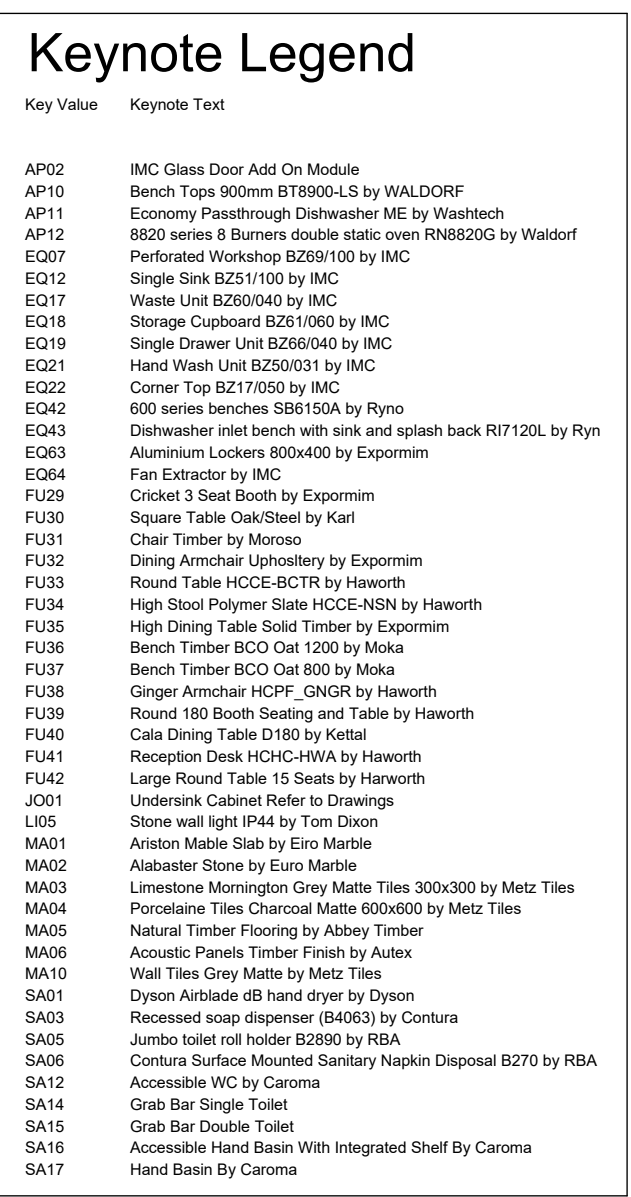


LEGEND

 
Hatch Types




Existing




MDF




Concrete

 


Earth




Tile



Timber

 


Plaster Board




Metal

Wall Types




STW1

 13mm Plaster Board, 90mm Timber Stud Frame, 13mm Plaster Board




STW2

13mm Plaster Board, 90mm Timber Stud Frame, 13mm FC, 2mm Glue, 10mm Tie



STW3


10mm Tie, 2mm Glue, 13mm FC, 90mm Timber Stud Frame, 13mm FC, 2mm Glue, 10mm Tie



STW3

 
10mm Tie, 2mm Glue, 13mm FC, 90mm Timber Stud Frame, 13mm FC, 2mm Glue, 10mm Tie

Door Types




D01

Flush Interior Door 910 x 2110mm




D02

Flush Interior Door 810 x 2110mm




D03

 Flush Interior Door 1010 x 2110mm




D04

Double Flush Exterior Door 1510 x 2110mm



D05

Double Flush Interior Door 1510 x 2110mm



D06

Curtain Glass Wall Flush Doors (Refer to FF&E for specification)

Abbreviations

FFL

Finished Floor Level

FCL

Finished Ceiling Level

COS

Confirm On Site

MA

Material

FU

Furniture

EQ

Specialty Equipment

AP

Appliances

LI

Lighting Fixture


SA

Plumbing Fixture

RCP LEGEND	
	Pendant
	Downlight
	Wall Mounted Light
	Switch
	Two Way Switch
	Grid Line
	Wiring
	Centreline
	Ventilation
	Smoke Alarm
	Sprinkler
	Emergency Light
	Exhaust Fan
	Airconditioning Grill in Dropped Ceiling
	600x600mm Access Panel
	Range Hood
	Exit Sign
	13mm Plasterboard with Rondo Suspended Hooks
	Concealed Grid System with Rondo Suspended Hooks (Tiles fit edge-to-edge)
	Decorative Grid System - Modular Baffles with Rondo Suspended Hooks




Revisions			<div>Do not scale drawings. Use figured dimensions only. Check and verify levels and dimensions on site prior to commencement of any work, the preparation of drawings or the fabrication of components. This drawing is copyright and can not be reproduced without written consent.</div>		<div>Client Ak</div> <div></div>		<div>Designed by: PS</div> <div></div>		<div>NOTES</div>		<div>True North </div>		<div>Billy Blue College of Design 46-52 Mountain Street, Ultimo, NSW 2007, Australia +61 (0)2 9999 9999   </div>		<div>Project Akira Back Restaurant Project Address: Level 2 Northern end of the Overseas Passenger Terminal, Circular Quay W, The Rocks NSW 2000 Project number 2023_002</div>		<div>Drawing Title RCP Level 2B Drawing Status TENDER ISSUE DRAWINGS NOT FOR CONSTRUCTION</div>		<div>Drawing No A10 Issue 01 Date 10/12/23 Drawn by PS</div>	

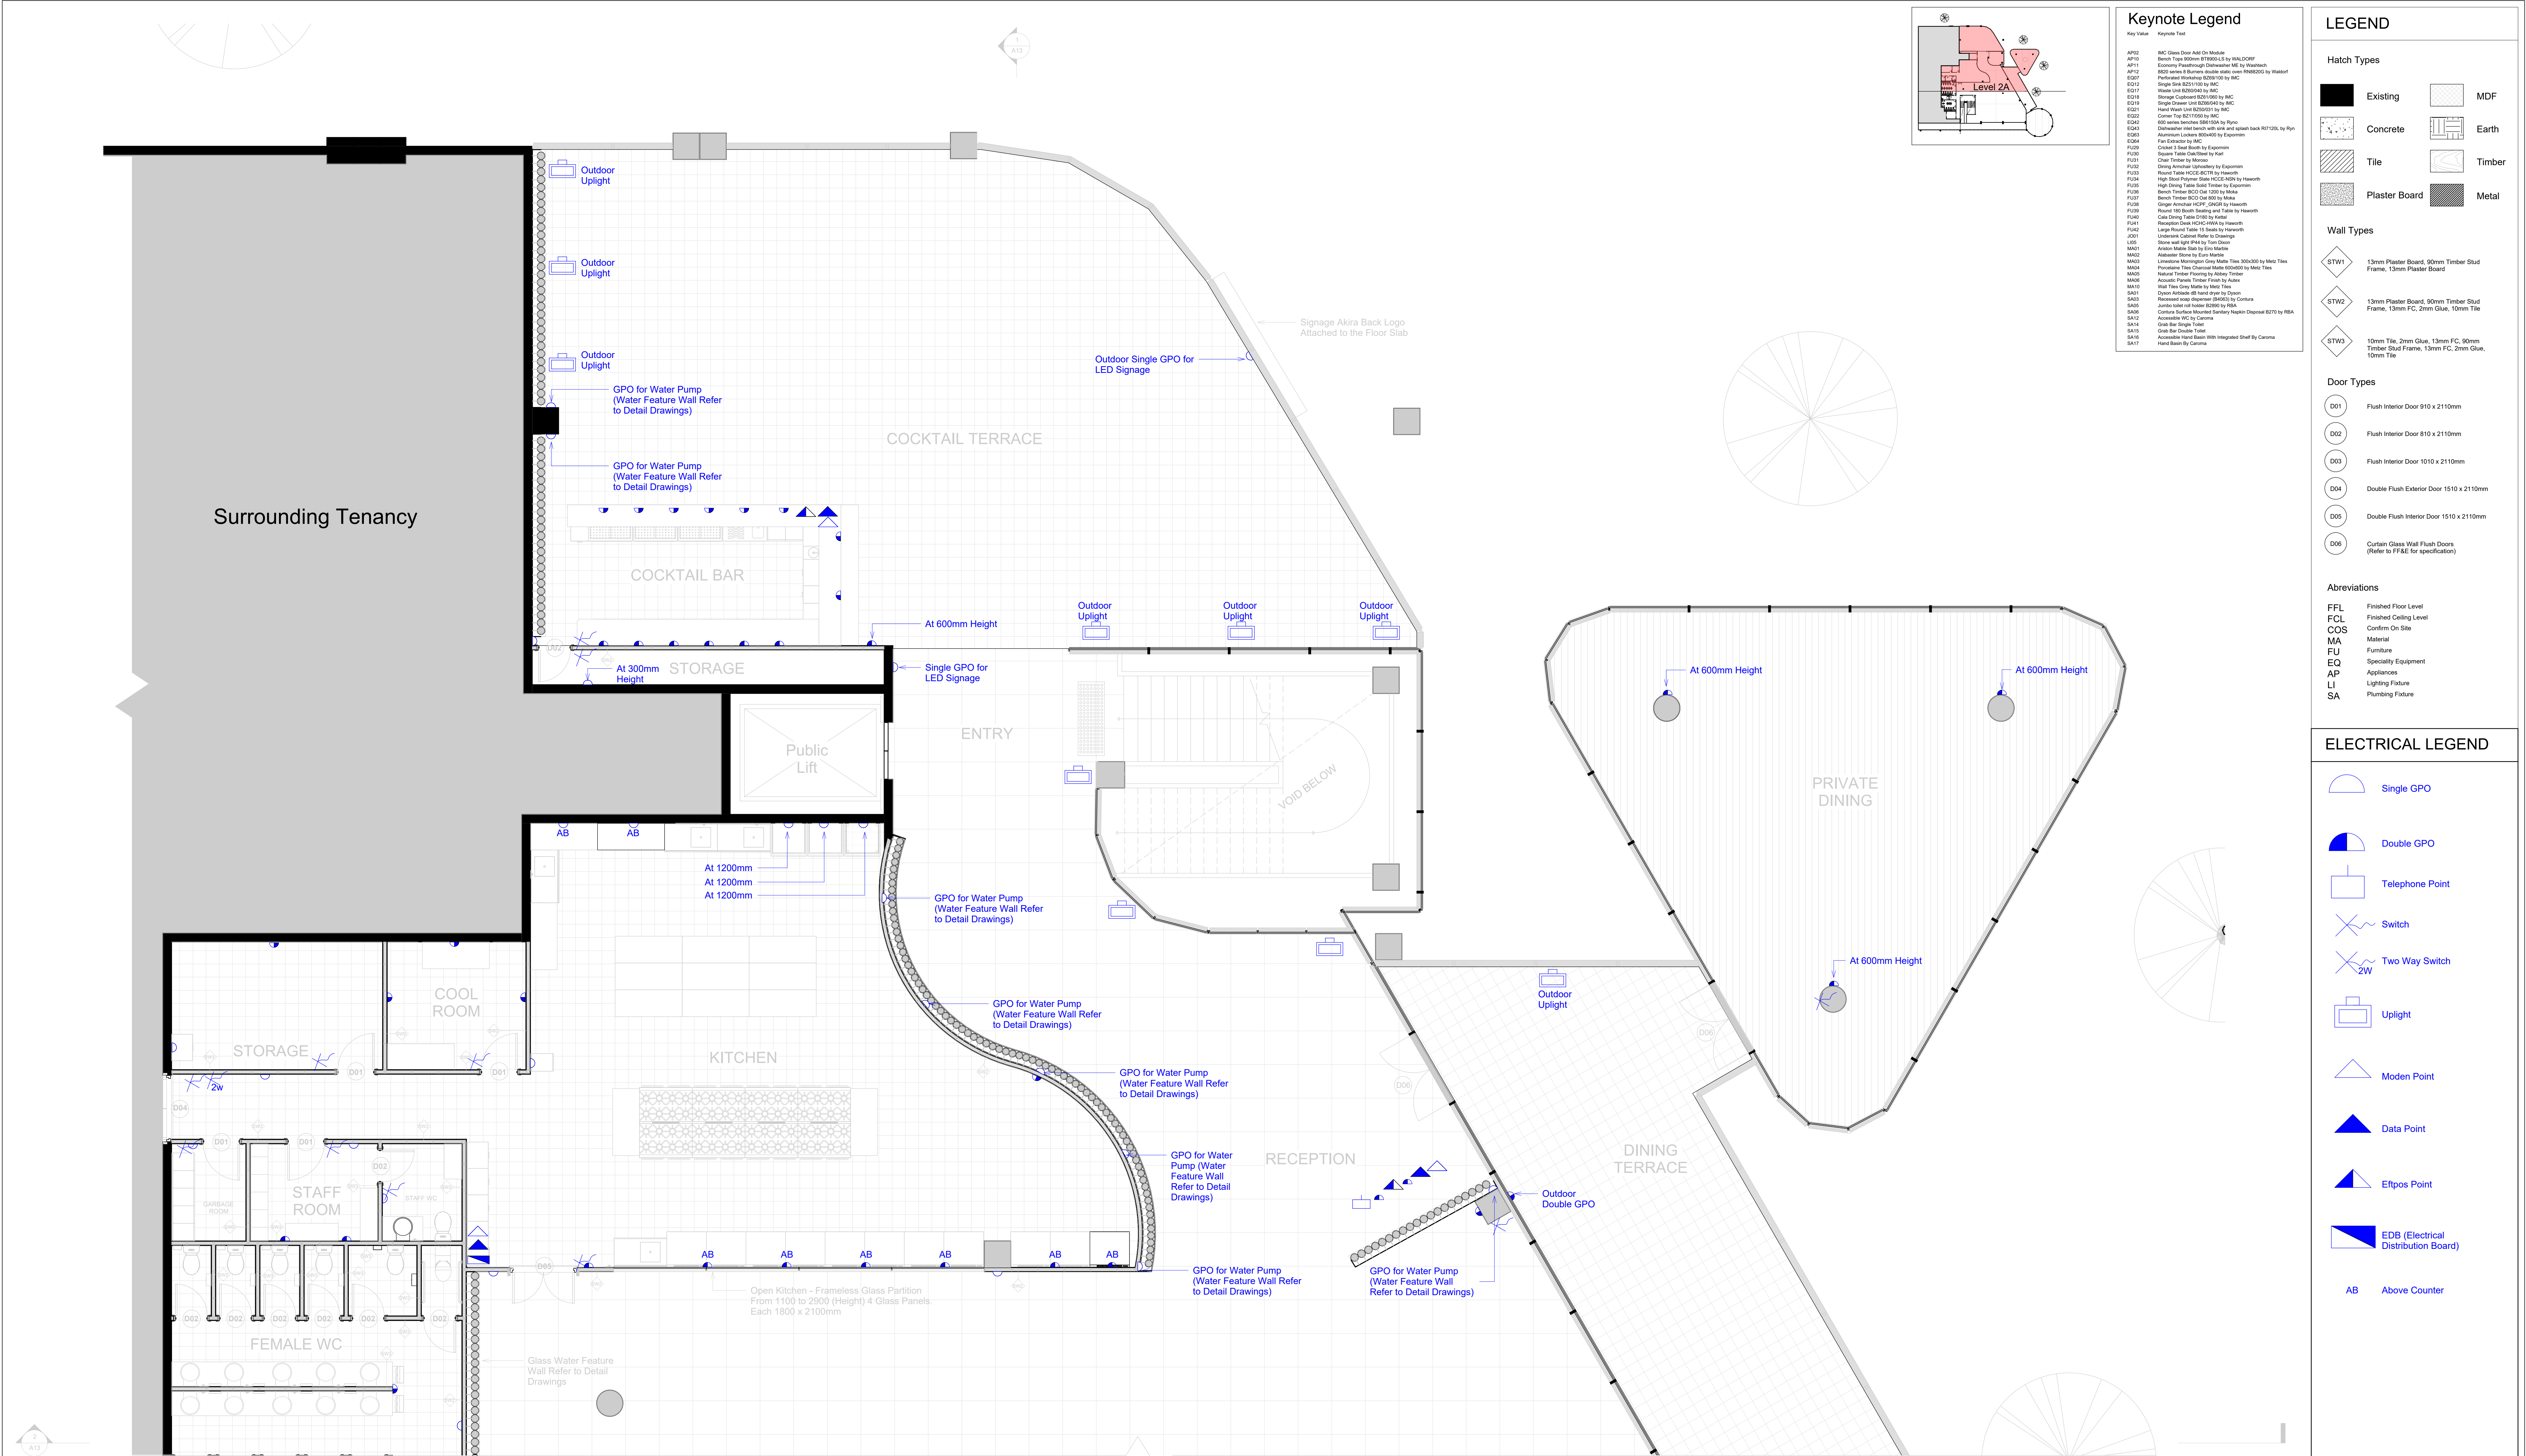


1 Electrical Plan Level 2A
1 : 50

Revisions			Do not scale drawings. Use figured dimensions only. Check and verify levels and dimensions on site prior to commencement of any work, the preparation of drawings or the fabrication of components. This drawing is copyright and can not be reproduced without written consent.	Client Ak	Designed by: PS	NOTES	True North	Project Akira Back Restaurant Project Address: Level 2 Northern end of the Overseas Passenger Terminal, Circular Quay W, The Rocks NSW 2000 Project number 2023. 002	Drawing Title Electrical Plan Level 2A Drawing Status TENDER ISSUE DRAWINGS NOT FOR CONSTRUCTION	Scale 1:50 Date 10/12/23 Drawn by PS	Drawing No A11 Issue 01
No	Date	Description									
01	29/10/23	TENDER DRAWINGS NOT FOR CONSTRUCTION									
02	19/11/23	TENDER DRAWINGS NOT FOR CONSTRUCTION									
03	10/12/23	TENDER DRAWINGS NOT FOR CONSTRUCTION									




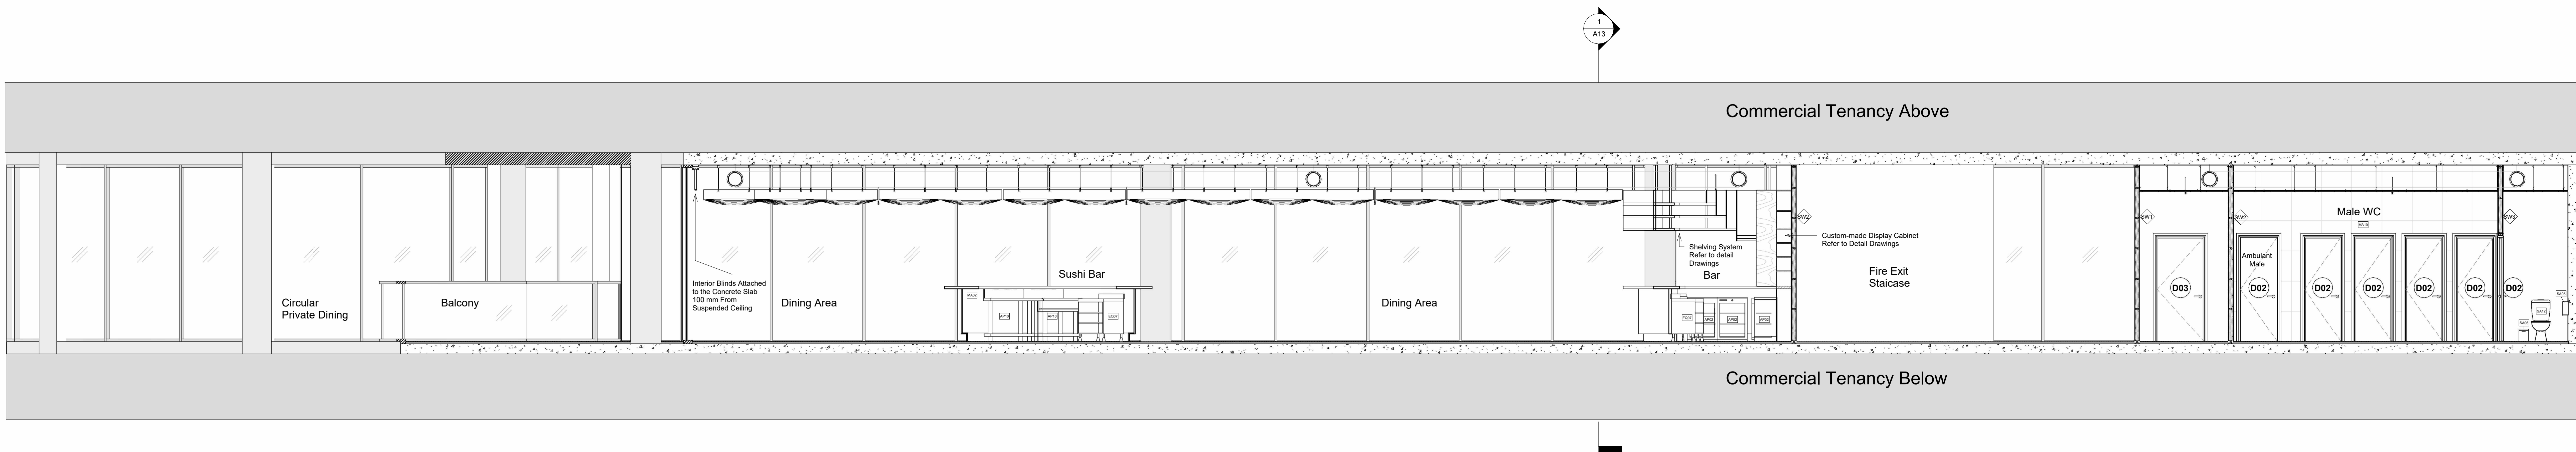

Section 3
1 : 50

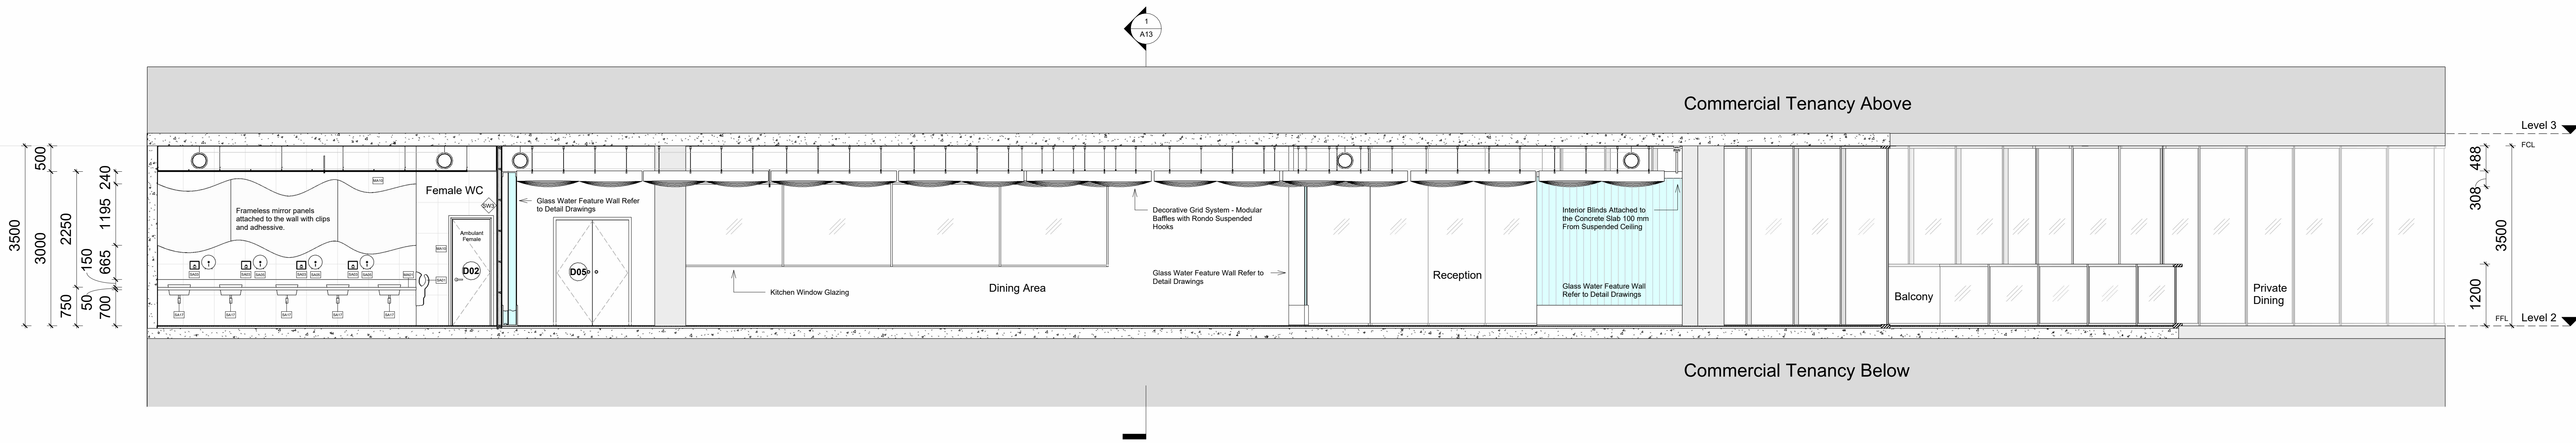

Section 2
1 : 50

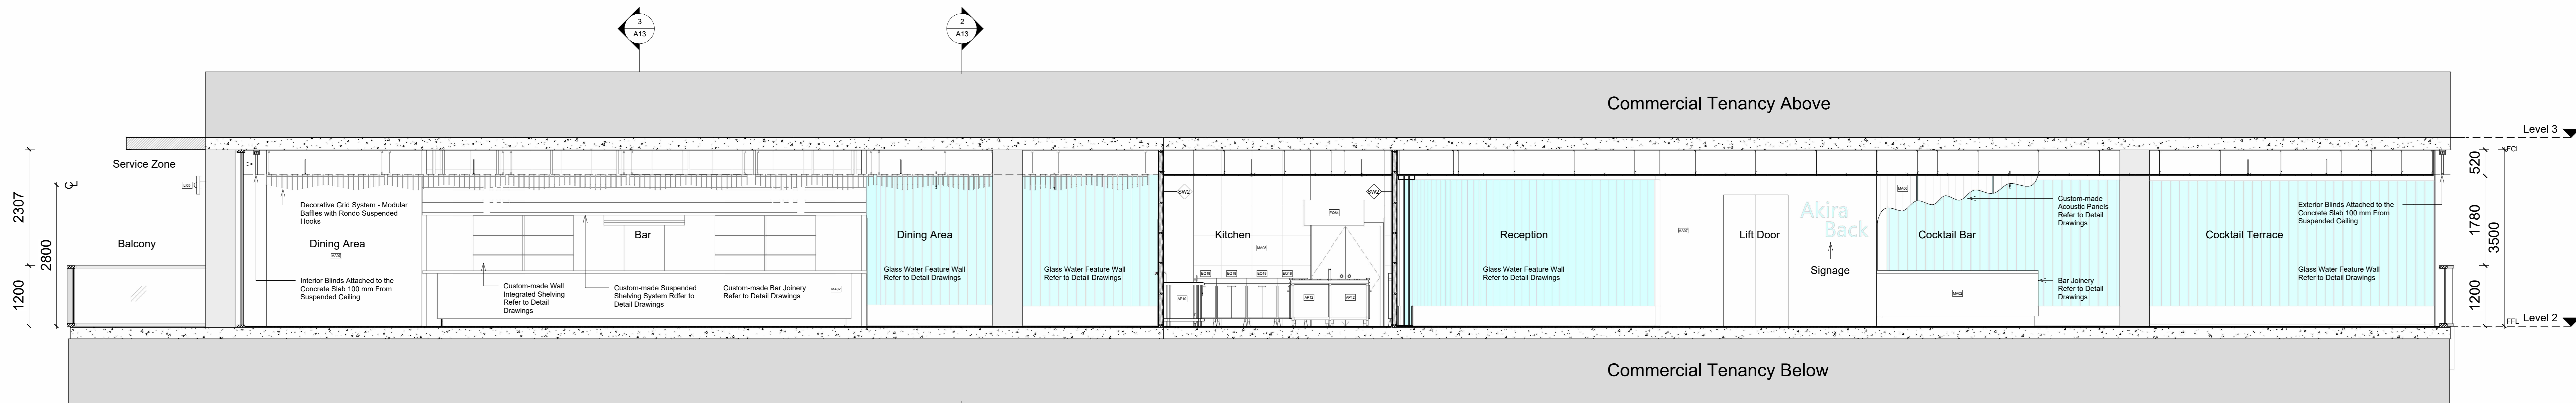

Section 1
1 : 50

LEGEND

Hatch Types

Existing

Concrete

Tile

Plaster Board

MDF

Earth

Timber

Metal

Wall Types

STW1

STW2

STW3

13mm Plaster Board, 50mm Timber Stud Frame, 13mm Plaster Board

13mm Plaster Board, 90mm Timber Stud Frame, 13mm FC, 2mm Glue, 10mm Tile

10mm Tile, 2mm Glue, 13mm FC, 90mm Timber Stud Frame, 13mm FC, 2mm Glue, 10mm Tile

Door Types

D01

D02

D03

D04

D05

D06

Flush Interior Door 910 x 2110mm

Flush Interior Door 810 x 2110mm

Flush Interior Door 1010 x 2110mm

Double Flush Exterior Door 2 x 2110mm

Double Flush Interior Door 1510 x 2110mm

Curtain Glass Wall Flush Doors (Refer to FF&E for specification)

Abbreviations

FFL

FCL

COS

MA

FU

EQ

AP

LI

SA

Finished Floor Level

Finished Ceiling Level

Confirm On Site

Material

Furniture

Specialty Equipment

Appliances

Lighting Fixtures

Plumbing Fixtures

Keynote Legend

Key Value

Keynote Text

AP02

AP10

AP11

AP12

EQ07

EQ12

EQ17

EQ18

EQ19

EQ21

EQ22

EQ23

EQ1000

Revisions			Do not scale drawings. Use figured dimensions only. Check and verify levels and dimensions on site prior to commencement of any work, the preparation of drawings or the fabrication of components. This drawing is copyright and can not be reproduced without written consent.	Client Ak	Designed by: PS	NOTES	True North	Project Akira Back Restaurant	Drawing Title Section 1-3	Scale 1:50	Drawing No A13	Issue 01
No	Date	Description										
01	29/10/23	TENDER DRAWINGS NOT FOR CONSTRUCTION										
02	19/11/23	TENDER DRAWINGS NOT FOR CONSTRUCTION										
03	10/12/23	TENDER DRAWINGS NOT FOR CONSTRUCTION										
			Ver. App'd									
			XX App'd					Project Address: Level 2 Northern end of the Overseas Passenger Terminal, Circular Quay W, The Rocks NSW 2000	Drawing Status TENDER ISSUE DRAWINGS NOT FOR CONSTRUCTION	Date 10/12/23	Drawn by PS	
			XX App'd									
			XX App'd									
								Project number 2023. 002				

05/12/2023 14:34:18

A0



A0 05/12/2023 14:34:29



1 Entry Isometric View

Revisions

No	Date	Description	Ver.	App'd
01	29/10/23	TENDER DRAWINGS NOT FOR CONSTRUCTION	XX	App'd
02	19/11/23	TENDER DRAWINGS NOT FOR CONSTRUCTION	XX	App'd
03	10/12/23	TENDER DRAWINGS NOT FOR CONSTRUCTION	XX	App'd

Do not scale drawings. Use figured dimensions only. Check and verify levels and dimensions on site prior to commencement of any work, the preparation of drawings or the fabrication of components.
This drawing is copyright and can not be reproduced without written consent.

Client
Ak



Designed by:
PS



NOTES


True North

Billy Blue College of Design
46-52 Mountain Street, Ultimo, NSW 2007,
Australia
+61 (0)2 9999 9999


Project
Akira Back Restaurant
Project Address:
Level 2 Northern end of the Overseas Passenger
Terminal, Circular Quay W, The Rocks NSW 2000
Project number
2023. 002

Drawing Title
Entry Isometric View
Drawing Status
TENDER ISSUE DRAWINGS
NOT FOR CONSTRUCTION


Scale
N/A
Date
10/12/23
Drawn by
PS
Drawing No
A15
Issue
01

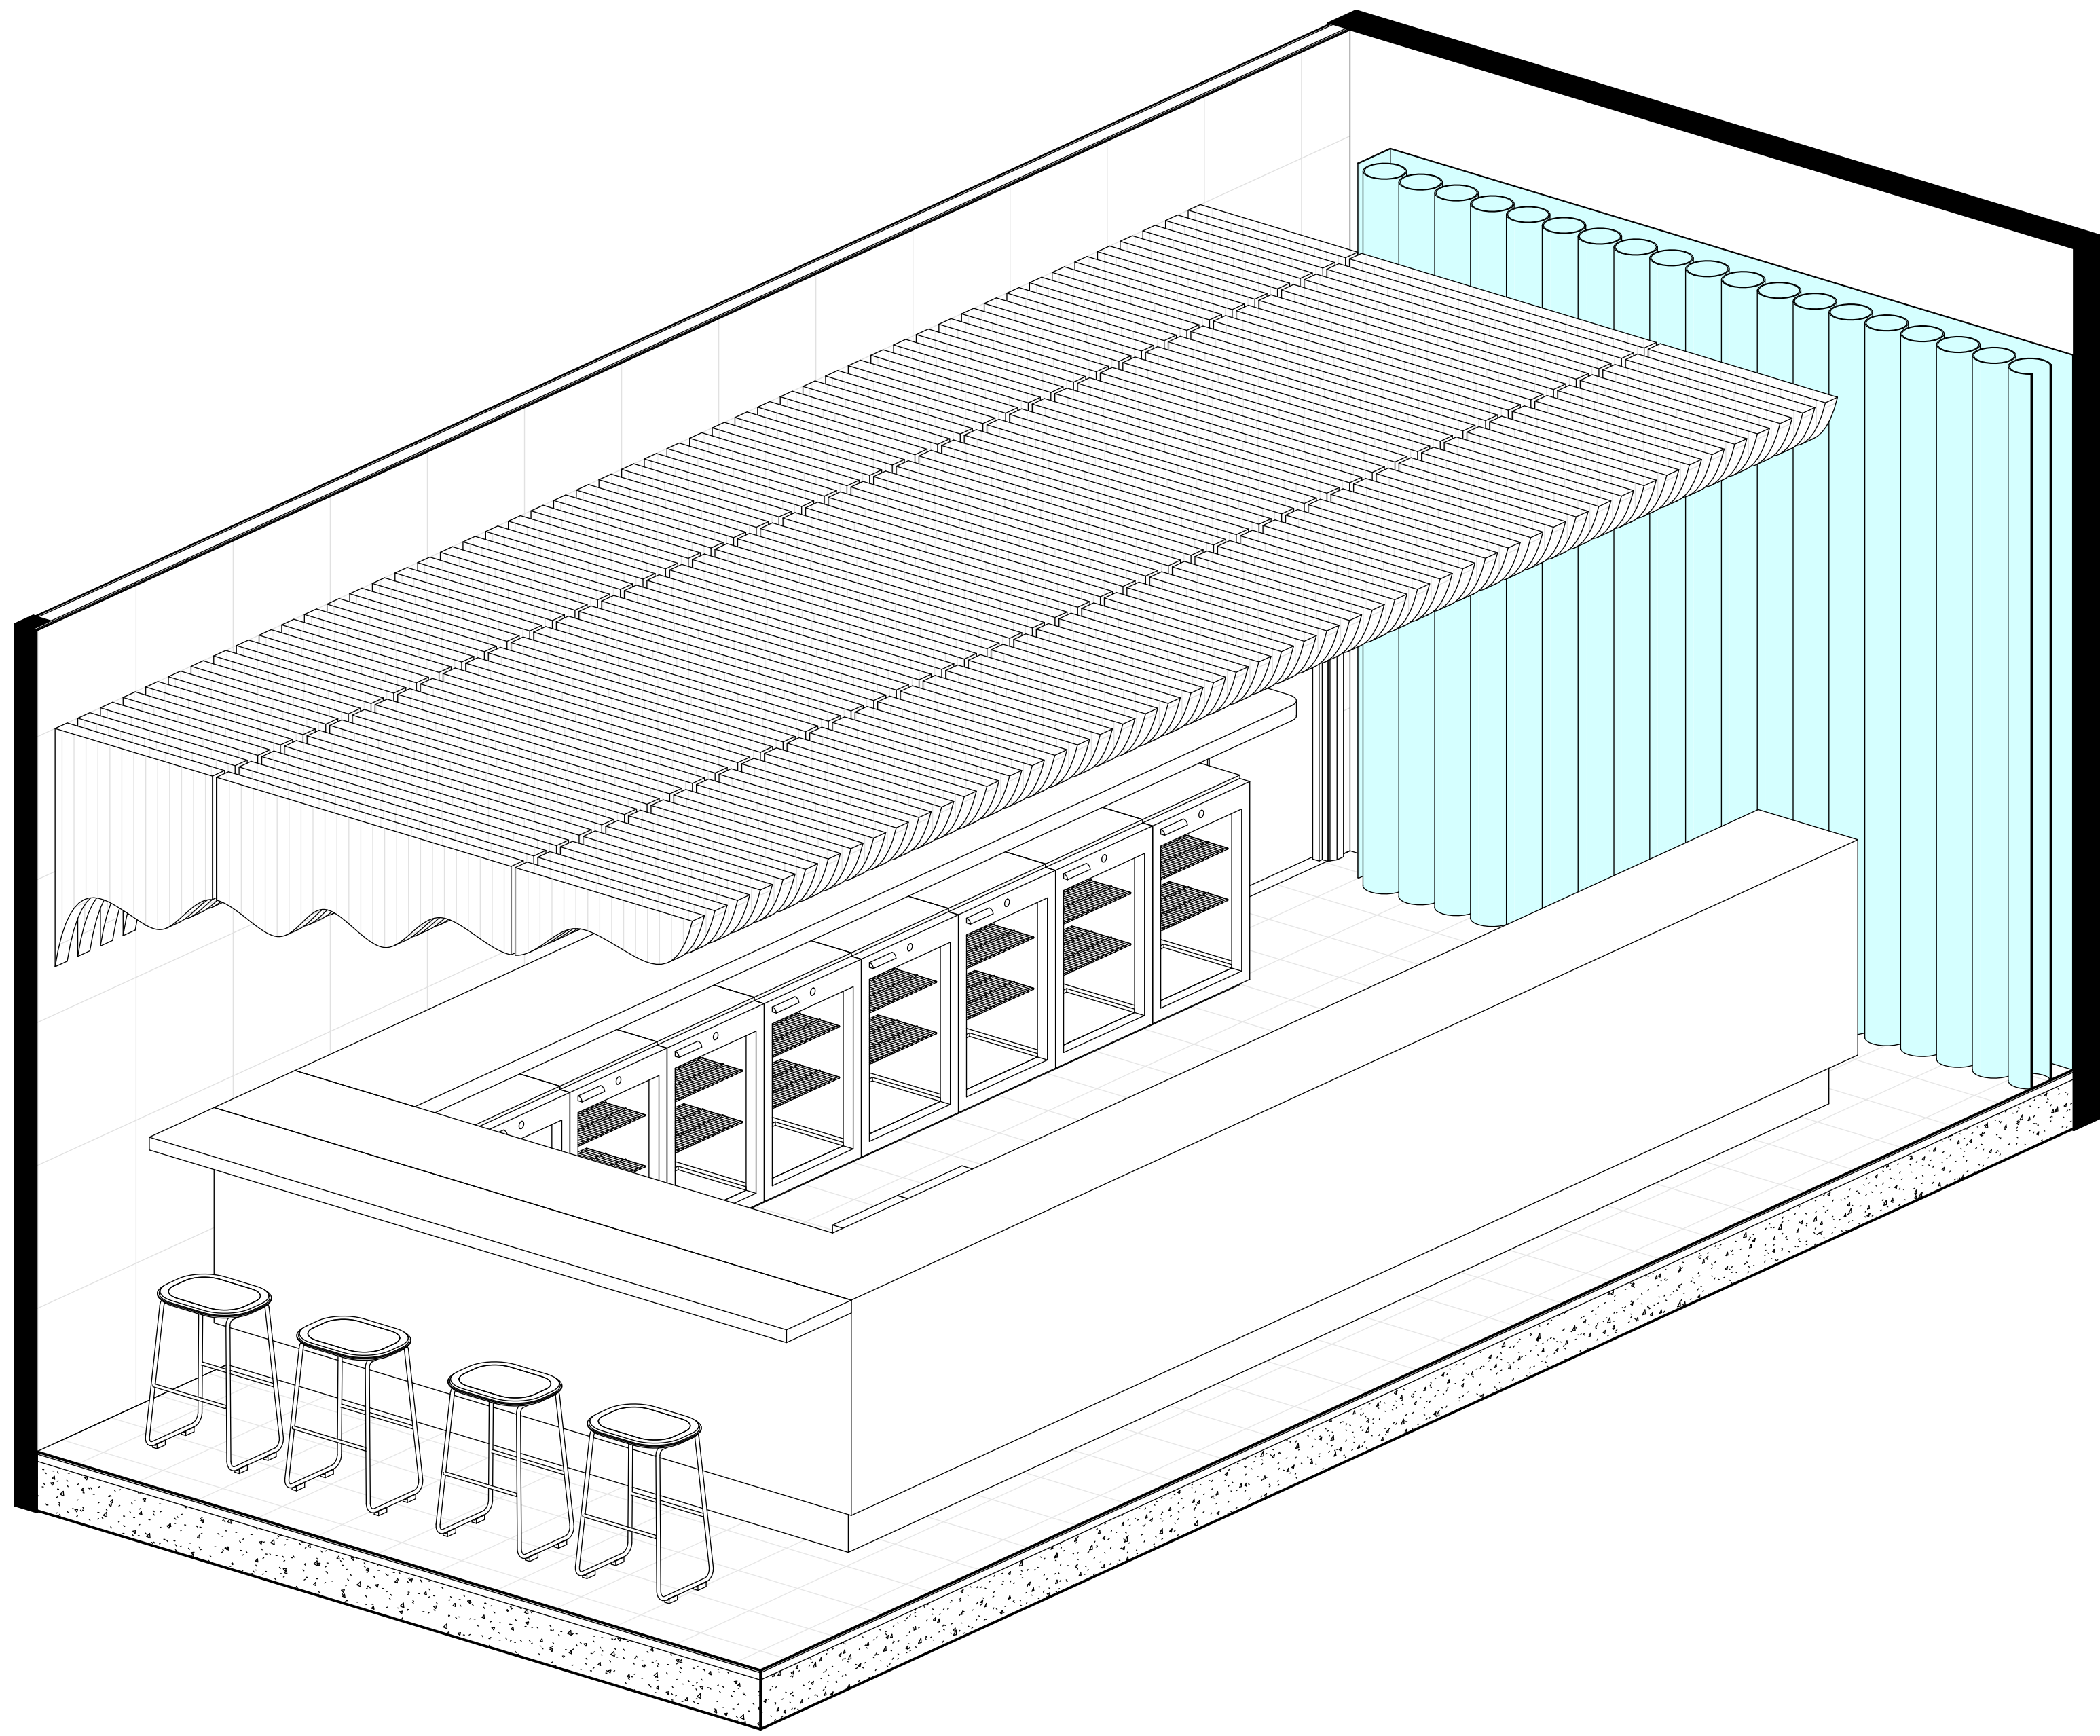


3 Bar Isometric

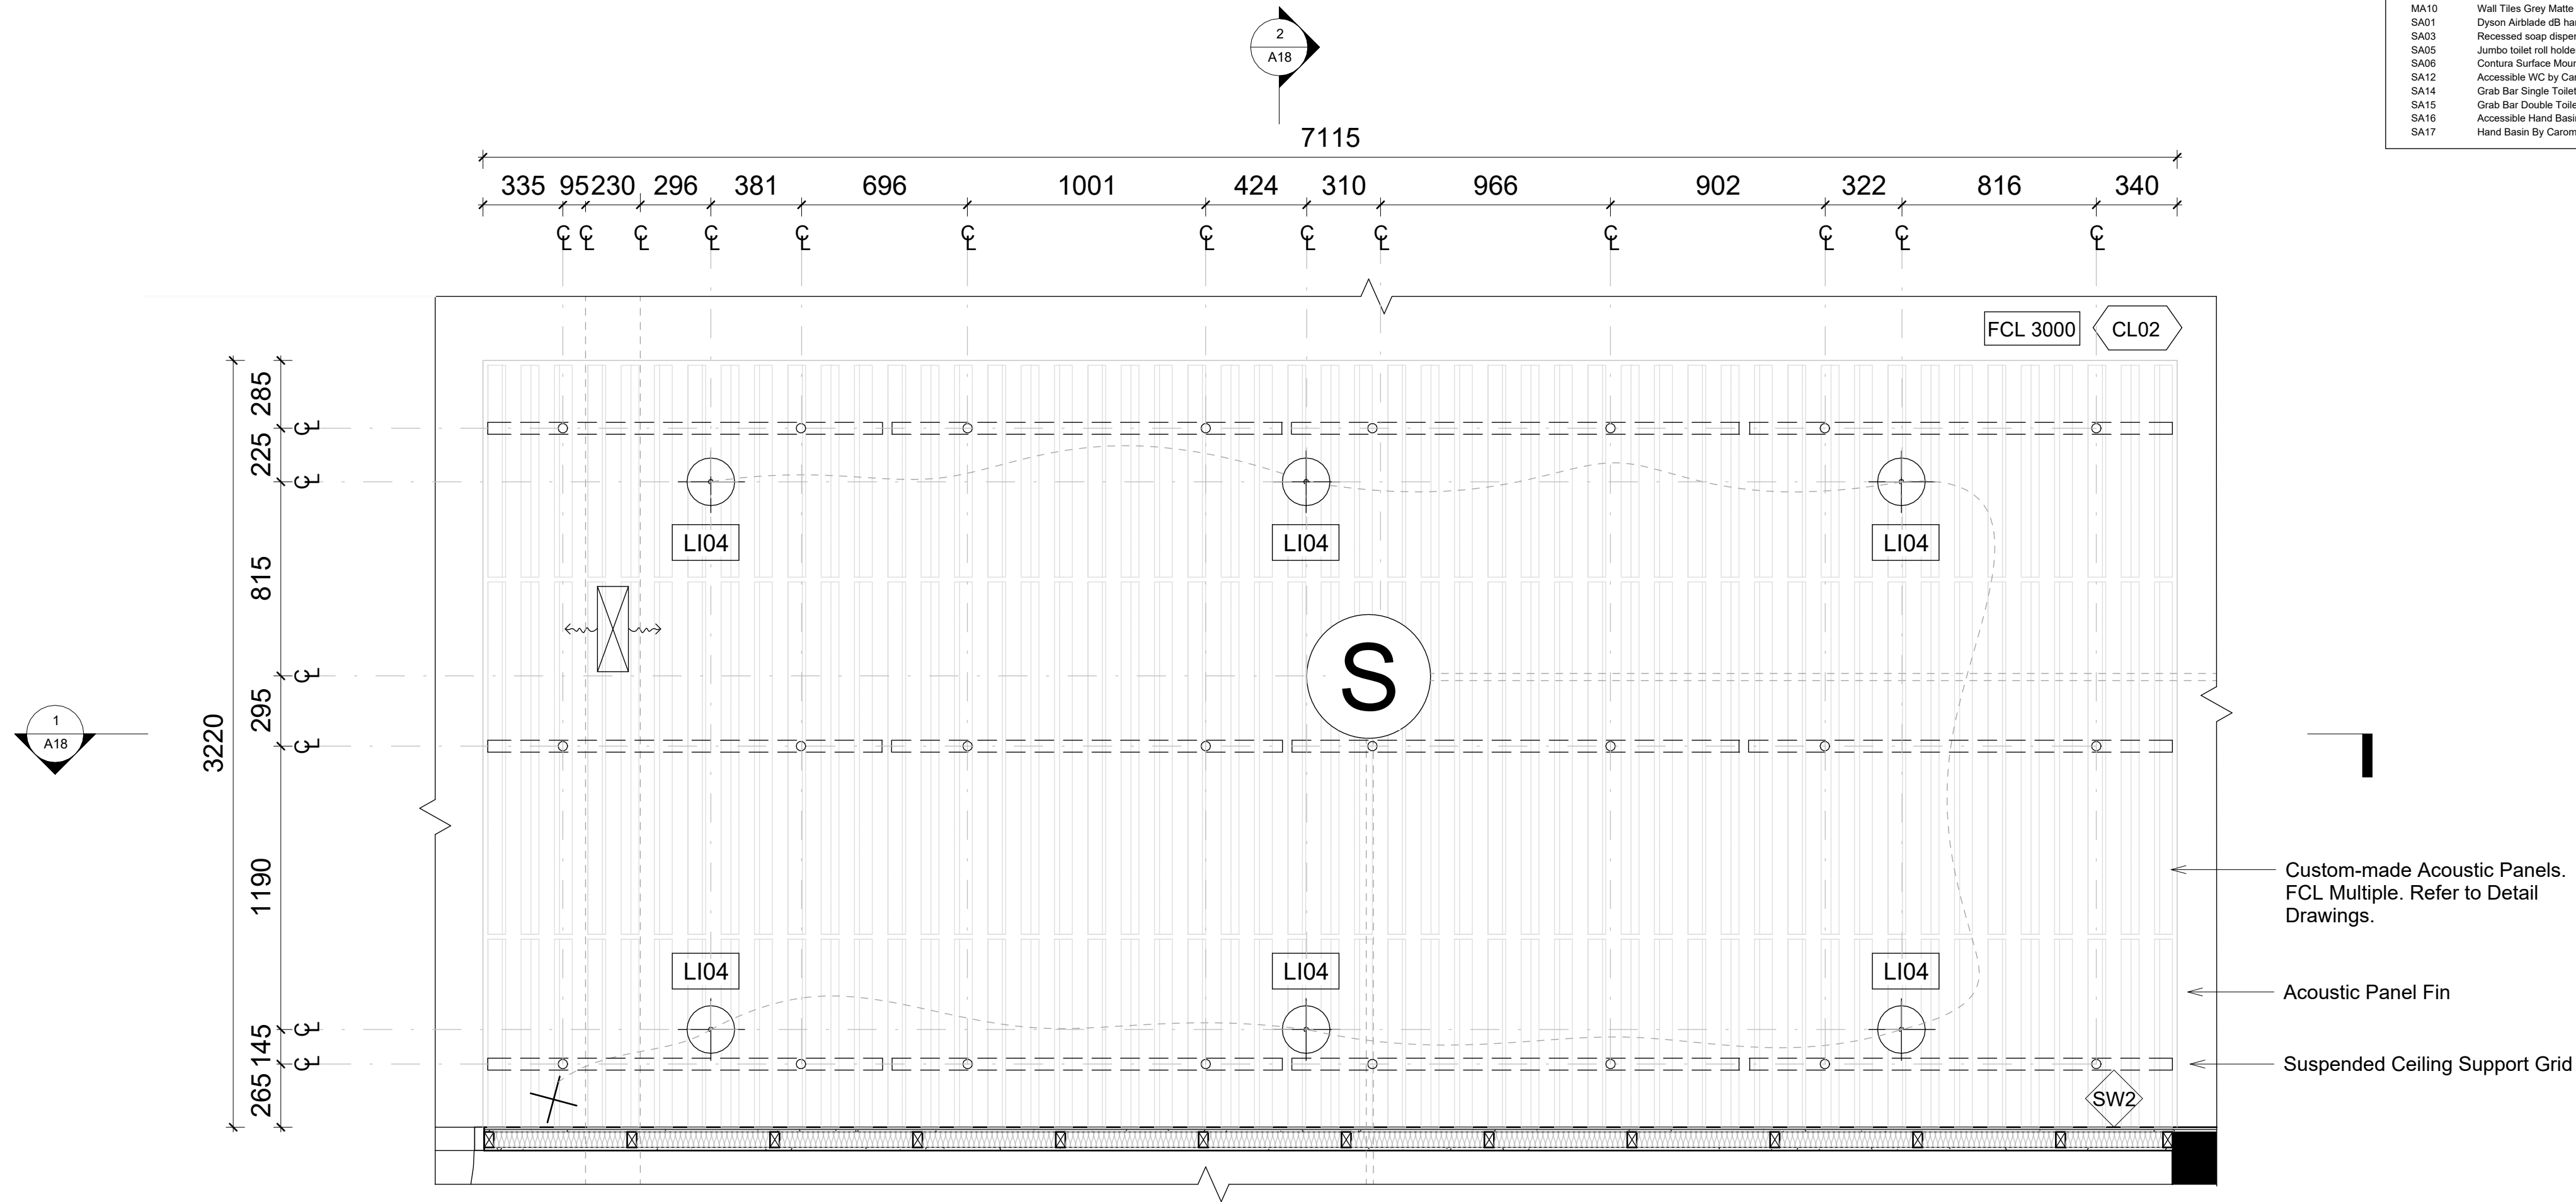

2 RCP Cocktail Bar Detail
1 : 20

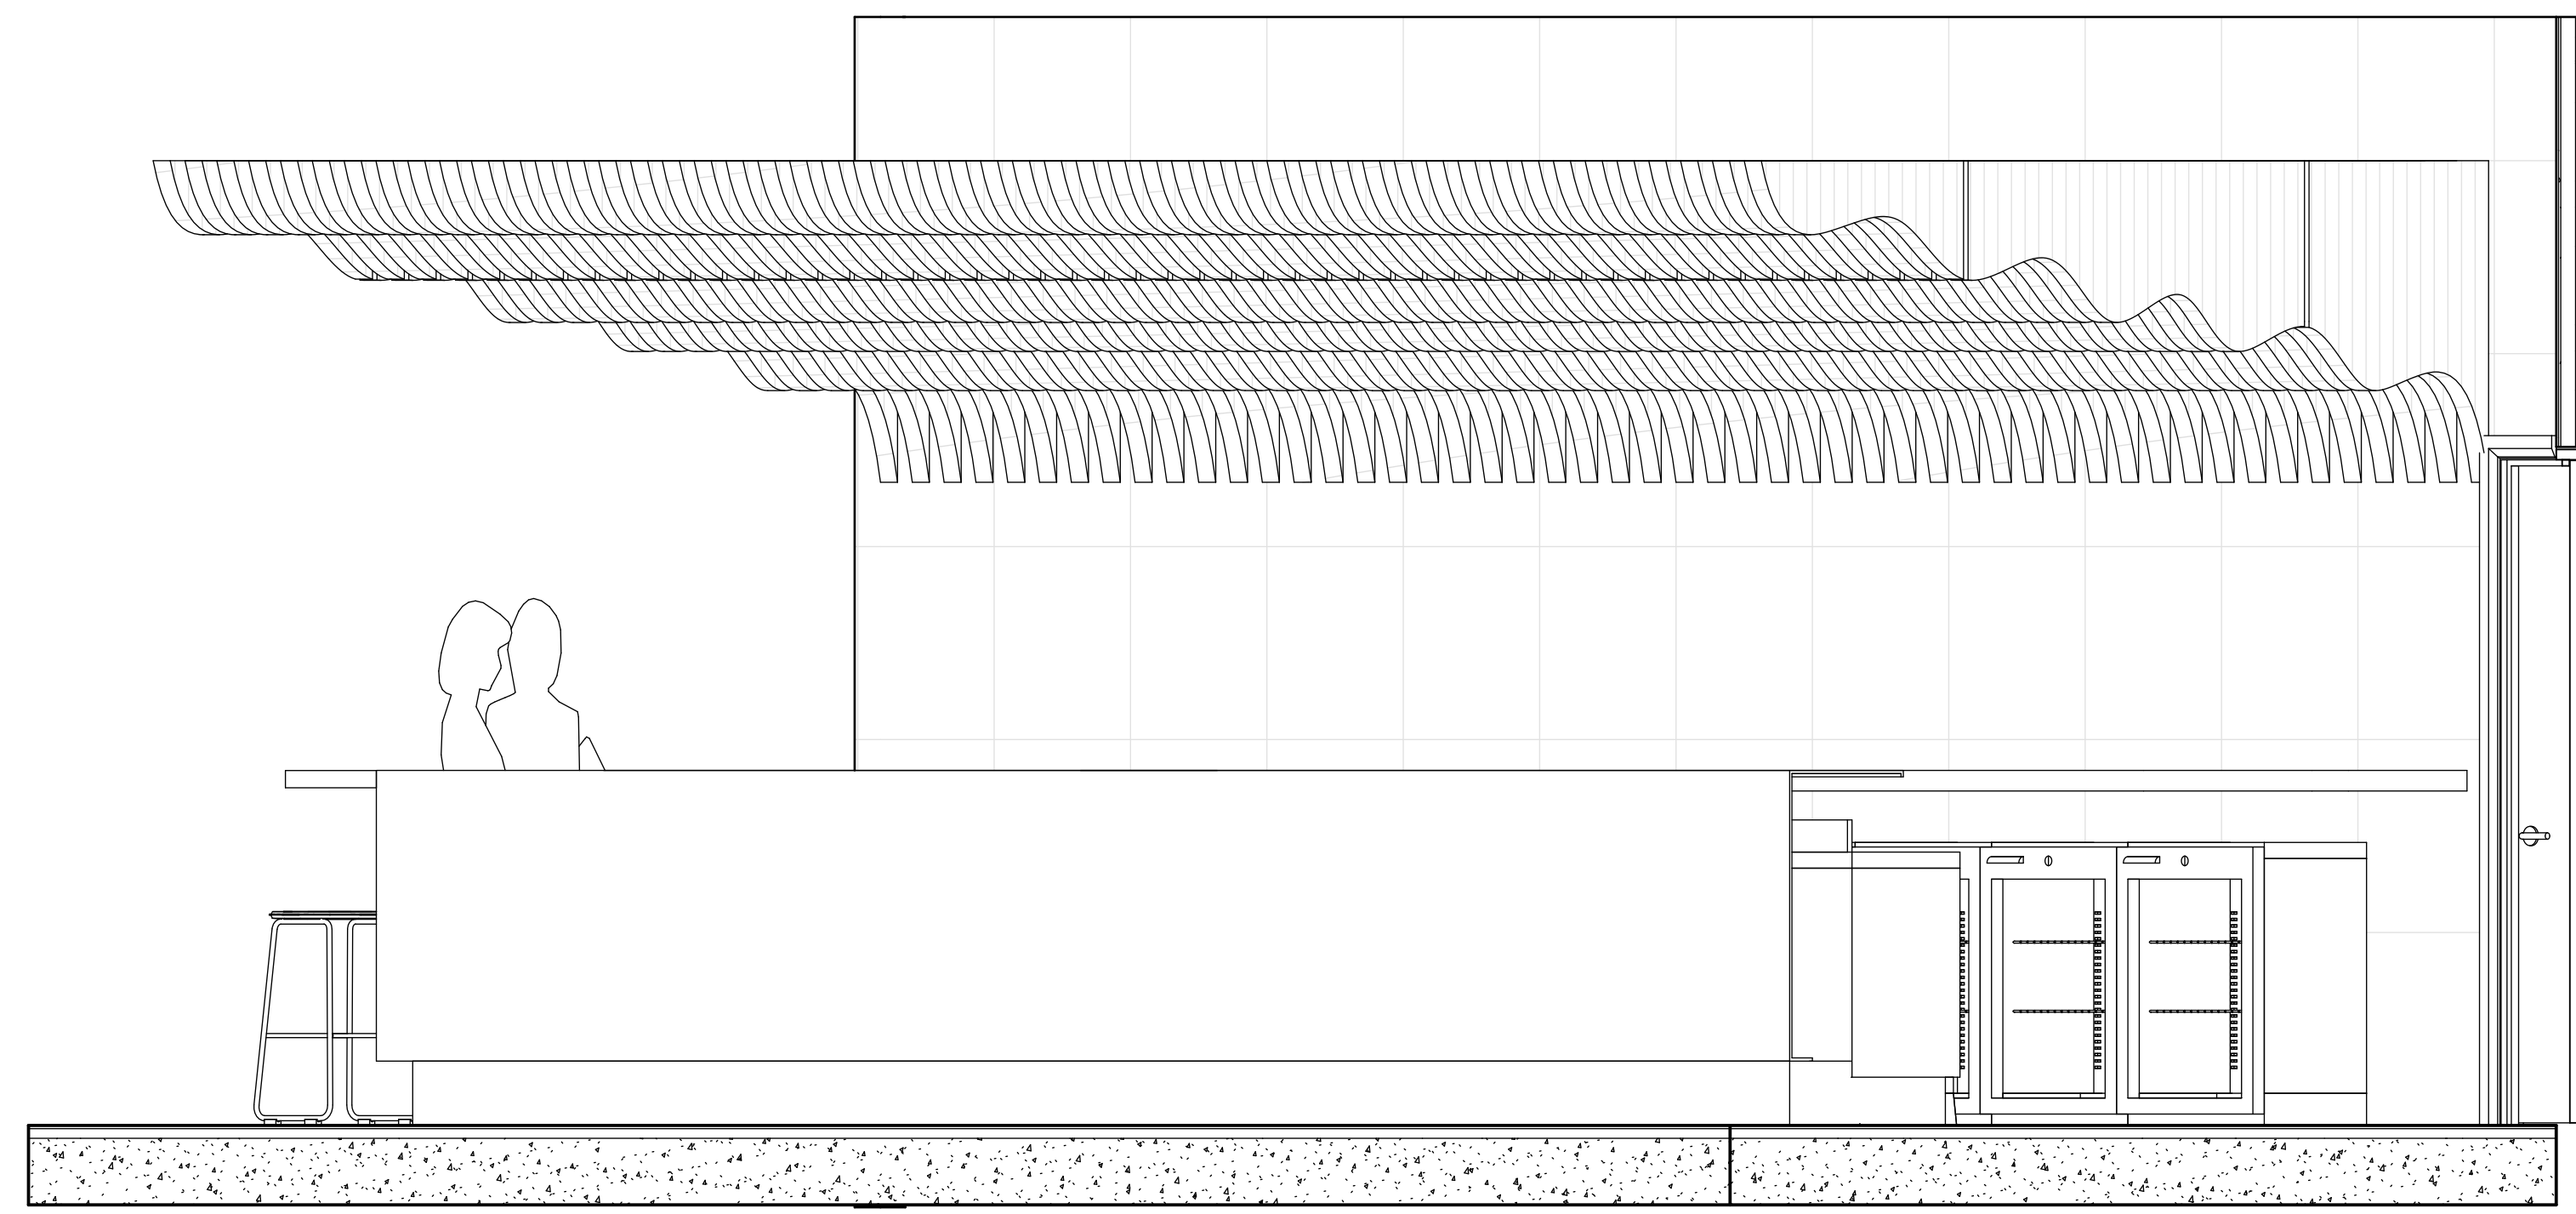

4 Bar 3D View

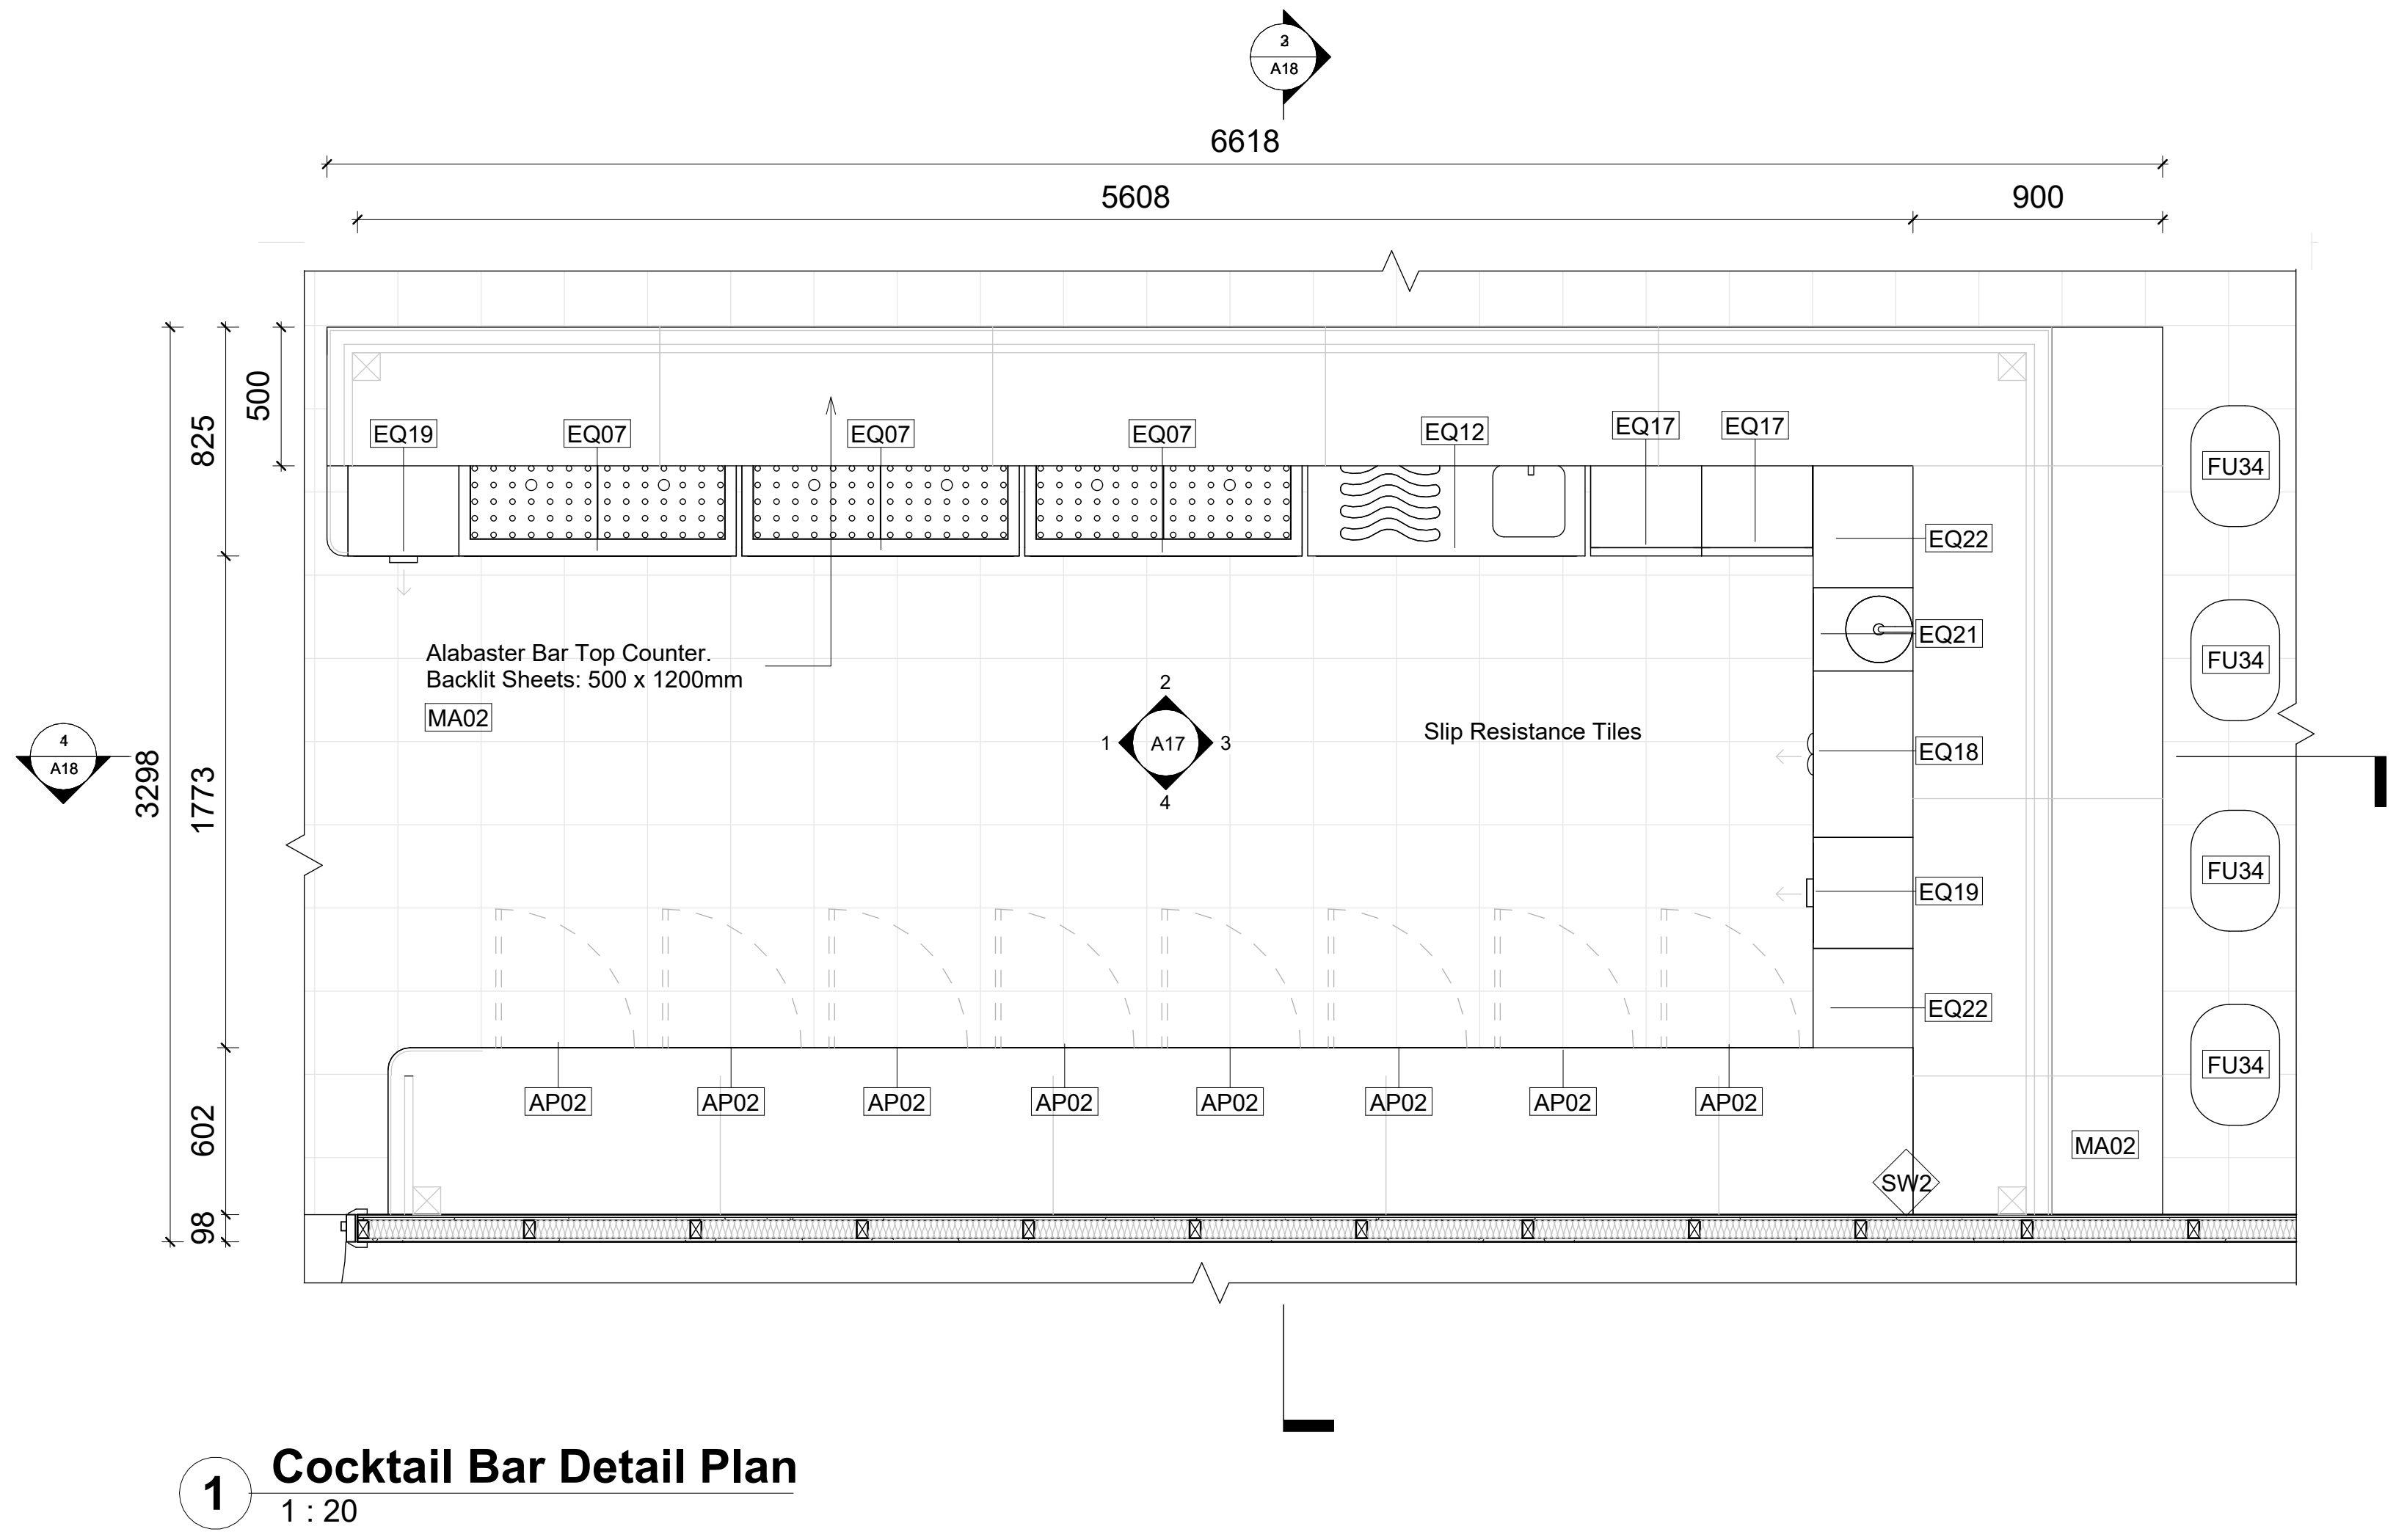

1 Cocktail Bar Detail Plan
1 : 20

Keynote Legend

Key Value	Keynote Text
AP02	Bar Top 900mm BT0900-L5 by WALCORP
AP11	Exterior Plywood 12mm 1200x2400mm by Hilti
AP12	800 Series 8 Burners Double Sided Oven FAN800G by Walsort
EQ07	Performance Plywood 12mm 1200x2400mm by Hilti
EQ12	Single Sink 820x1700 by MFC
EQ17	Wash Sink 820x500 by MFC
EQ18	Storage Cabinet 820x1000 by MFC
EQ19	Single Sink 820x1700 by MFC
EQ21	Hot Water Unit 820x1700 by MFC
EQ22	Corner Tap 820x1700 by MFC
EQ24	60 Series Bench Sink 820x1700 by MFC
EQ43	Dispenser hot bench with hot and splash back RIT120L by Ryn
EQ44	Aluminium Louver 800x500 by Exponent
EQ45	Fan Extractor by MFC
FU30	Chairs 1.5m 800x400 by Exponent
FU31	Stools 1.5m 800x400 by Exponent
FU32	Chair 1.5m 800x400 by Exponent
FU33	Round Table 800x800 by Exponent
FU34	Round Table 800x800 by Exponent
FU35	High Dining Table 800x800 by Exponent
FU36	Bar Top 900mm BT0900-L5 by WALCORP
FU37	Bar Top 900mm BT0900-L5 by WALCORP
FU38	Bar Top 900mm BT0900-L5 by WALCORP
FU100	Bar Top 900mm BT0900-L5 by WALCORP

LEGEND

Hatch Types

Existing	MDF
Concrete	Earth
Tile	Timber
Plaster Board	Metal

Wall Types

STW1	13mm Plaster Board, 90mm Timber Stud Frame, 13mm Plaster Board
STW2	13mm Plaster Board, 90mm Timber Stud Frame, 13mm FC, 2mm Glue, 10mm Tile
STW3	10mm Tile, 2mm Glue, 13mm FC, 90mm Timber Stud Frame, 13mm FC, 2mm Glue, 10mm Tile

Door Types

D01	Flush Interior Door 910 x 2110mm
D02	Flush Interior Door 810 x 2110mm
D03	Flush Interior Door 1010 x 2110mm
D04	Double Flush Exterior Door 1510 x 2110mm
D05	Double Flush Interior Door 1510 x 2110mm
D06	Curtain Glass Wall Flush Doors (Refer to FF&E for specification)


Abbreviations

FFL	Finished Floor Level
FCL	Finished Ceiling Level
COS	Confirm On Site
MA	Material
FU	Furniture
EQ	Specialty Equipment
AP	Appliances
LI	Lighting Fixture
SA	Plumbing Fixture


RCP LEGEND

SA	Pendant
S	Downlight
SA	Wall Mounted Light
S	Switch
SA	Two Way Switch
S	Grid Line
SA	Wiring
S	Centreline
SA	Ventilation
S	Smoke Alarm
SA	Sprinkler
S	Emergency Light
SA	Exhaust Fan
S	Airconditioning Grill in Dropped Ceiling
SA	600x600mm Access Panel
S	Range Hood
SA	Exit Sign
S	13mm Plasterboard with Rondo Suspended Hooks
SA	Concealed Grid System with Rondo Suspended Hooks (Tiles fit edge-to-edge)
S	Decorative Grid System - Modular Baffles with Rondo Suspended Hooks


Revisions	Client	Designed by:	NOTES	True North	Project	Drawing Title	Scale	Drawing No	Issue
No Date 01 29/10/23 02 19/11/23 03 10/12/23	Description TENDER DRAWINGS NOT FOR CONSTRUCTION TENDER DRAWINGS NOT FOR CONSTRUCTION TENDER DRAWINGS NOT FOR CONSTRUCTION	Ver. App'd XX App'd XX App'd XX App'd	Do not scale drawings. Use figured dimensions only. Check and verify levels and dimensions on site prior to commencement of any work, the preparation of drawings or the fabrication of components. This drawing is copyright and can not be reproduced without written consent.	Client Ak	Designed by: PS	NOTES	True North	Project Akira Back Restaurant	Drawing Title Cocktail Bar Plan/RCP & Isometrics
					Billy Blue College of Design 46-52 Mountain Street, Ultimo, NSW 2007, Australia +61 (0)2 9999 9999	Project Address: Level 2 Northern end of the Overseas Passenger Terminal, Circular Quay W, The Rocks NSW 2000	Scale 1:20	Drawing No A16	Issue 01
						Project number 2023. 002	Date 10/12/23	Drawn by PS	Drawing Status TENDER ISSUE DRAWINGS NOT FOR CONSTRUCTION

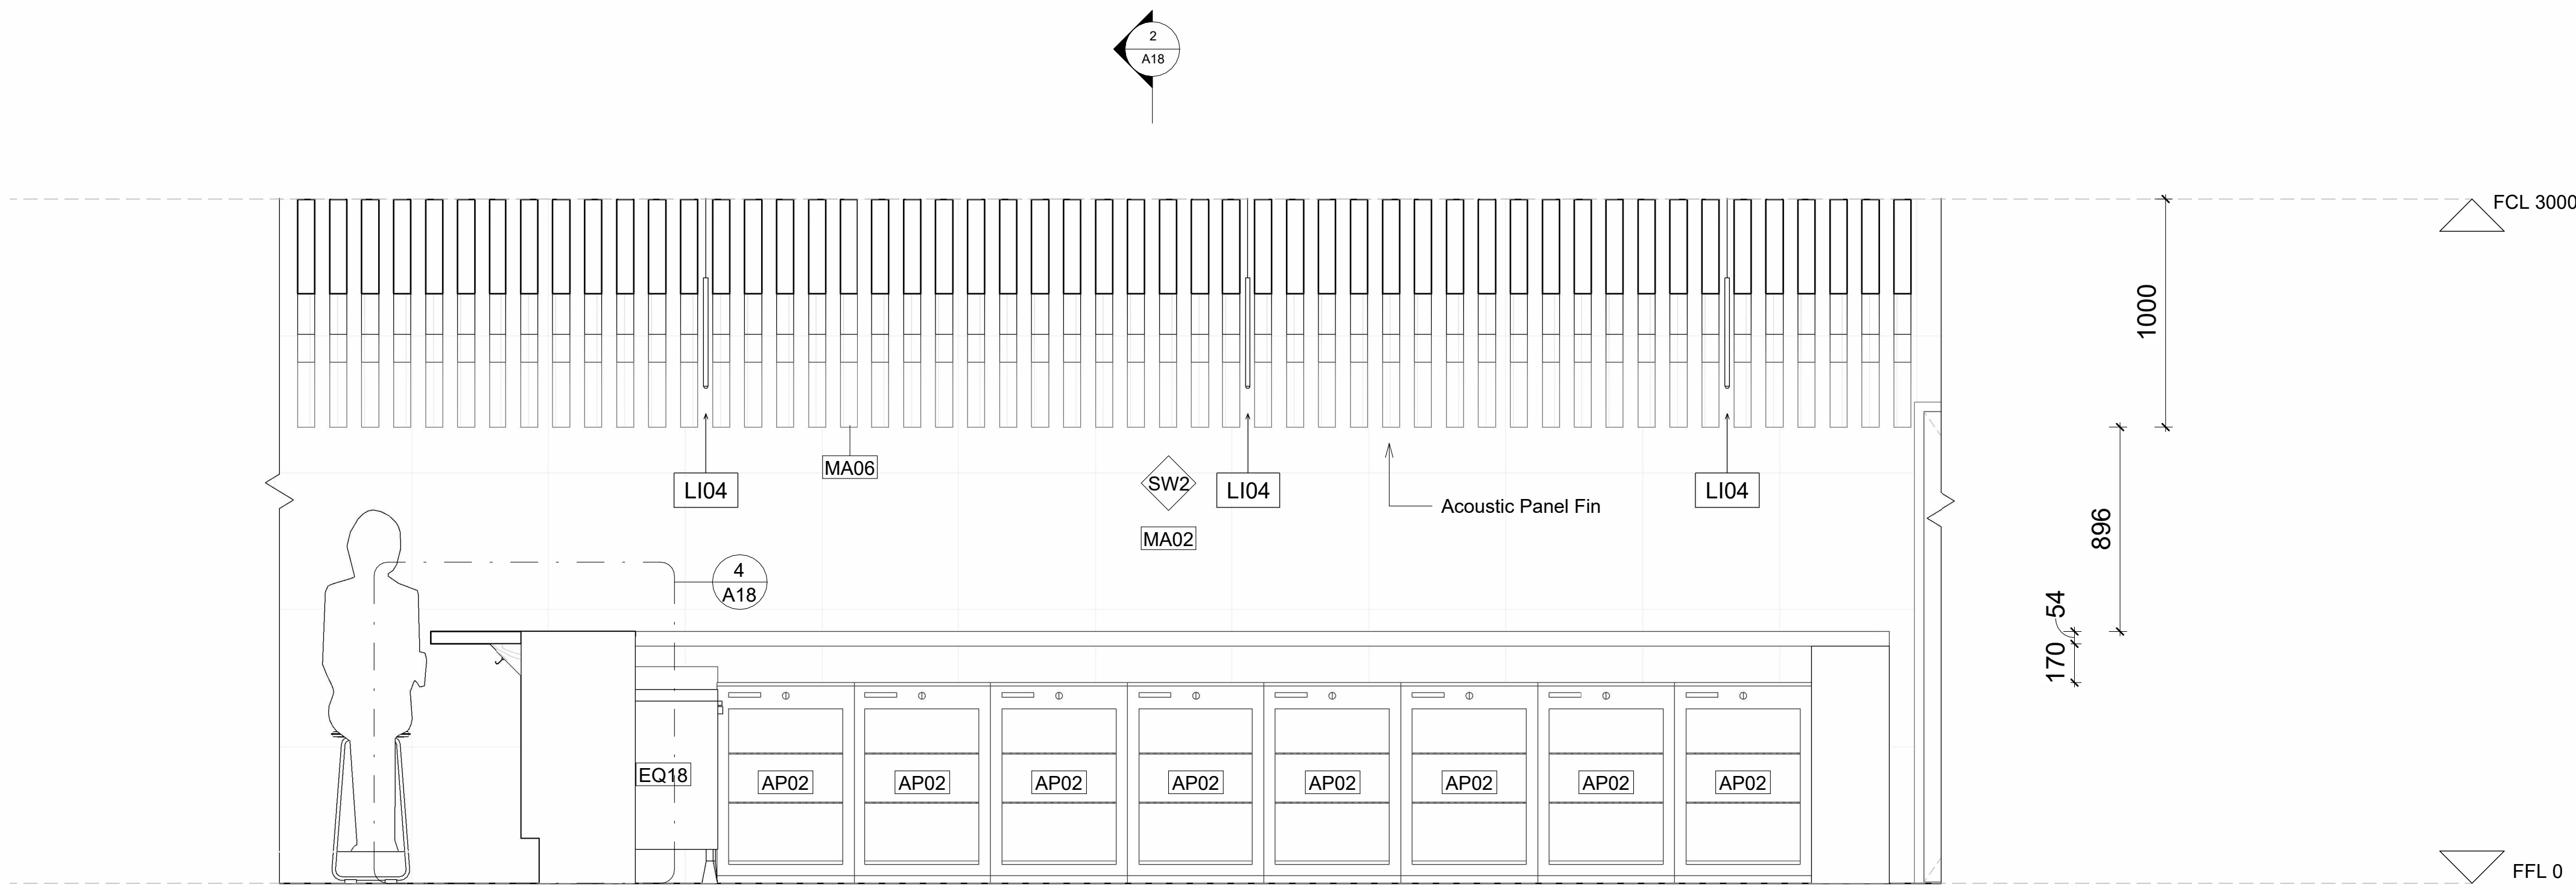


4 Bar Elevation 4
1 : 20

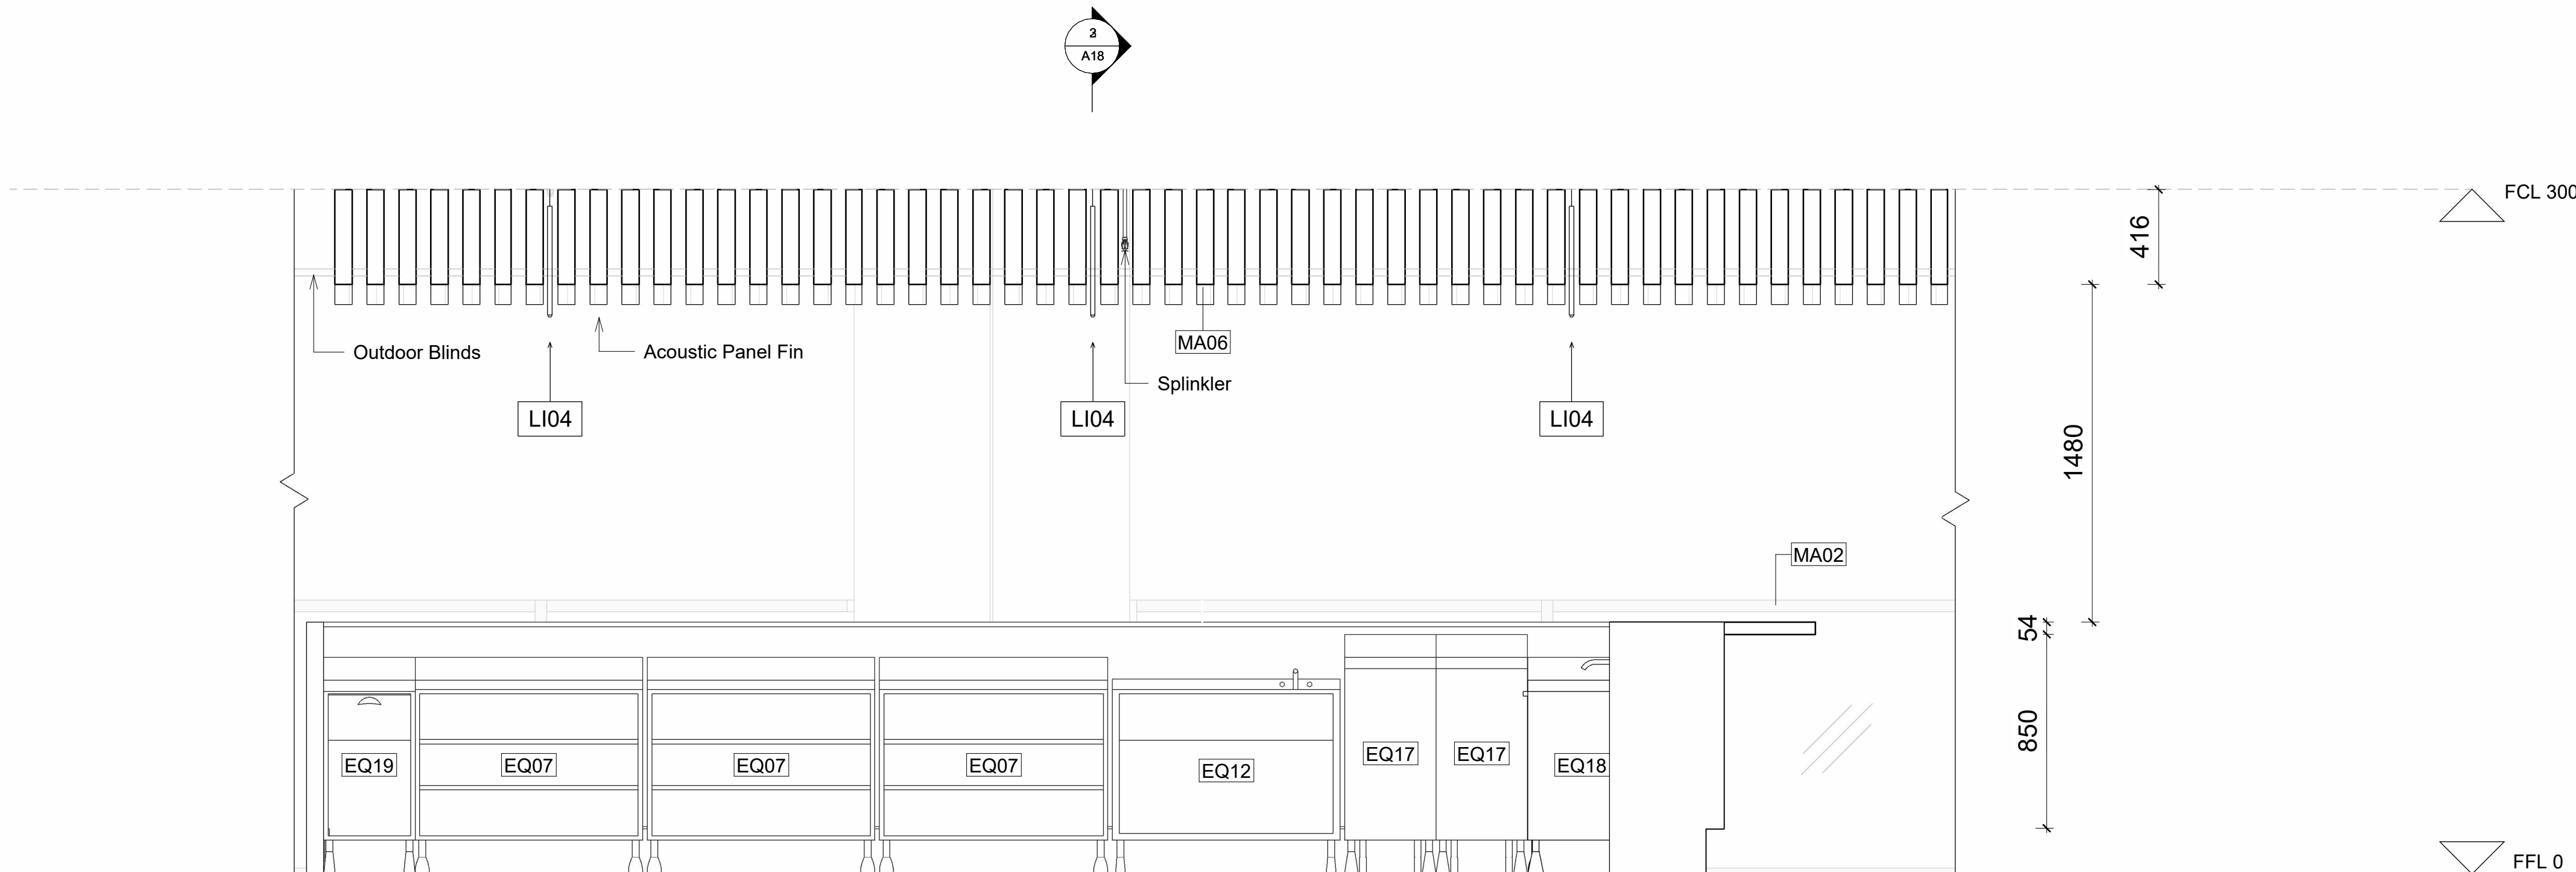


2 Bar Elevation 2
1 : 20

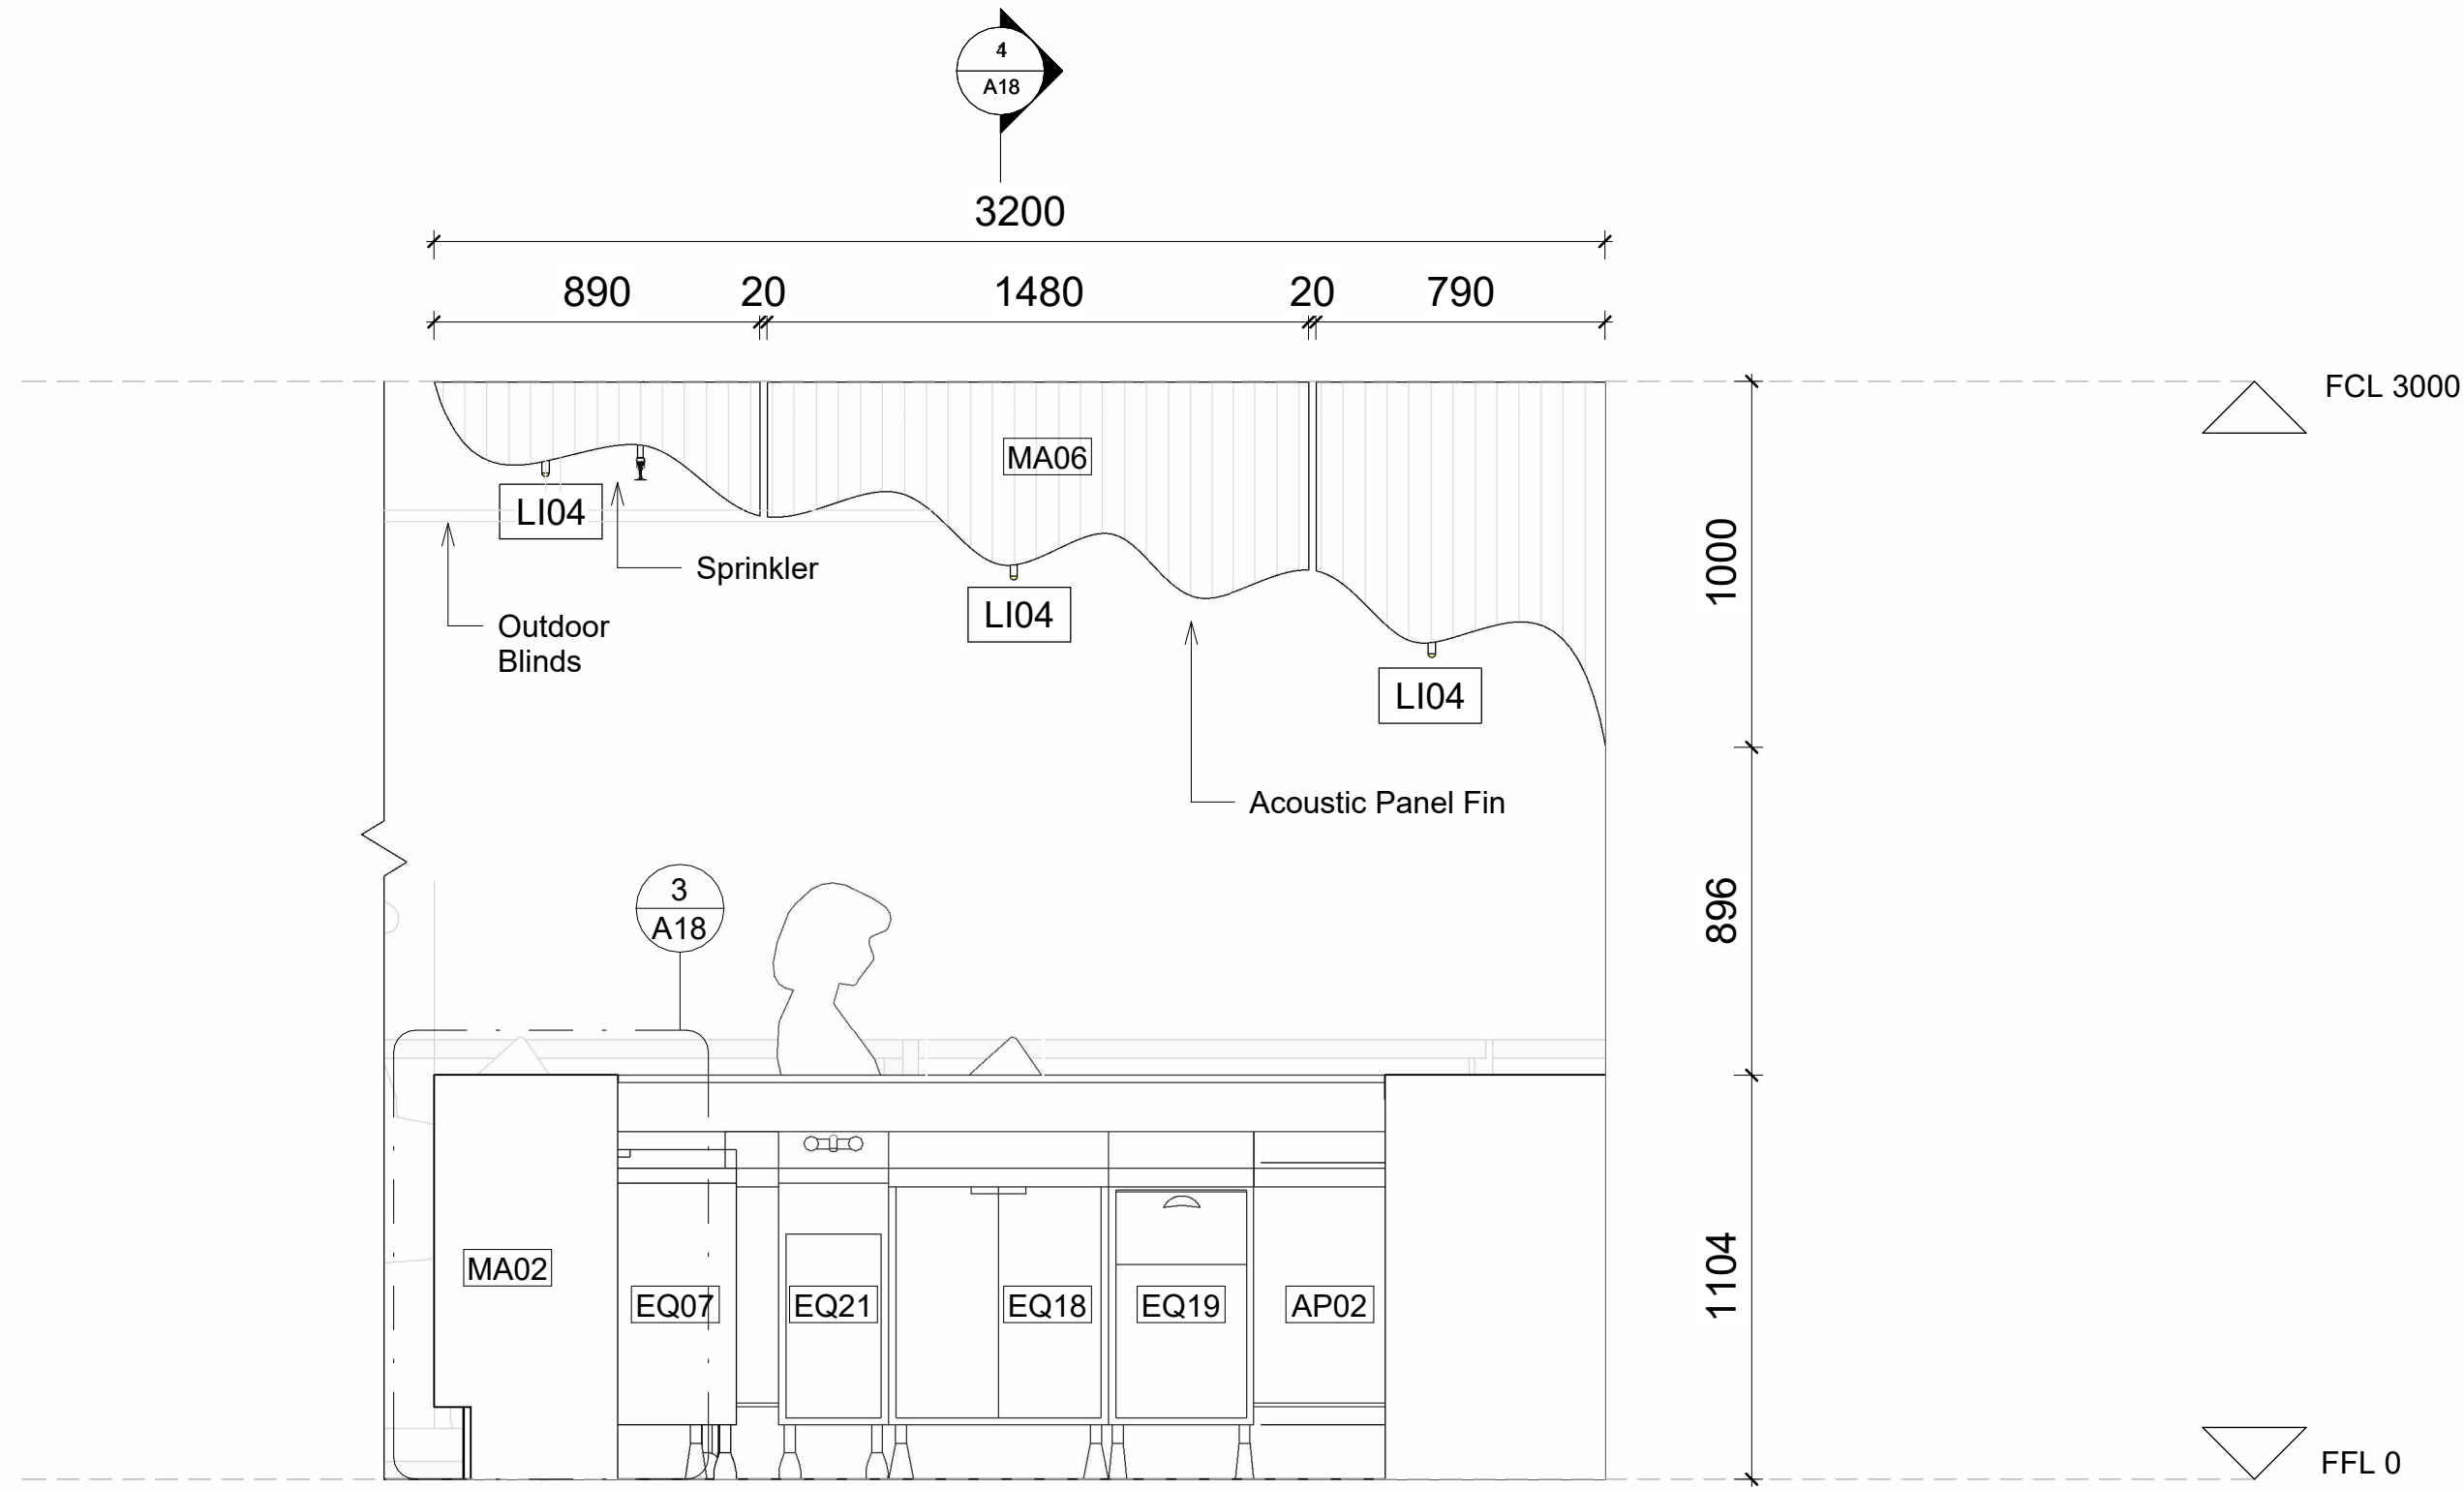





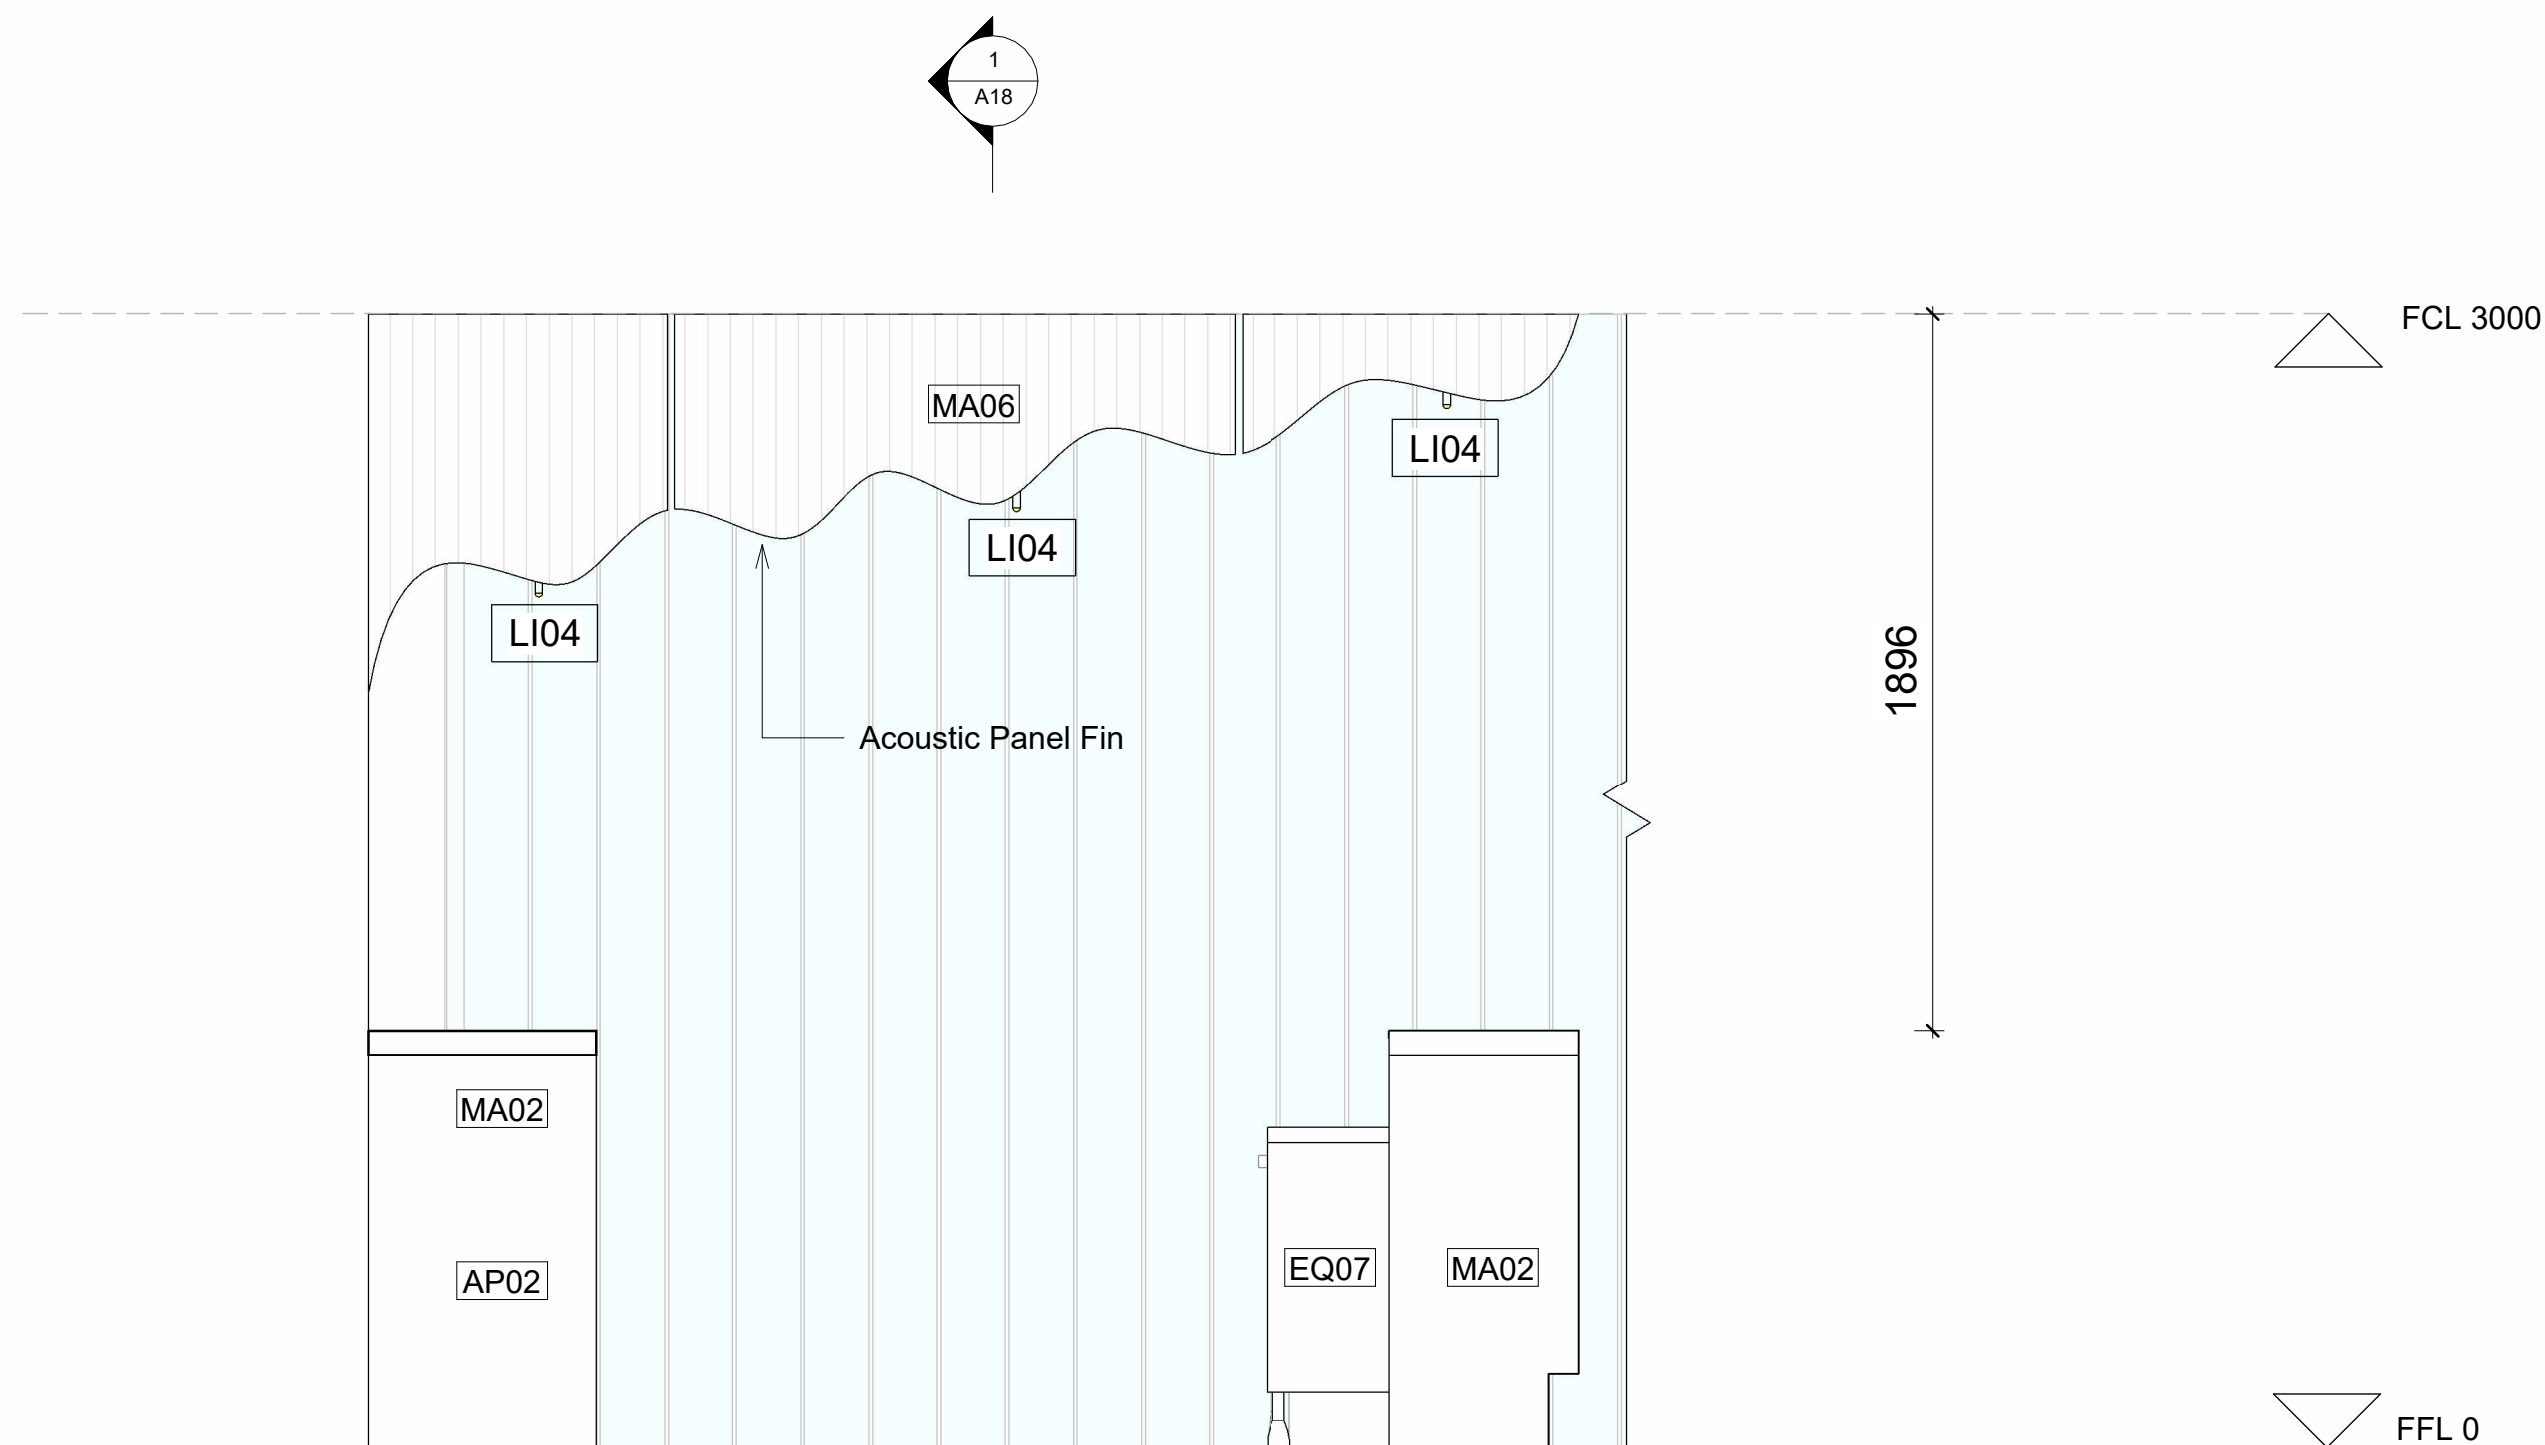

   


 
 

 




3 Bar Elevation 3
1 : 20




1 Bar Elevation 1
1 : 20




LEGEND			
Hatch Types			
	Existing		MDF
	Concrete		Earth
	Tile		Timber
	Plaster Board		Metal
Wall Types			
	STW1	13mm Plaster Board, 90mm Timber Stud Frame, 13mm Plaster Board	
	STW2	13mm Plaster Board, 90mm Timber Stud Frame, 13mm FC, 2mm Glue, 10mm Tile	
	STW3	10mm Tile, 2mm Glue, 13mm FC, 90mm Timber Stud Frame, 13mm FC, 2mm Glue, 10mm Tile	
Door Types			
	D01	Flush Interior Door 910 x 2110mm	
	D02	Flush Interior Door 810 x 2110mm	
	D03	Flush Interior Door 1010 x 2110mm	
	D04	Double Flush Exterior Door 1510 x 2110mm	
	D05	Double Flush Interior Door 1510 x 2110mm	
	D06	Curtain Glass Wall Flush Doors (Refer to FF&E for specification)	
Abbreviations			
FFL	Finished Floor Level		
FCL	Finished Ceiling Level		
COS	Confirm On Site		
MA	Material		
FU	Furniture		
EQ	Specialty Equipment		
AP	Appliances		
LI	Lighting Fixture		
SA	Plumbing Fixture		

Keynote Legend	
Key Value	Keynote Text
AP02	MFC Glass Door A18 2x Material
AP10	Beach Table 900mm x 1800mm L5 by W&L/D&P
AP11	Beach Table 900mm x 1800mm L5 by W&L/D&P
AP12	800 series 8 Burners stainless steel oven FMS200 by Waskett
EQ07	Professional Worktop 820x50 by MFC
EQ12	Single Sink 820x100 by MFC
EQ17	Wash Unit 820x50 by MFC
EQ18	Storage Cabinet 820x100 by MFC
EQ19	Single Drawer Unit 820x50 by MFC
EQ21	Hand Wash Unit 820x100 by MFC
EQ22	Corner Top 820x100 by MFC
EQ24	100 series stainless steel sink by Ryn
EQ43	Disinfectant hand basin with sink and splash back 87x100 by Ryn
EQ48	Armament Lining 150x40 by Equiment
EQ54	Fan Extractor by MFC
FU03	Chest 1500mm by Equiment
FU05	Square Table 1500mm by Kart
FU07	Chest 1500mm by Equiment
FU08	Dining Armchair Upholstery by Equiment
FU09	Round Table 1000mm by Equiment
FU10	High Seat Polymer Table 1000mm by Equiment
FU11	High Chair 1000mm by Equiment
FU12	Beach Table 800mm by Equiment
FU13	Beach Table 800mm by Equiment
FU14	Beach Table 800mm by Equiment
FU100	Beach Table 800mm by Equiment


Revisions			<div>Client Ak</div> <div></div>	<div>Designed by: PS</div> <div></div>	NOTES	<div>True North</div> <div></div>	<div>Billy Blue College of Design 46-52 Mountain Street, Ultimo, NSW 2007, Australia +61 (0)2 9999 9999</div> <div> BILLY BLUE COLLEGE OF DESIGN</div> <div> LAUREATE INTERNATIONAL UNIVERSITY</div>	<div>Project Akira Back Restaurant</div> <div>Project Address: Level 2 Northern end of the Overseas Passenger Terminal, Circular Quay W, The Rocks NSW 2000</div> <div>Project number 2023. 002</div>	<div>Drawing Title Cocktail Bar Elevation 1-4</div> <div>Drawing Status TENDER ISSUE DRAWINGS NOT FOR CONSTRUCTION</div>	<div>Scale 1:20</div> <div>Date 10/12/23</div> <div>Drawn by PS</div>	<div>Drawing No A17</div> <div>Issue 01</div>
No	Date	Description									
01	29/10/23	TENDER DRAWINGS NOT FOR CONSTRUCTION									
02	19/11/23	TENDER DRAWINGS NOT FOR CONSTRUCTION									
03	10/12/23	TENDER DRAWINGS NOT FOR CONSTRUCTION									
Do not scale drawings. Use figured dimensions only. Check and verify levels and dimensions on site prior to commencement of any work, the preparation of drawings or the fabrication of components. This drawing is copyright and can not be reproduced without written consent.											

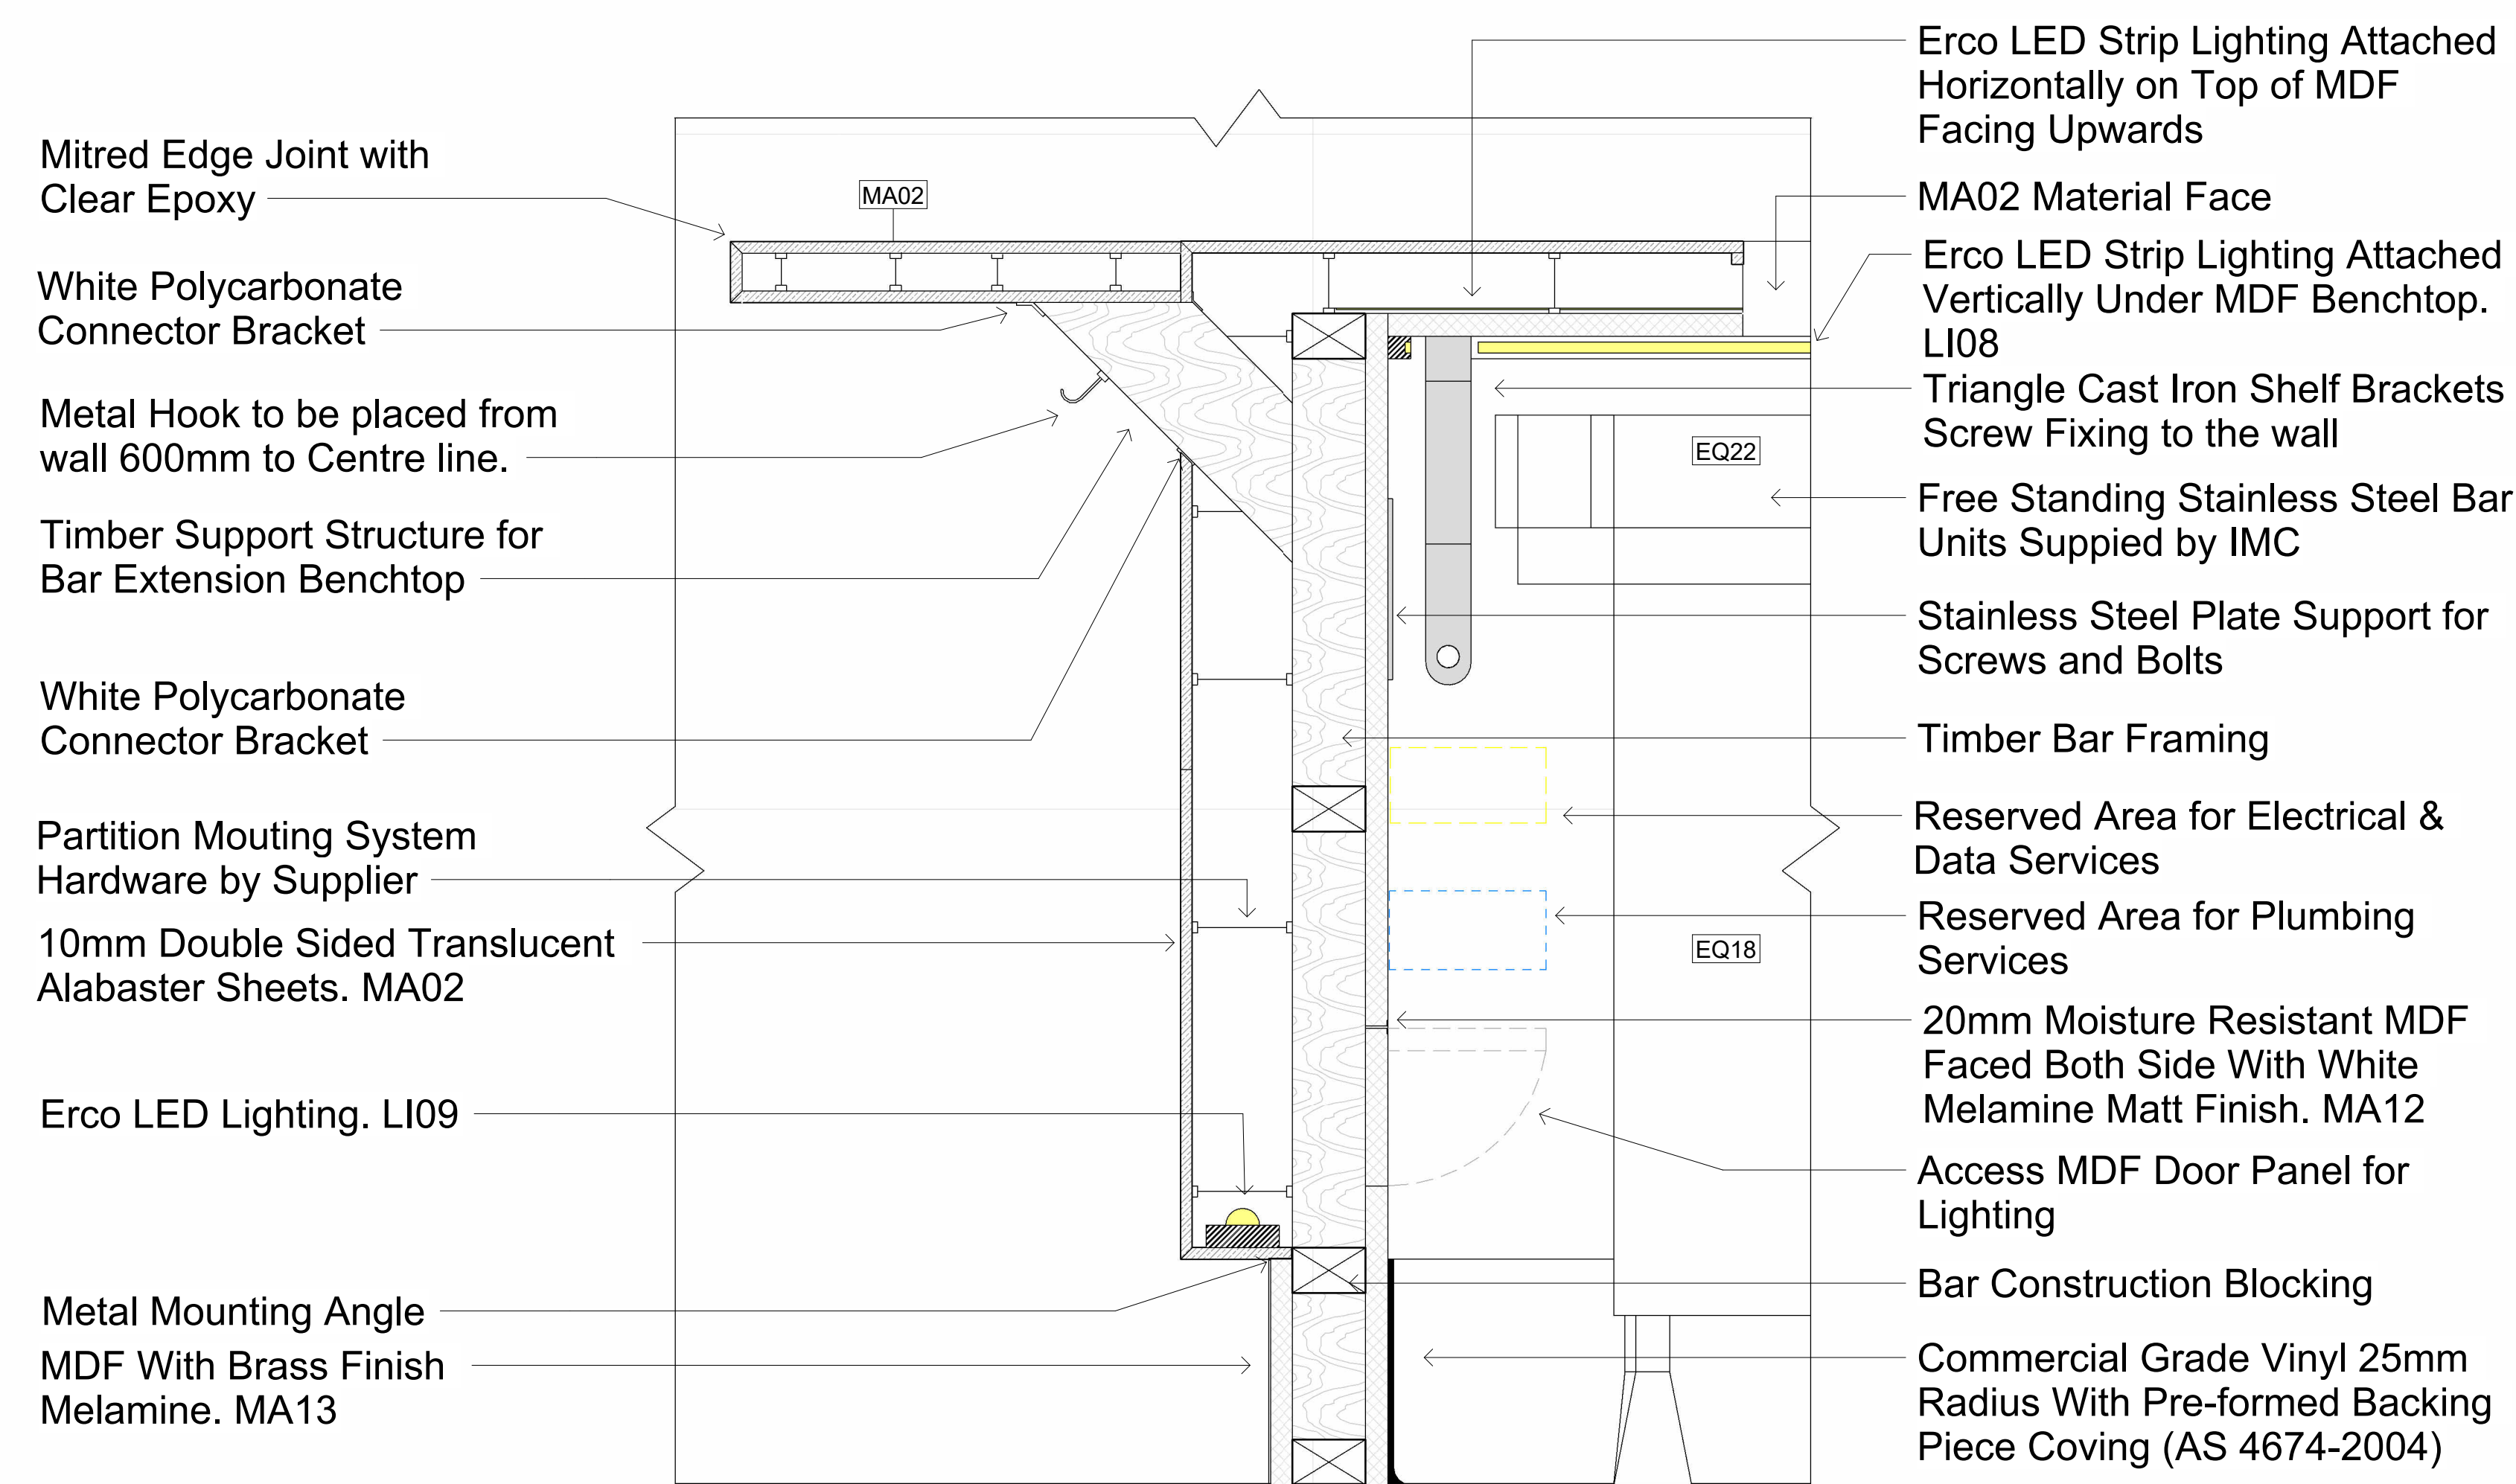


4 Cocktail Bar Detail 2

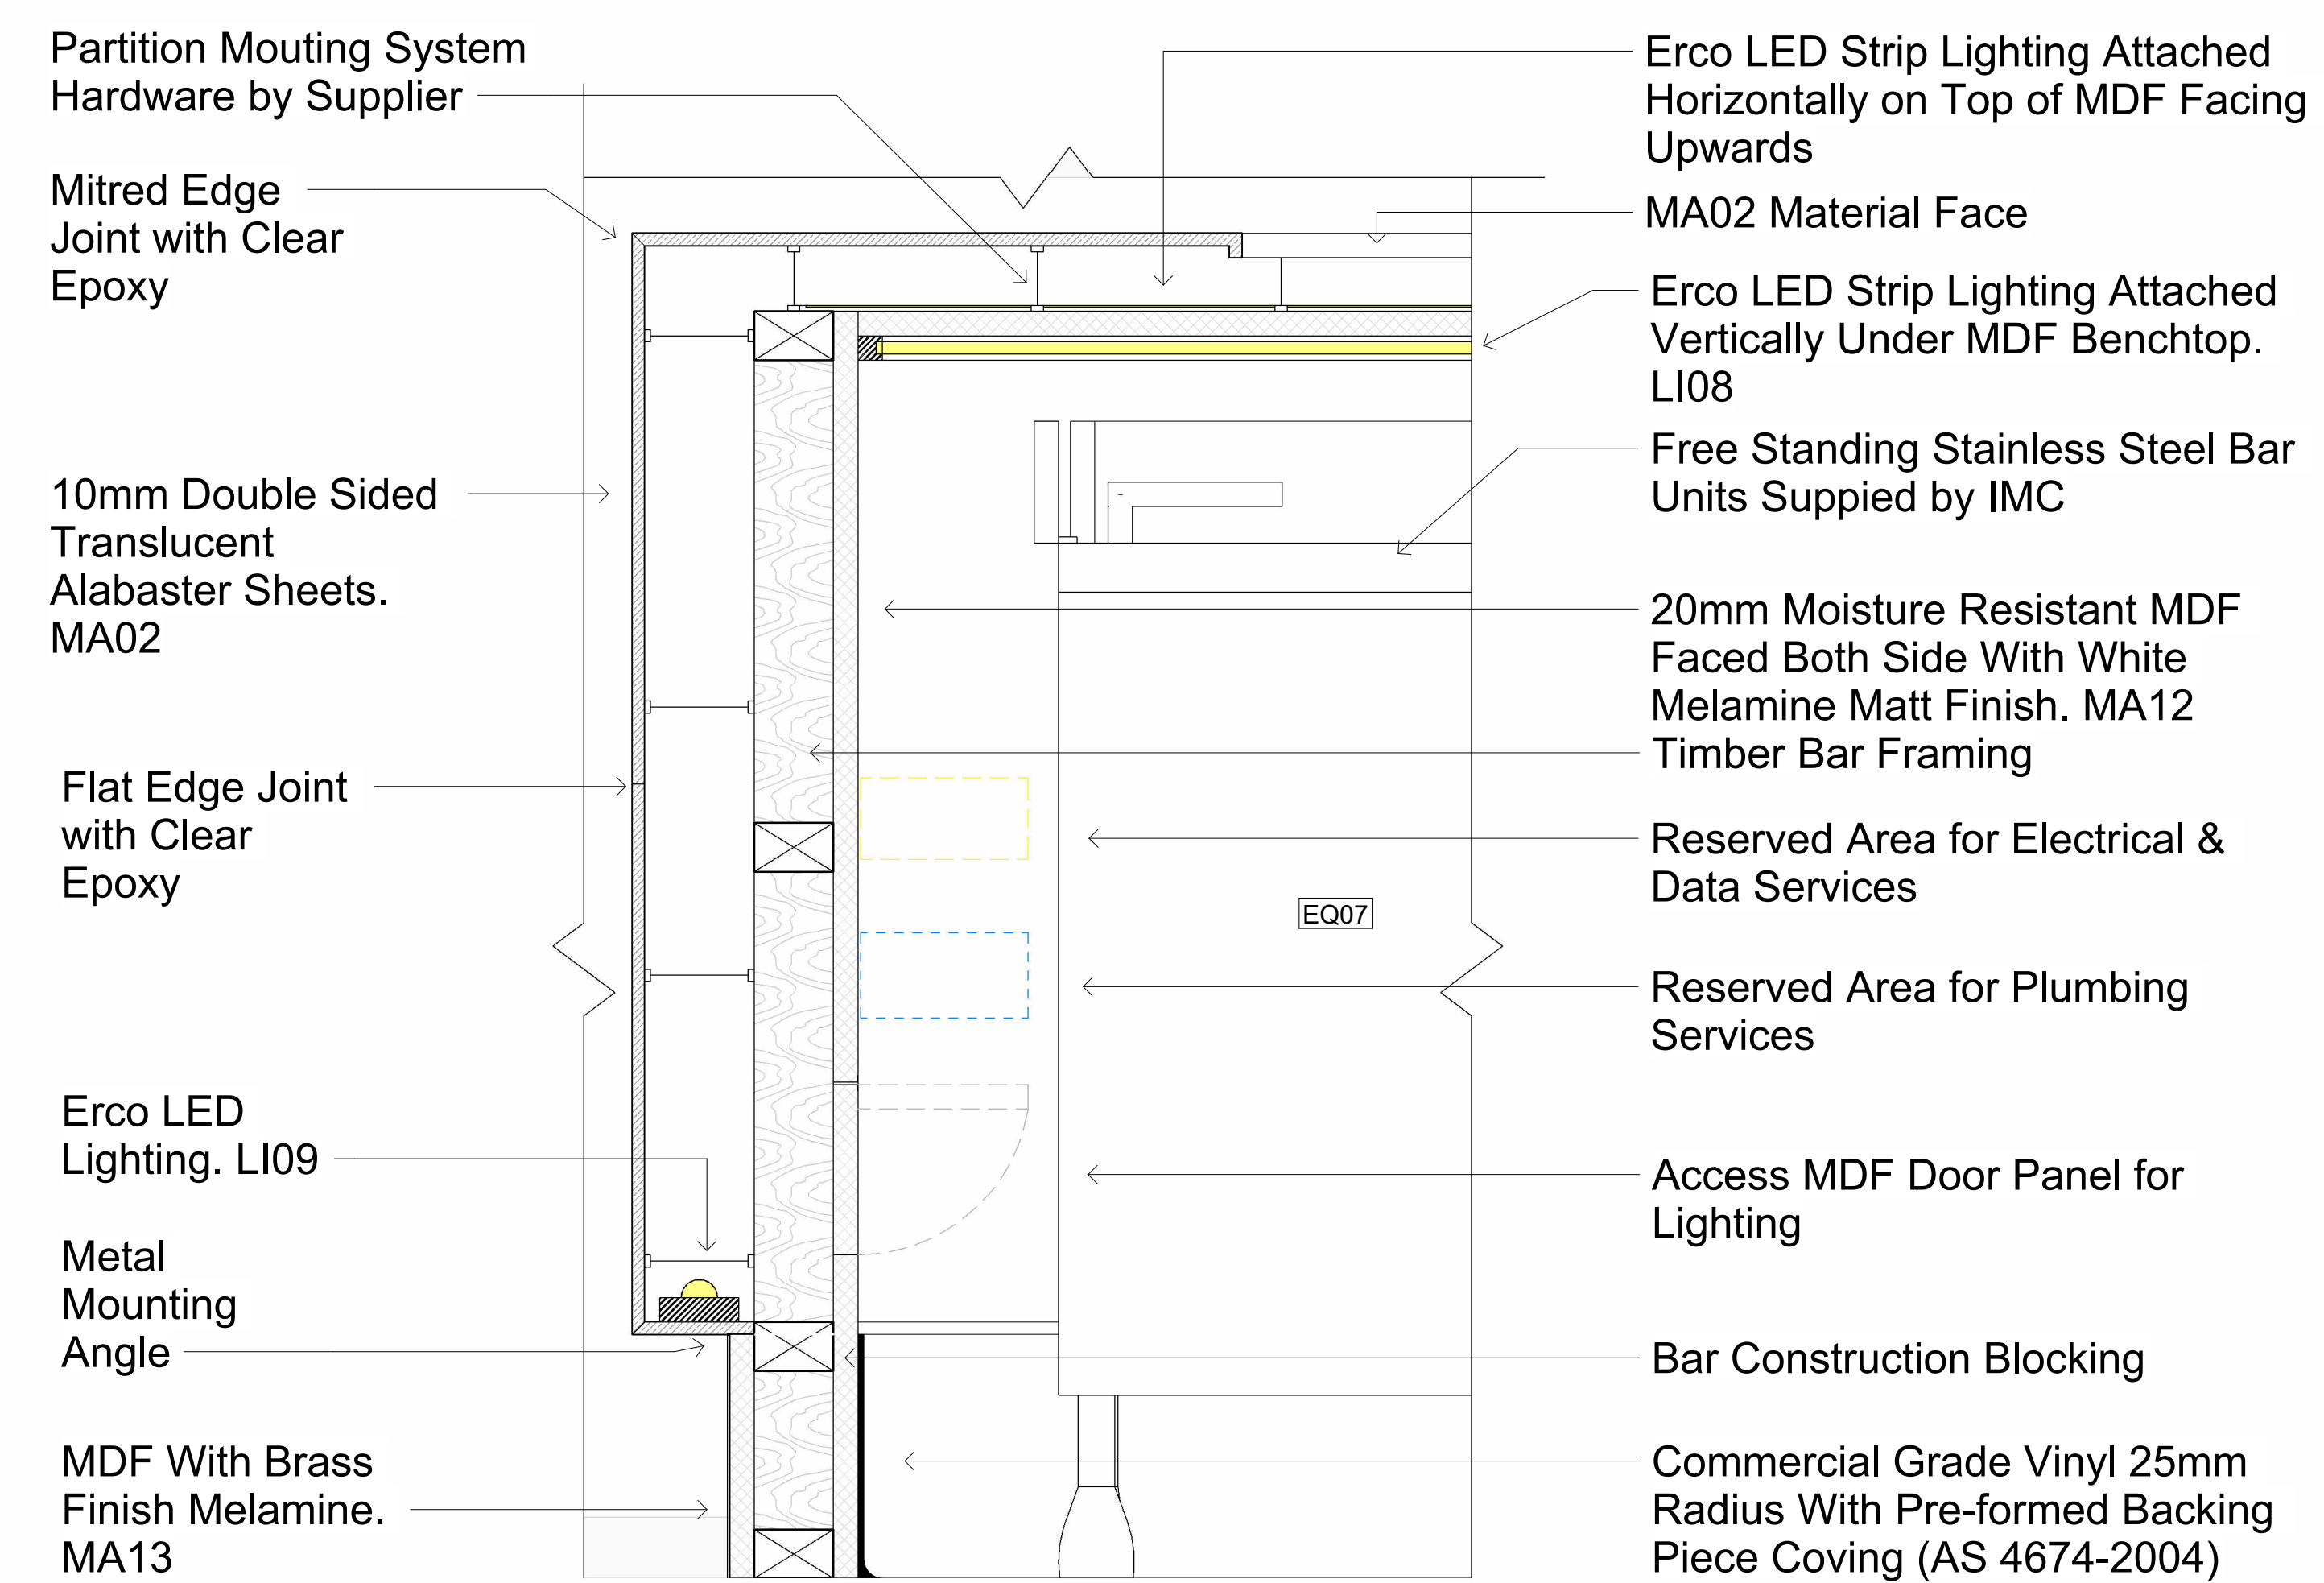

3 **Cocktail Bar Detail 1**
1 : 5

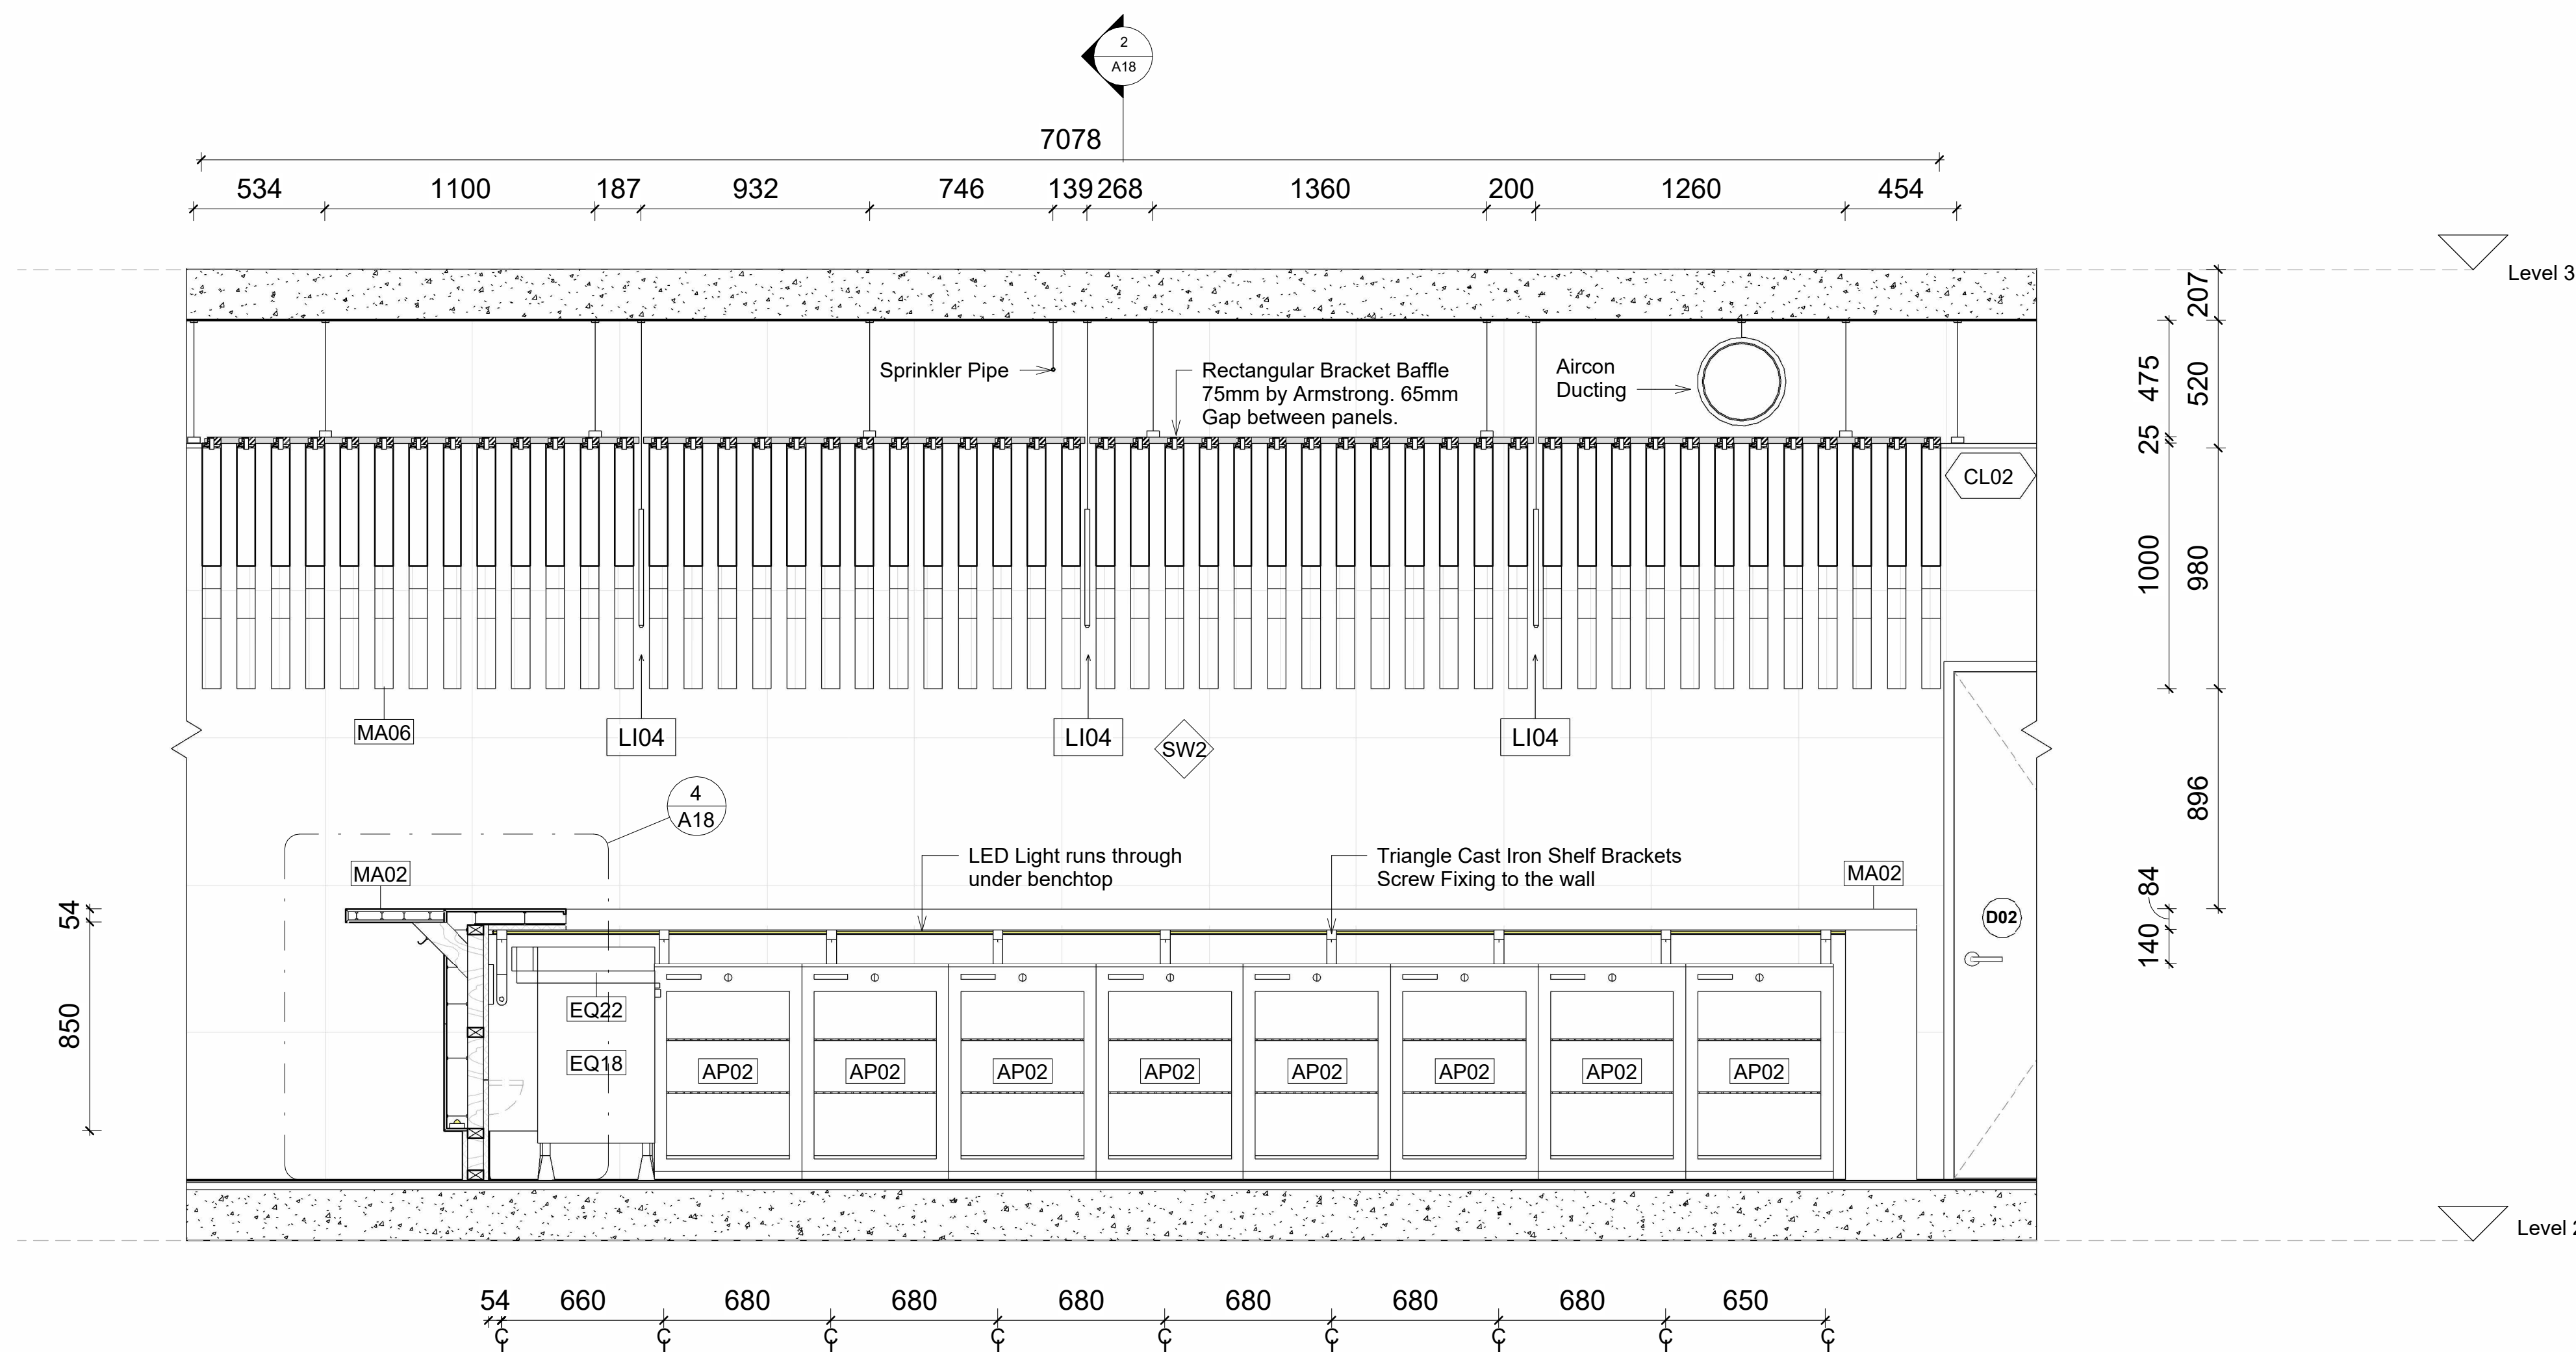


1 Cocktail Bar Section 2

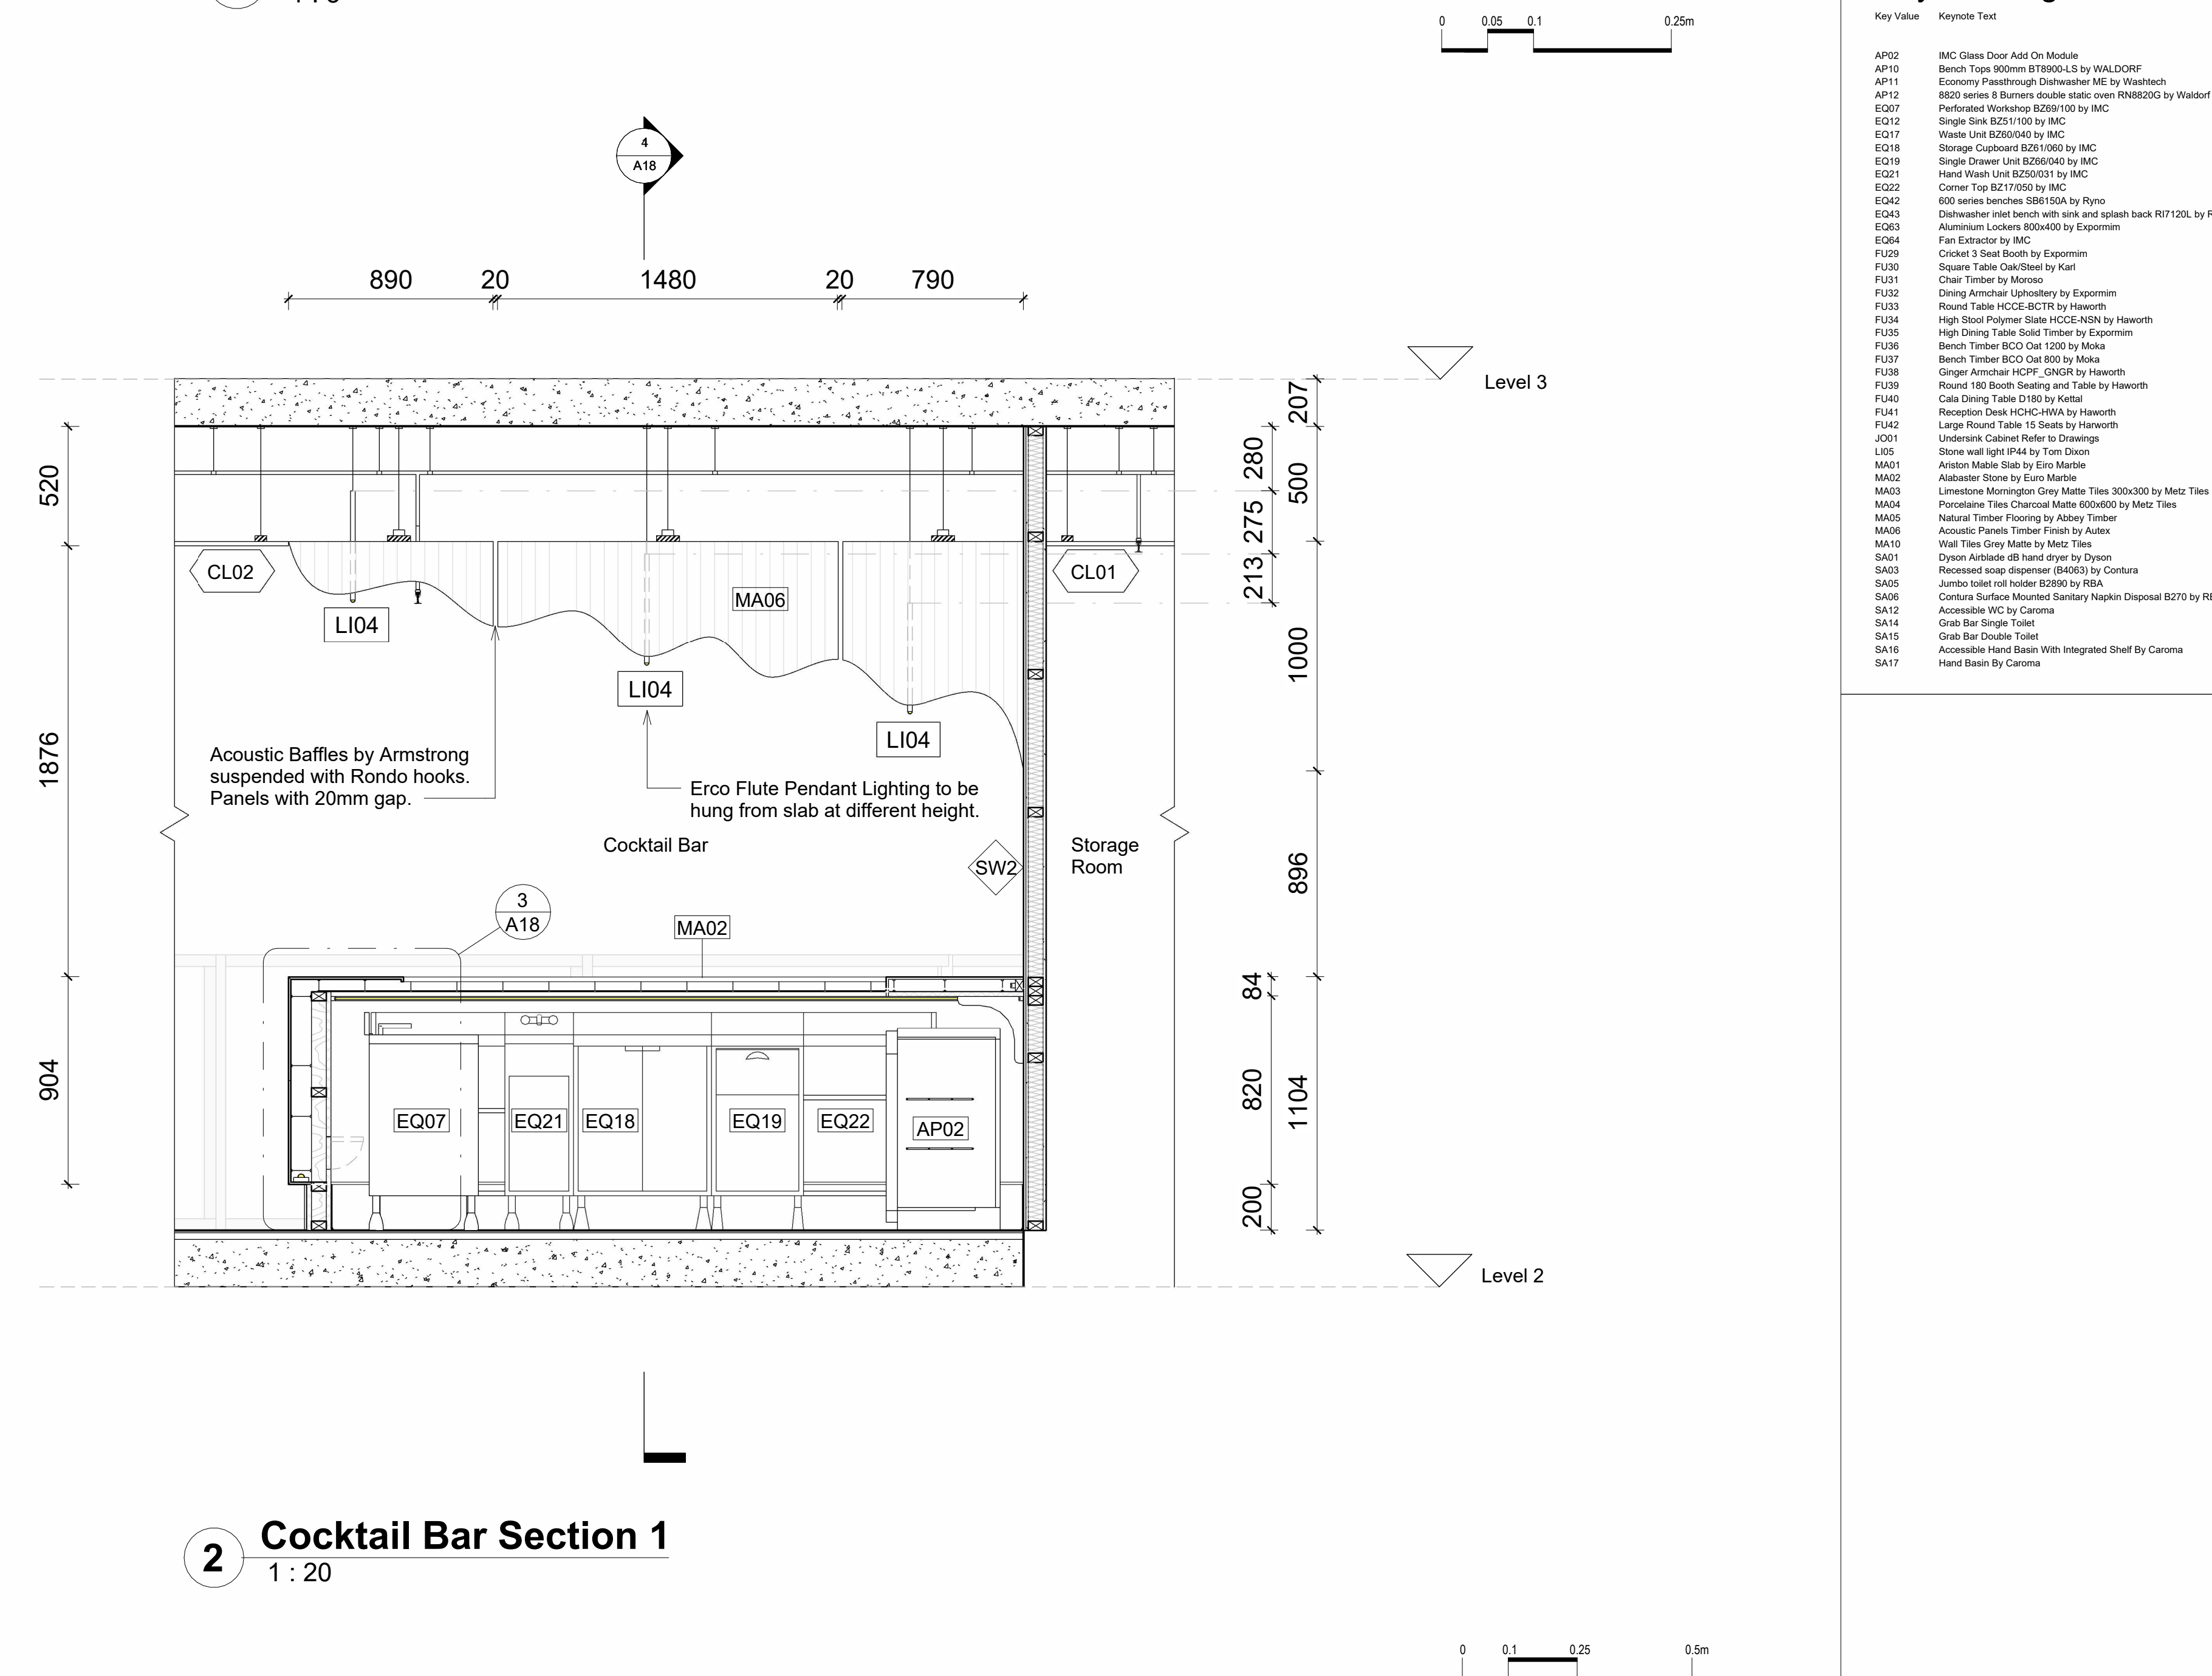


2 Cocktail Bar Section 1




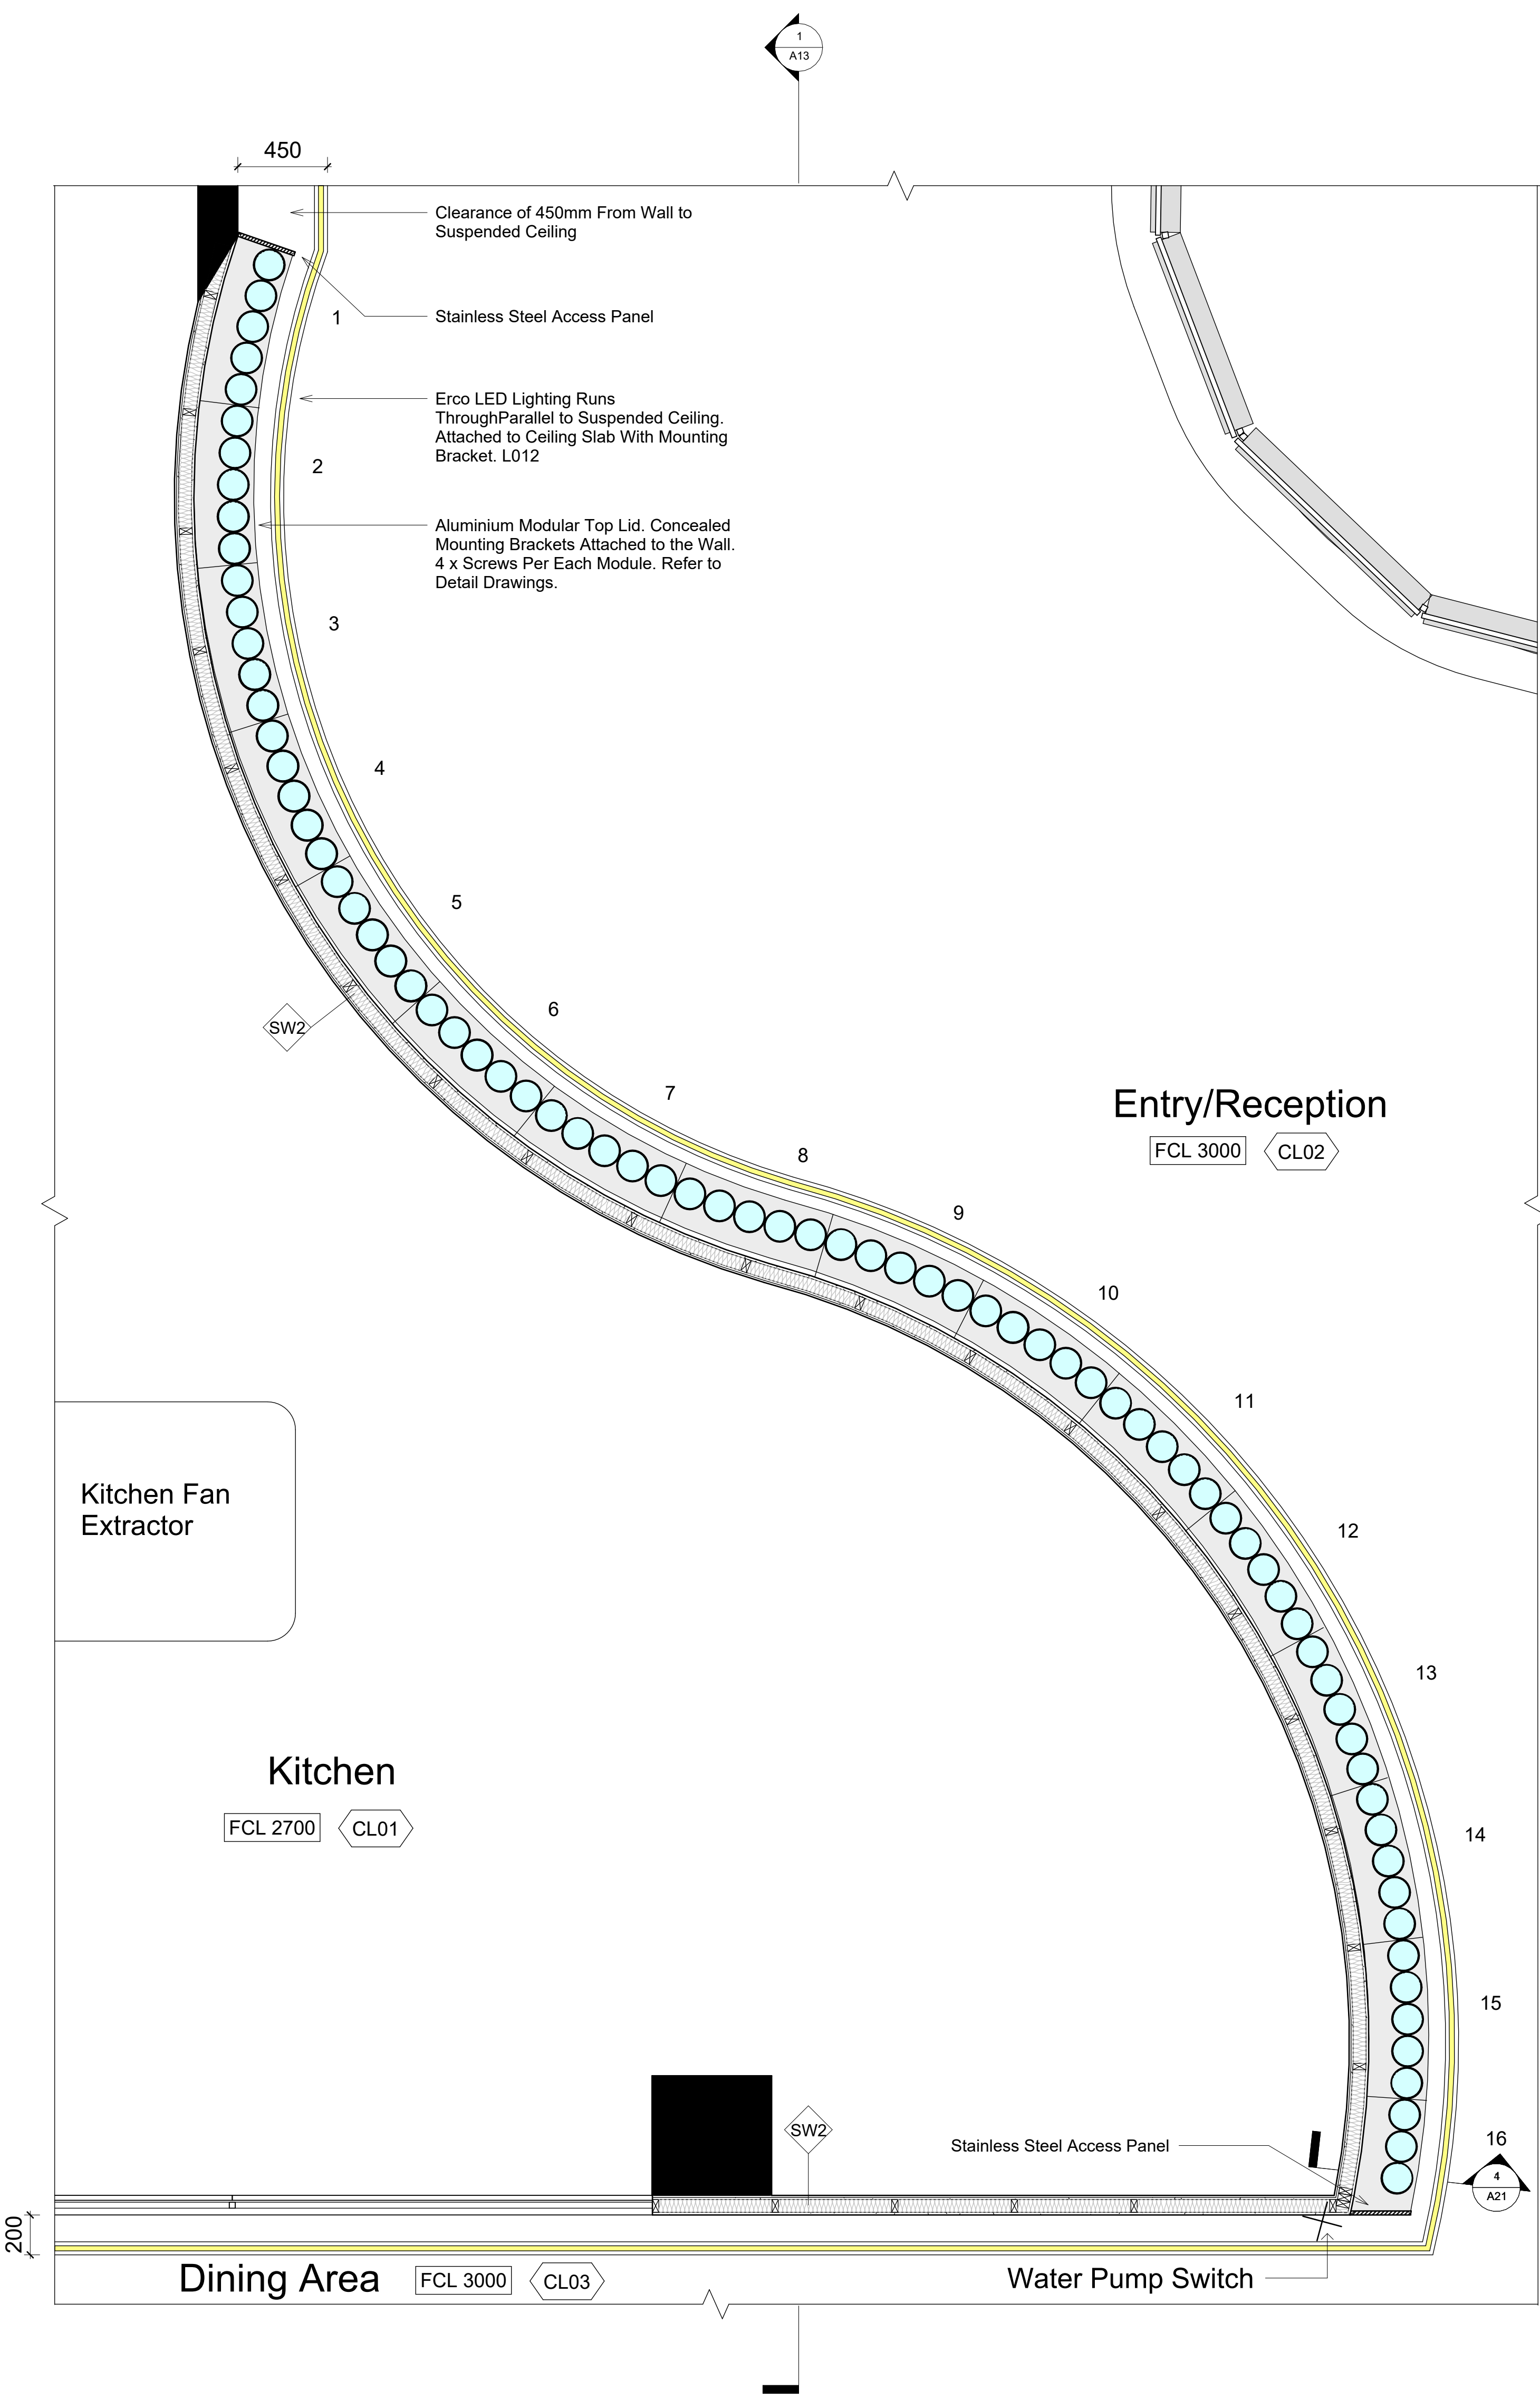


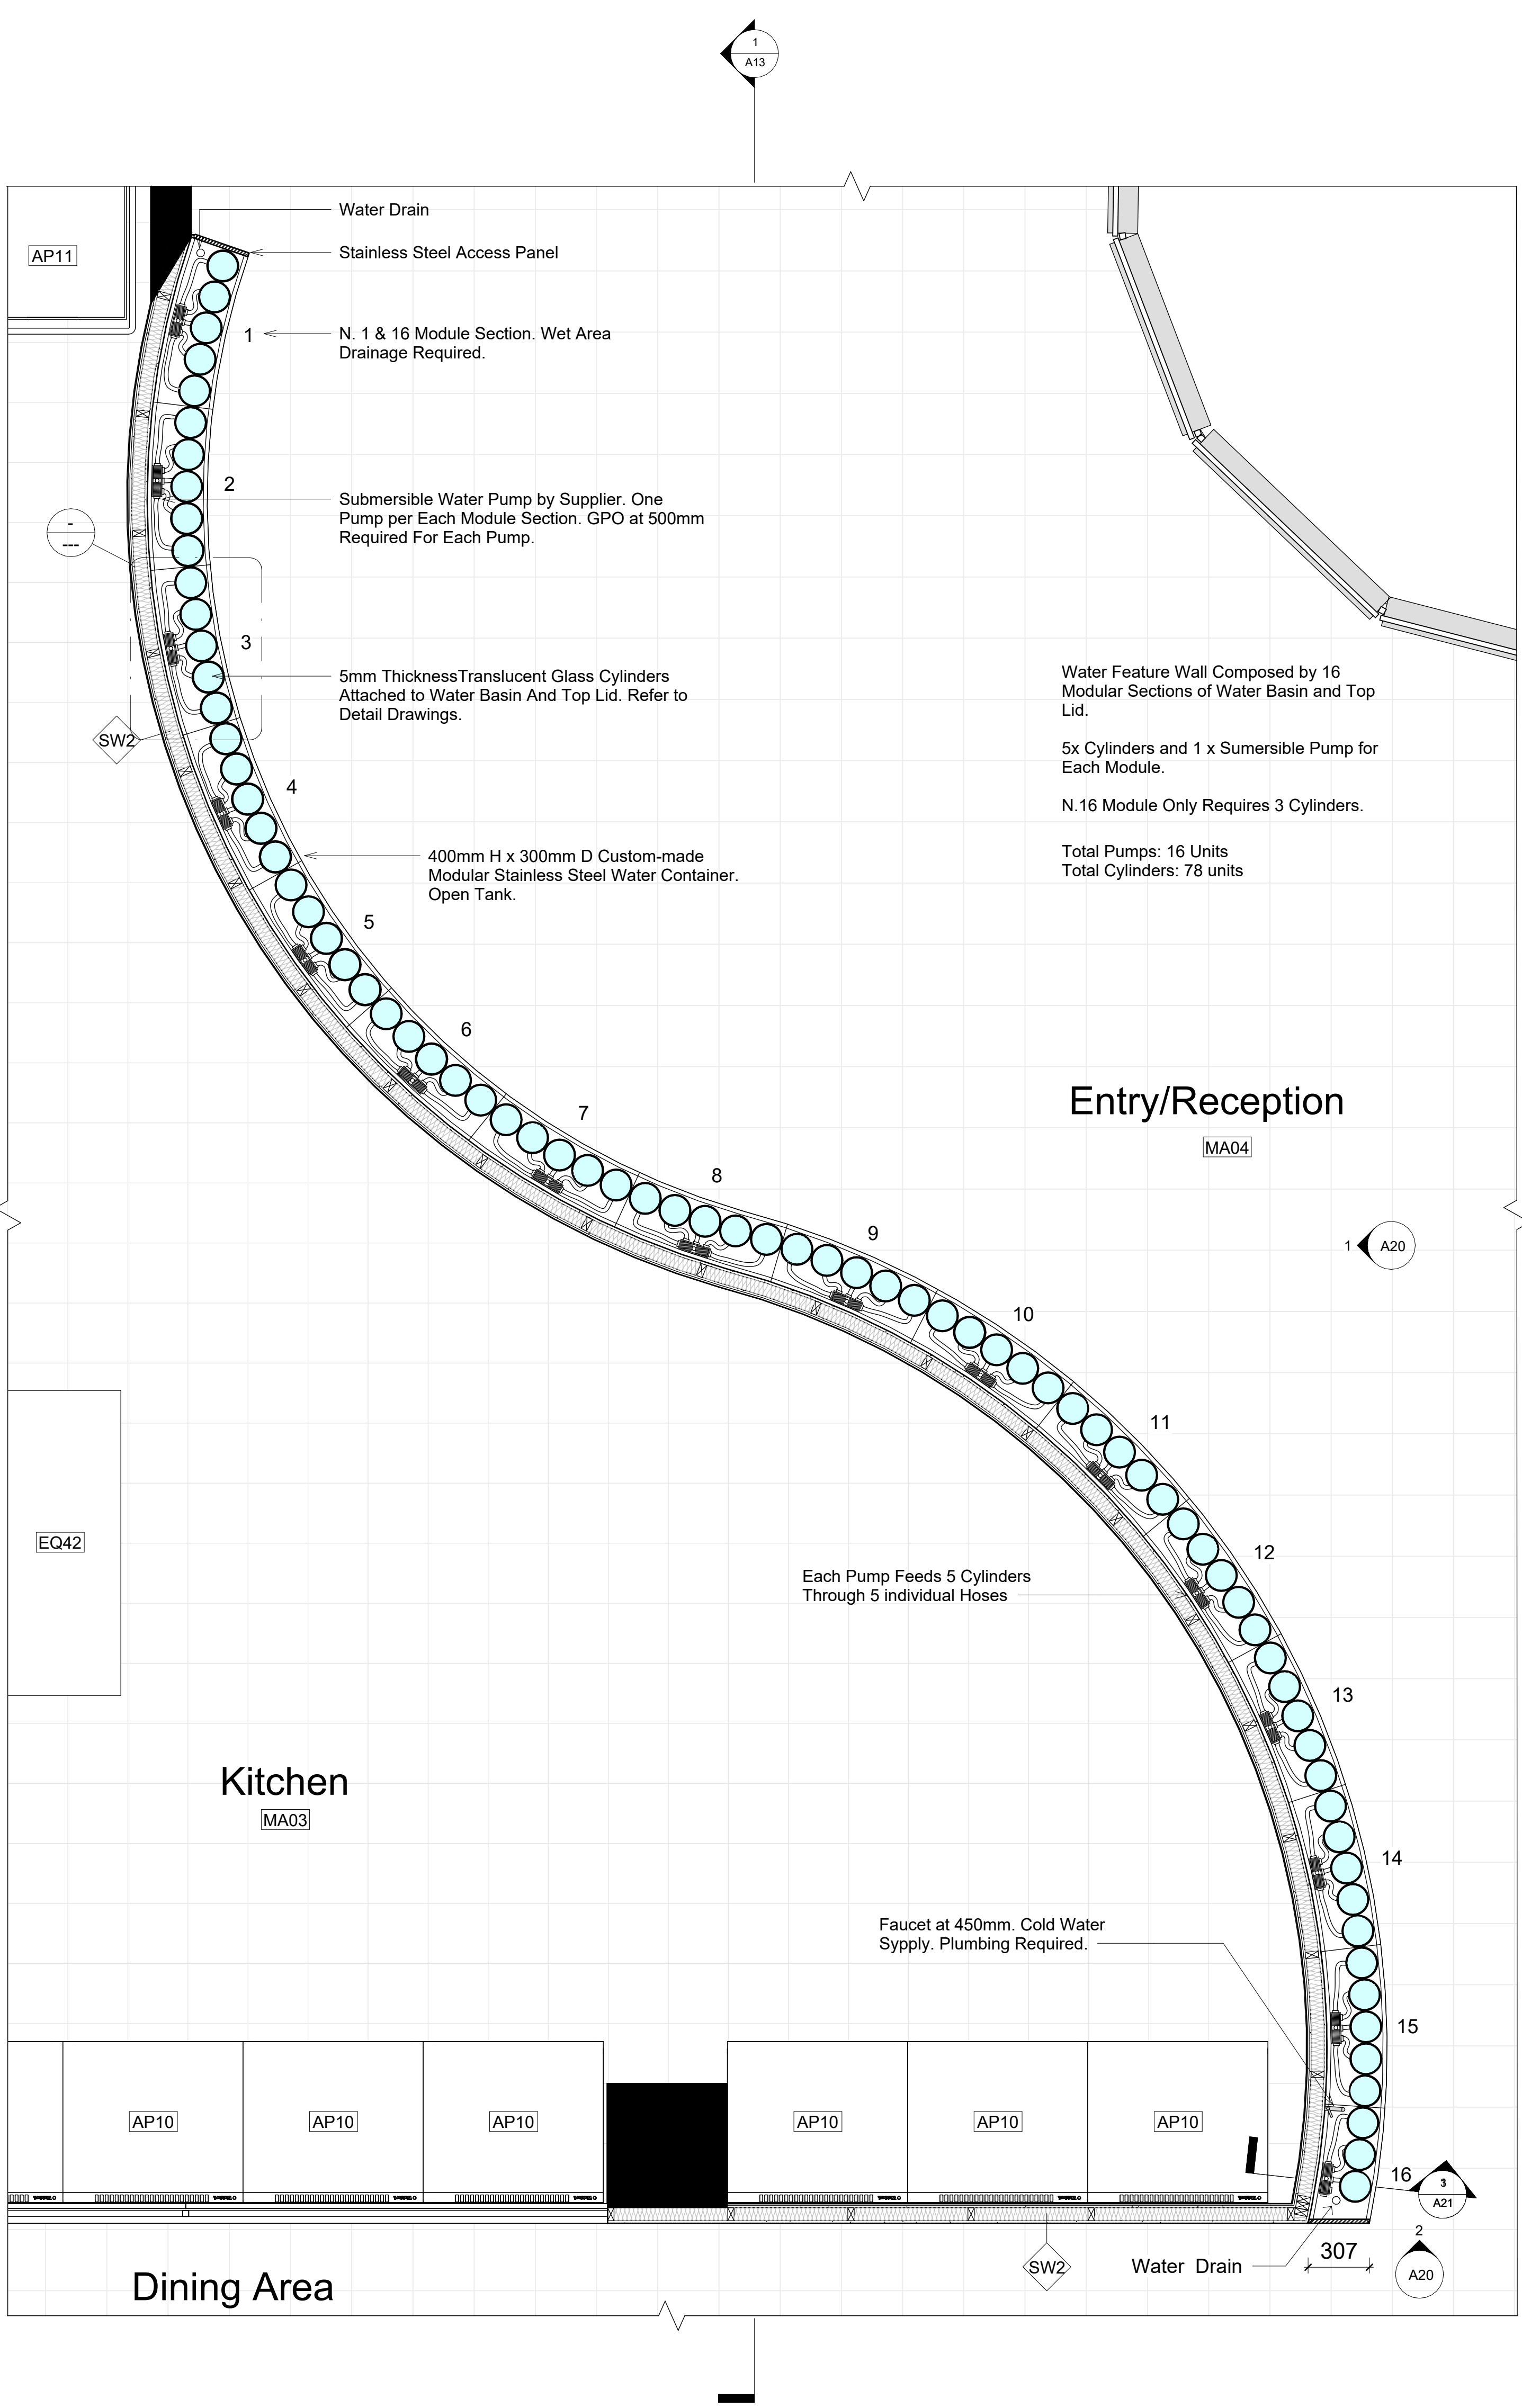  

 
 
 

 




Revisions			<p>Do not scale drawings. Use figured dimensions only. Check and verify levels and dimensions on site prior to commencement of drawings or the fabrication of components.</p> <p>This drawing is copyright and can not be reproduced without written consent.</p>		Client Ak	<p>Designed by: PS</p>  <p>PAMELLA SILVA INTERIOR DESIGNER</p>	NOTES	<p>True North</p> <p>Billy Blue College of Design 46-52 Mountain Street, Ultimo, NSW 2007, Australia +61 (0)2 9999 9999</p> <p> BILLY BLUE COLLEGE OF DESIGN</p> <p> TORRENS UNIVERSITY AUSTRALIA</p> <p> LAUREATE INTERNATIONAL UNIVERSITIES</p>	<p>Project Akira Back Restaurant</p> <p>Project Address: Level 2 Northern end of the Overseas Passenger Terminal, Circular Quay W, The Rocks NSW 2000</p> <p>Project number 2023. 002</p>	<p>Drawing Title Cocktail Bar Detail Section 1-2 & Detail Drawings</p> <p>Drawing Status TENDER ISSUE DRAWINGS NOT FOR CONSTRUCTION</p>	<p>Scale 1:20 & 1:5</p> <p>Drawing No A18</p> <p>Issue 01</p> <p>Date 10/12/23</p> <p>Drawn by PS</p>	<p>05/12/2023 14:35:49</p>
-----------	--	--	---	--	--------------	---	-------	---	---	---	--	----------------------------



2 RCP Water Feature Wall
1 : 20




 1 Plan Water Feature Wall
1 : 20


LEGEND			
Hatch Types			
	Existing		MDF
	Concrete		Earth
	Tile		Timber
	Plaster Board		Metal
Wall Types			
	STW1	13mm Plaster Board, 90mm Timber Stud Frame, 13mm Plaster Board	
	STW2	13mm Plaster Board, 90mm Timber Stud Frame, 13mm FC, 2mm Glue, 10mm Tile	
	STW3	10mm Tile, 2mm Glue, 13mm FC, 90mm Timber Stud Frame, 13mm FC, 2mm Glue, 10mm Tile	
Door Types			
	D01	Flush Interior Door 910 x 2110mm	
	D02	Flush Interior Door 810 x 2110mm	
	D03	Flush Interior Door 1010 x 2110mm	
	D04	Double Flush Exterior Door 1510 x 2110mm	
	D05	Double Flush Interior Door 1510 x 2110mm	
	D06	Curtain Glass Wall Flush Doors (Refer to FF&E for specification)	
Abbreviations			
FFL	Finished Floor Level		
FCL	Finished Ceiling Level		
CO2	Confirm On Site		
MA	Material		
FU	Furniture		
EQ	Specialty Equipment		
AP	Appliances		
LI	Lighting Fixture		
SA	Plumbing Fixture		

Keynote Legend	
Key Value	Keynote Text
AP10	AP10: Glass Door AP10: Glass Door
AP11	AP11: Glass Door AP11: Glass Door
AP12	AP12: Glass Door AP12: Glass Door
AP100	AP100: Glass Door AP100: Glass Door


Revisions			<div>Do not scale drawings. Use figured dimensions only. Check and verify levels and dimensions on site prior to commencement of any work, the preparation of drawings or the fabrication of components. This drawing is copyright and can not be reproduced without written consent.</div>	<div>Client Ak </div>	<div>Designed by: PS </div>	<div>NOTES</div>	<div>True North</div>	<div>Billy Blue College of Design 46-52 Mountain Street, Ultimo, NSW 2007, Australia +61 (0)2 9999 9999  </div>	<div>Project Akira Back Restaurant Project Address: Level 2 Northern end of the Overseas Passenger Terminal, Circular Quay W, The Rocks NSW 2000 Project number 2023. 002</div>	<div>Drawing Title Water Feature Wall Plan & RCP Drawing Status TENDER ISSUE DRAWINGS NOT FOR CONSTRUCTION</div>	<div>Scale</div> 1:20	<div>Drawing No</div> A19	<div>Issue</div> 01
No	Date	Description									Ver. App'd	<div>Date</div> 10/12/23	<div>Drawn by</div> PS
01	29/10/23	TENDER DRAWINGS NOT FOR CONSTRUCTION									Approver		
02	19/11/23	TENDER DRAWINGS NOT FOR CONSTRUCTION									Approver		
03	10/12/23	TENDER DRAWINGS NOT FOR CONSTRUCTION									Approver		

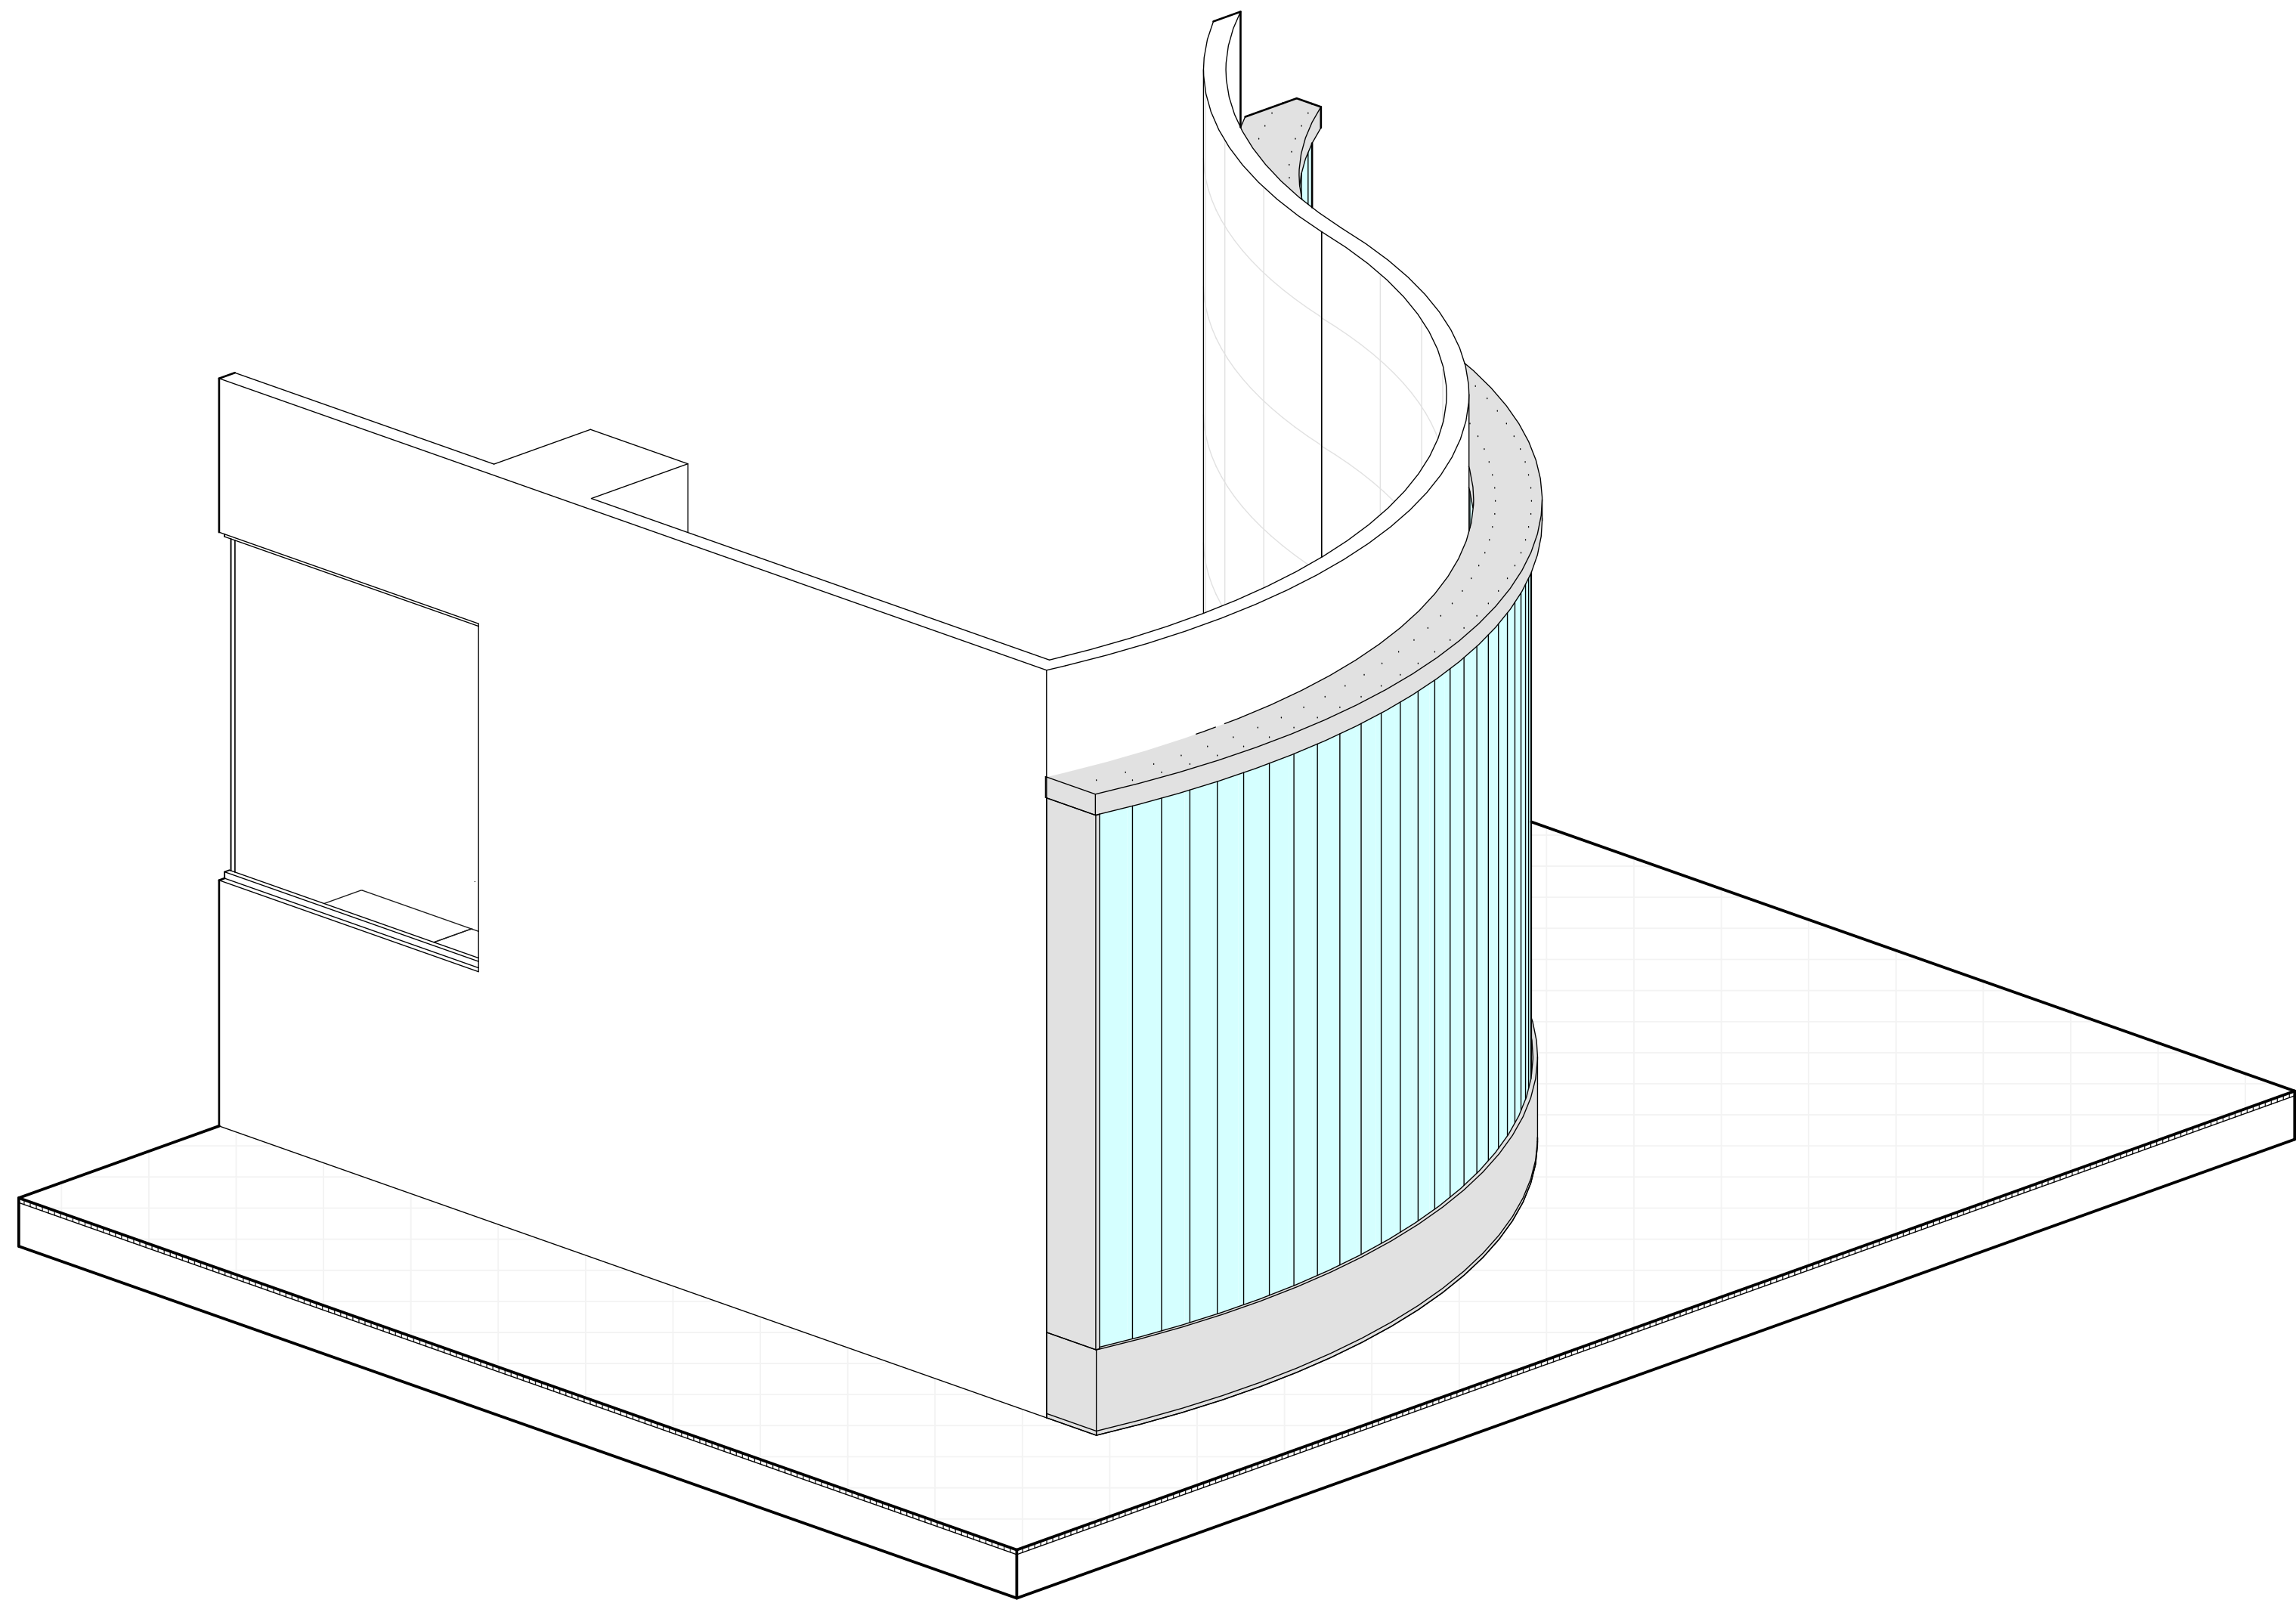


4 Water Feature Wall Isometric 2

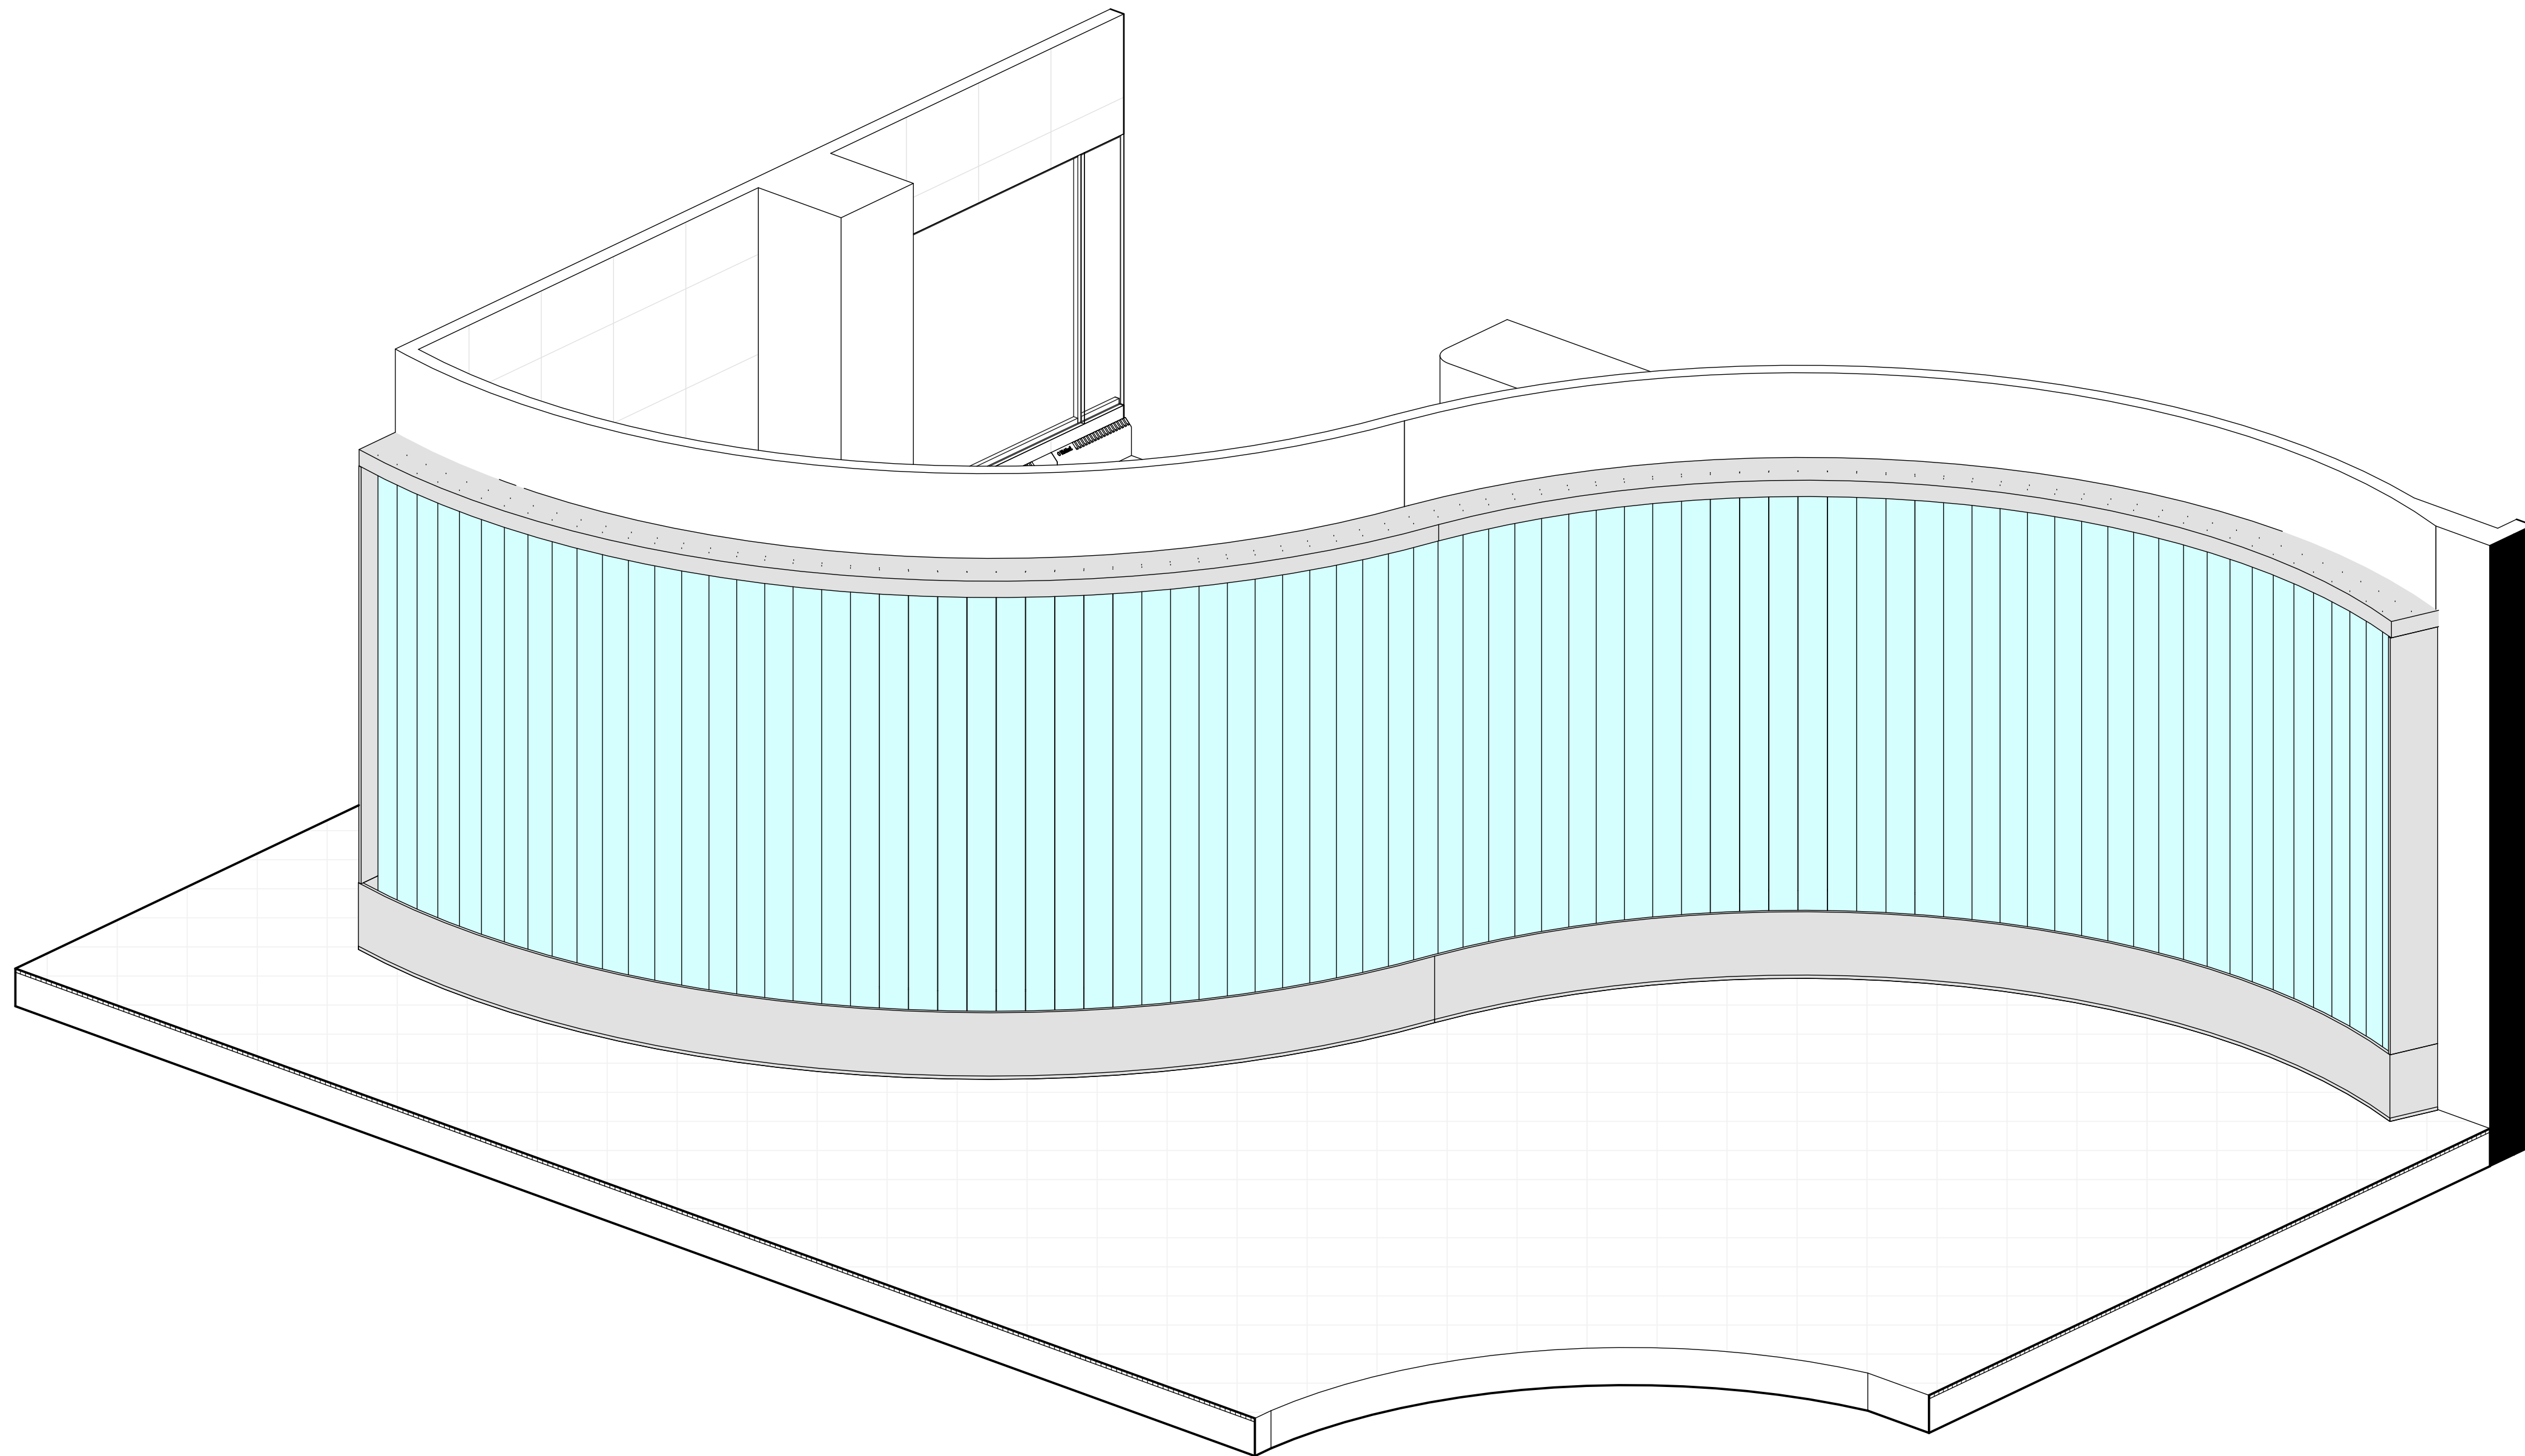

3 Water Feature Wall Isometric 1

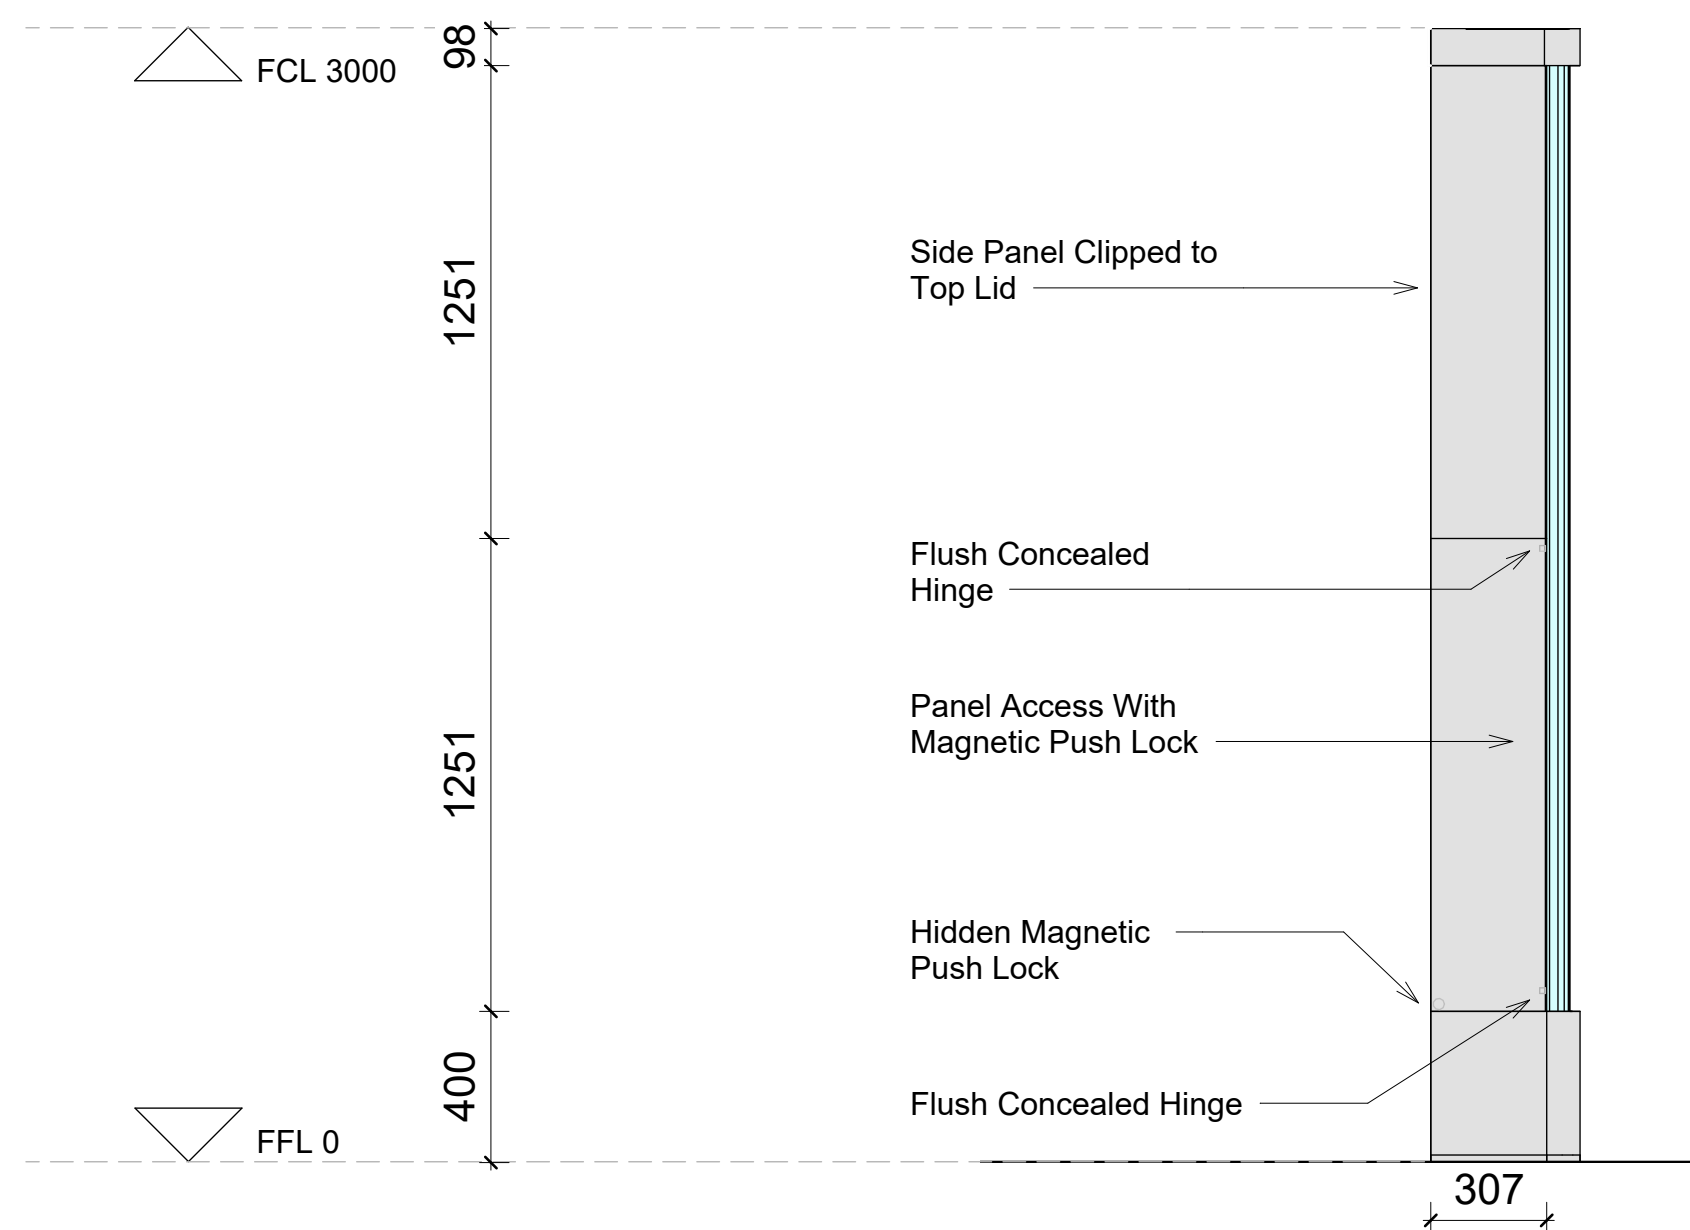

2 Water Feature Wall Side Elevation
1 : 20

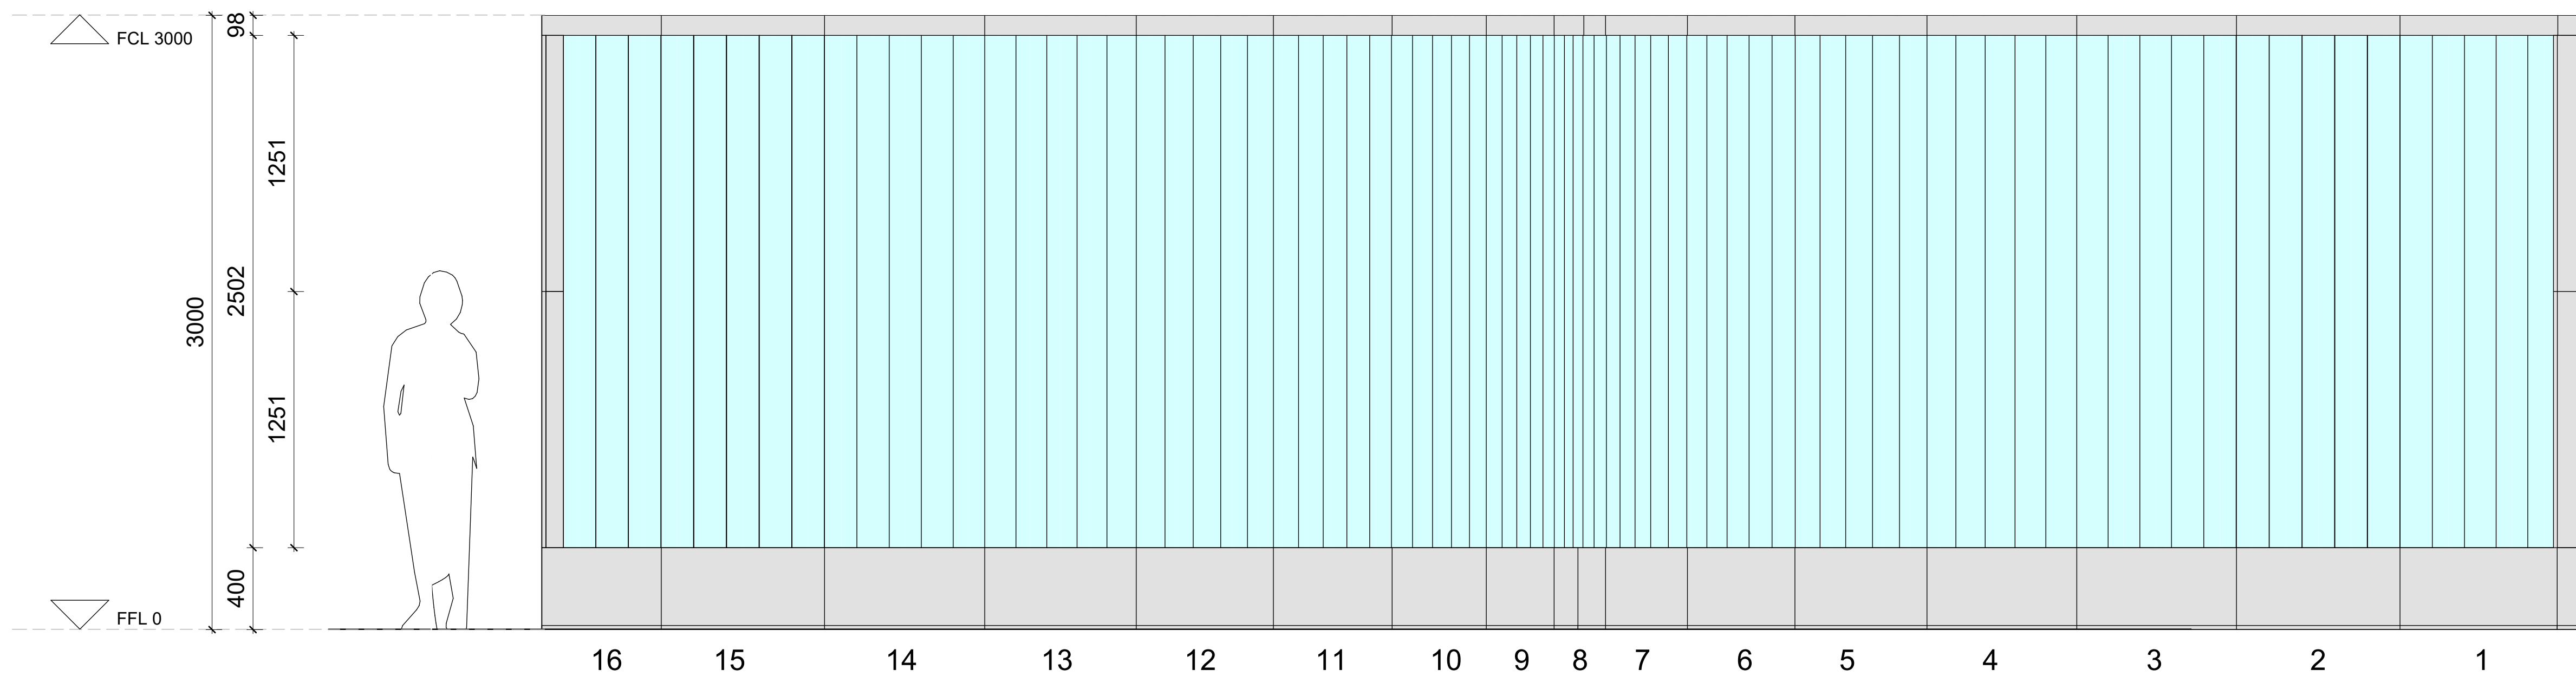

1 Water Feature Wall Front Elevation
1 : 20

LEGEND

Hatch Types

	Existing		MDF
	Concrete		Earth
	Tile		Timber
	Plaster Board		Metal

Wall Types

	13mm Plaster Board, 90mm Timber Stud Frame, 13mm Plaster Board
	13mm Plaster Board, 90mm Timber Stud Frame, 13mm FC, 2mm Glue, 10mm Tile
	10mm Tile, 2mm Glue, 13mm FC, 90mm Timber Stud Frame, 13mm FC, 2mm Glue, 10mm Tile

Door Types

	Flush Interior Door 910 x 2110mm
	Flush Interior Door 810 x 2110mm
	Flush Interior Door 1010 x 2110mm
	Double Flush Exterior Door 1510 x 2110mm
	Double Flush Interior Door 1510 x 2110mm
	Curtain Glass Wall Flush Doors (Refer to FF&E for specification)

Abbreviations



FFL	Finished Floor Level
FCL	Finished Ceiling Level
COS	Confirm On Site
MA	Material
FU	Furniture
EQ	Specialty Equipment
AP	Appliances
LI	Lighting Fixture
SA	Plumbing Fixture

Keynote Legend


Key Value

Key Value	Keynote Text
AP02	MFC Glass Door A65 20-100mm
AP10	Brush Type 90mm 100mm L.S. by W&DQSF
AP11	Brush Type 90mm 100mm L.S. by W&DQSF
AP12	Brush Type 90mm 100mm L.S. by W&DQSF
EQ07	Brush Type 90mm 100mm L.S. by W&DQSF
EQ12	Brush Type 90mm 100mm L.S. by W&DQSF
EQ17	Brush Type 90mm 100mm L.S. by W&DQSF
EQ18	Brush Type 90mm 100mm L.S. by W&DQSF
EQ19	Brush Type 90mm 100mm L.S. by W&DQSF
EQ21	Brush Type 90mm 100mm L.S. by W&DQSF
EQ22	Brush Type 90mm 100mm L.S. by W&DQSF
EQ24	Brush Type 90mm 100mm L.S. by W&DQSF
EQ25	Brush Type 90mm 100mm L.S. by W&DQSF
EQ26	Brush Type 90mm 100mm L.S. by W&DQSF
EQ100	Brush Type 90mm 100mm L.S. by W&DQSF


Revisions			<div>Do not scale drawings. Use figured dimensions only. Check and verify levels and dimensions on site prior to commencement of any work, the preparation of drawings or the fabrication of components. This drawing is copyright and can not be reproduced without written consent.</div>	Client Ak		Designed by: PS	<div>PAMELLA SILVA INTERIOR DESIGNER</div>	NOTES	<div>True North</div>	<div>Billy Blue College of Design 46-52 Mountain Street, Ultimo, NSW 2007, Australia +61 (0)2 9999 9999</div>	<div>Project Akira Back Restaurant</div>	<div>Project Address: Level 2 Northern end of the Overseas Passenger Terminal, Circular Quay W, The Rocks NSW 2000</div>	<div>Project number 2023_002</div>	<div>Drawing Title Water Feature Wall Elevations</div>	<div>Drawing No A20</div>	<div>Issue 01</div>	<div>Scale 1:20</div>	<div>Date 10/12/23</div>	<div>Drawn by PS</div>	<div>Drawing Status TENDER ISSUE DRAWINGS NOT FOR CONSTRUCTION</div>	
No	Date	Description																			Ver. App'd
01	29/10/23	TENDER DRAWINGS NOT FOR CONSTRUCTION																			XX App'd
02	19/11/23	TENDER DRAWINGS NOT FOR CONSTRUCTION																			XX App'd
03	10/12/23	TENDER DRAWINGS NOT FOR CONSTRUCTION																			XX App'd

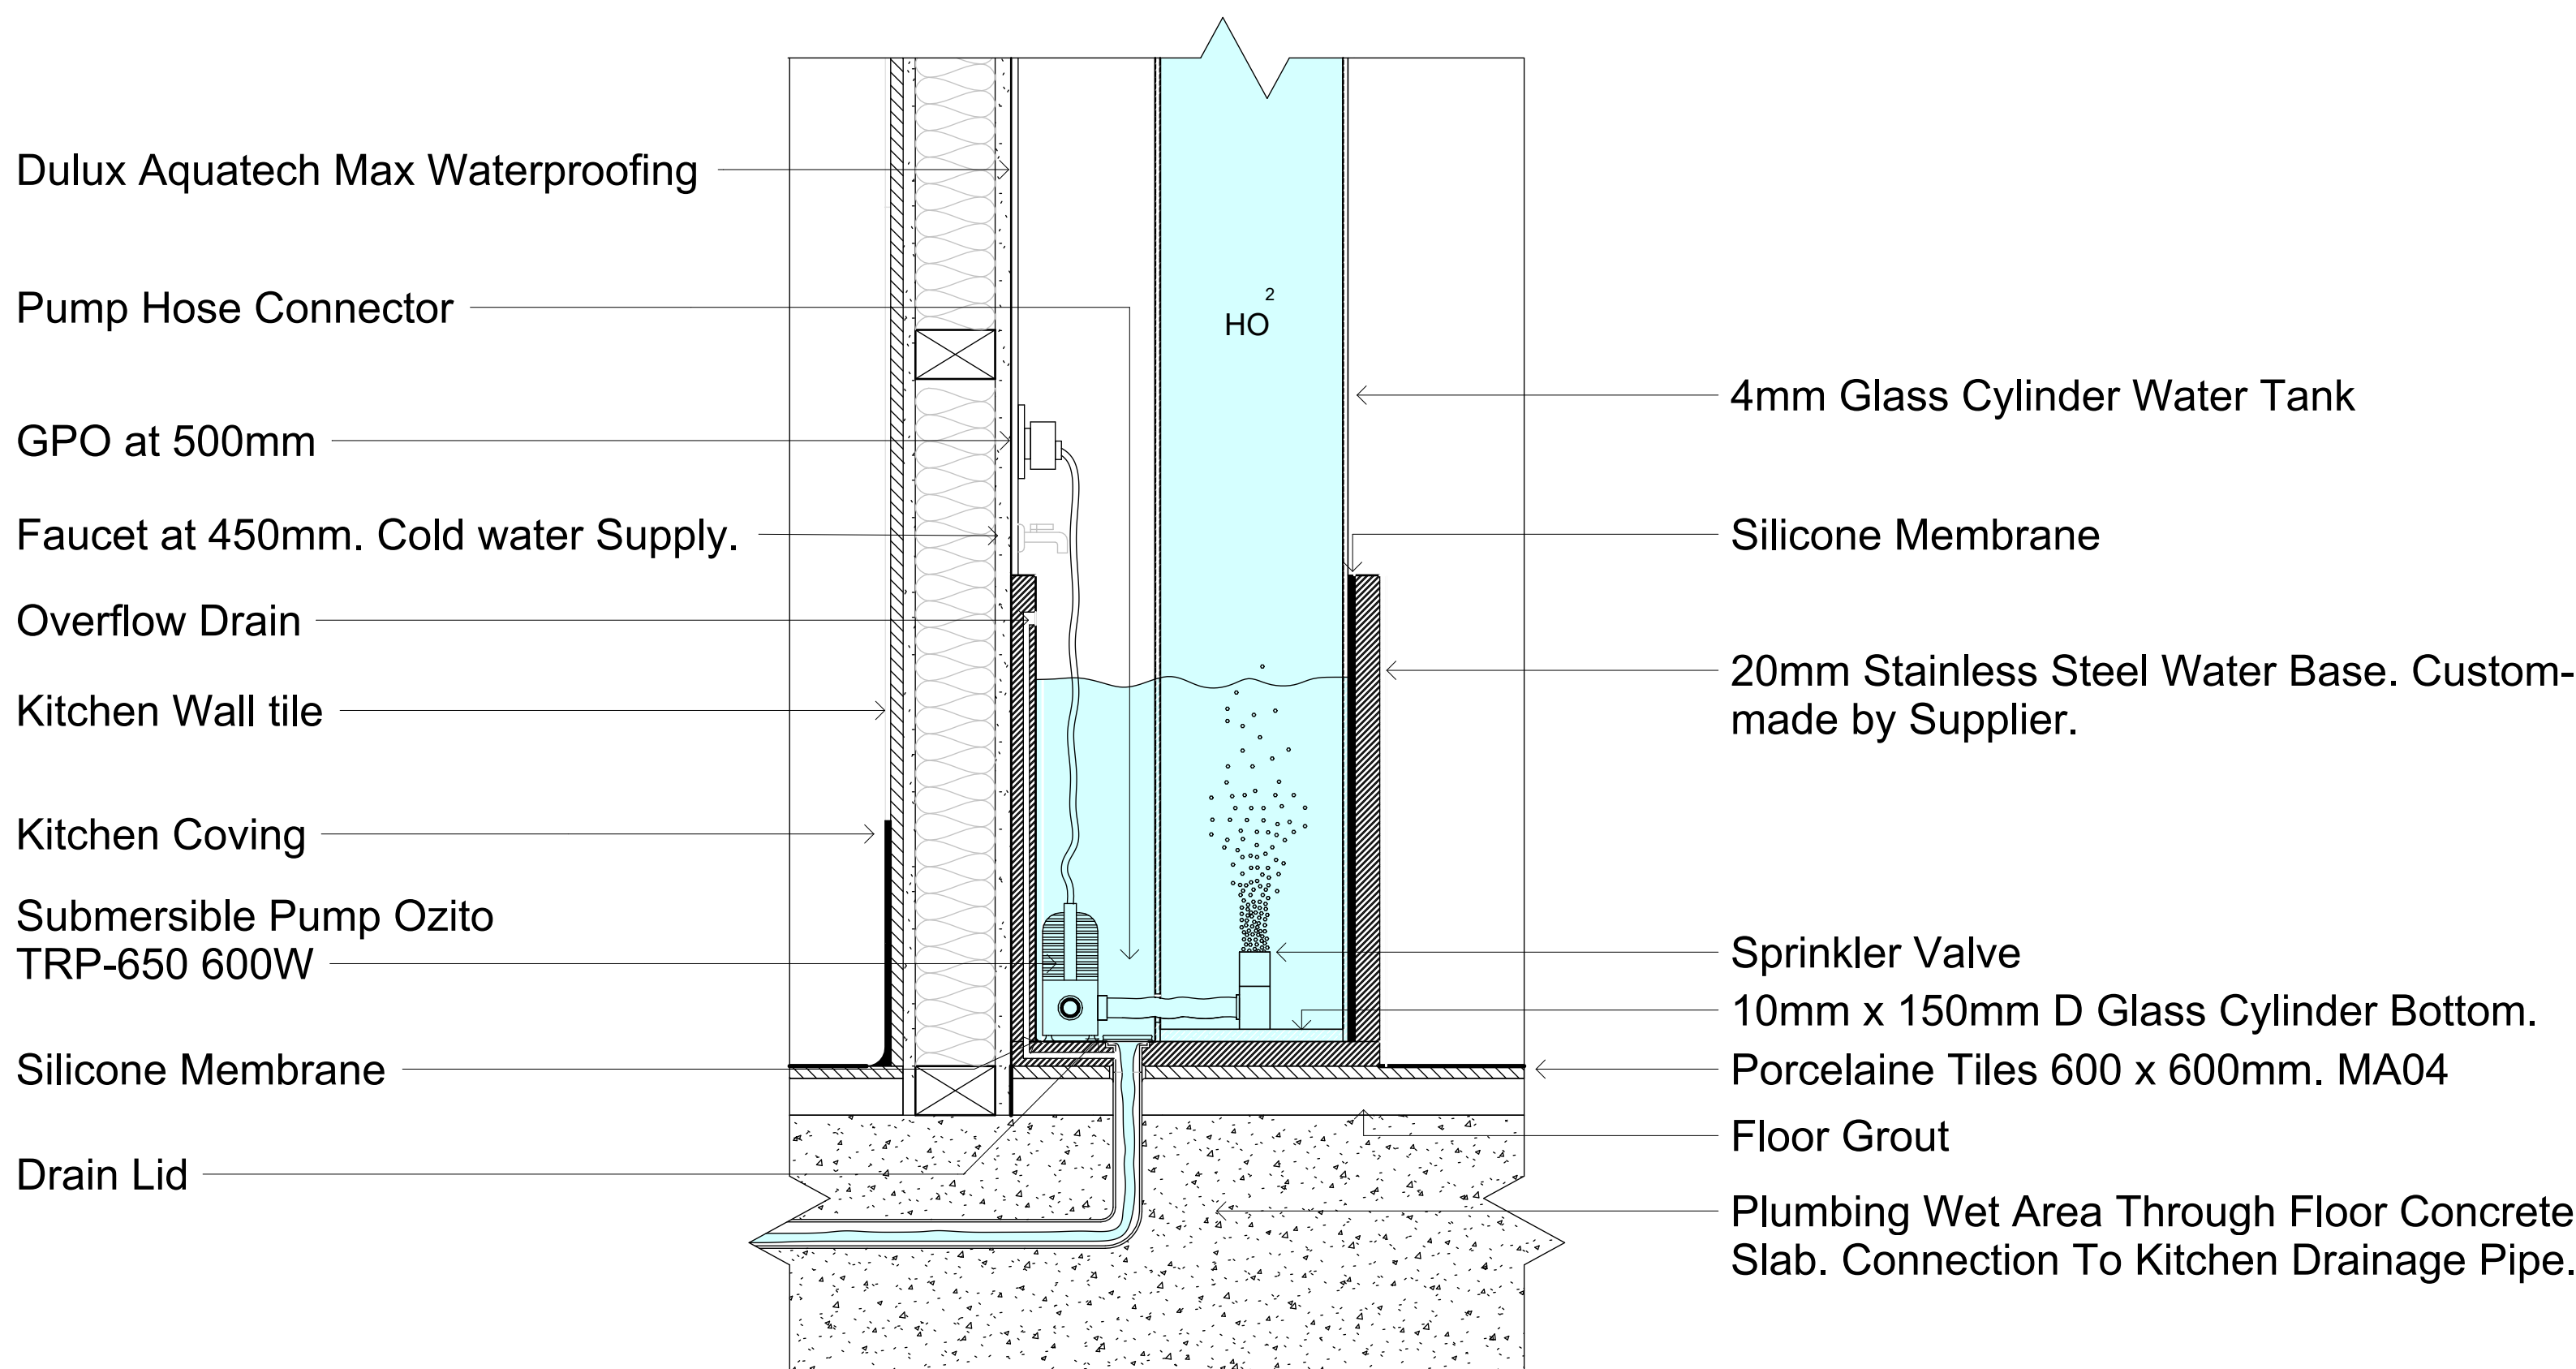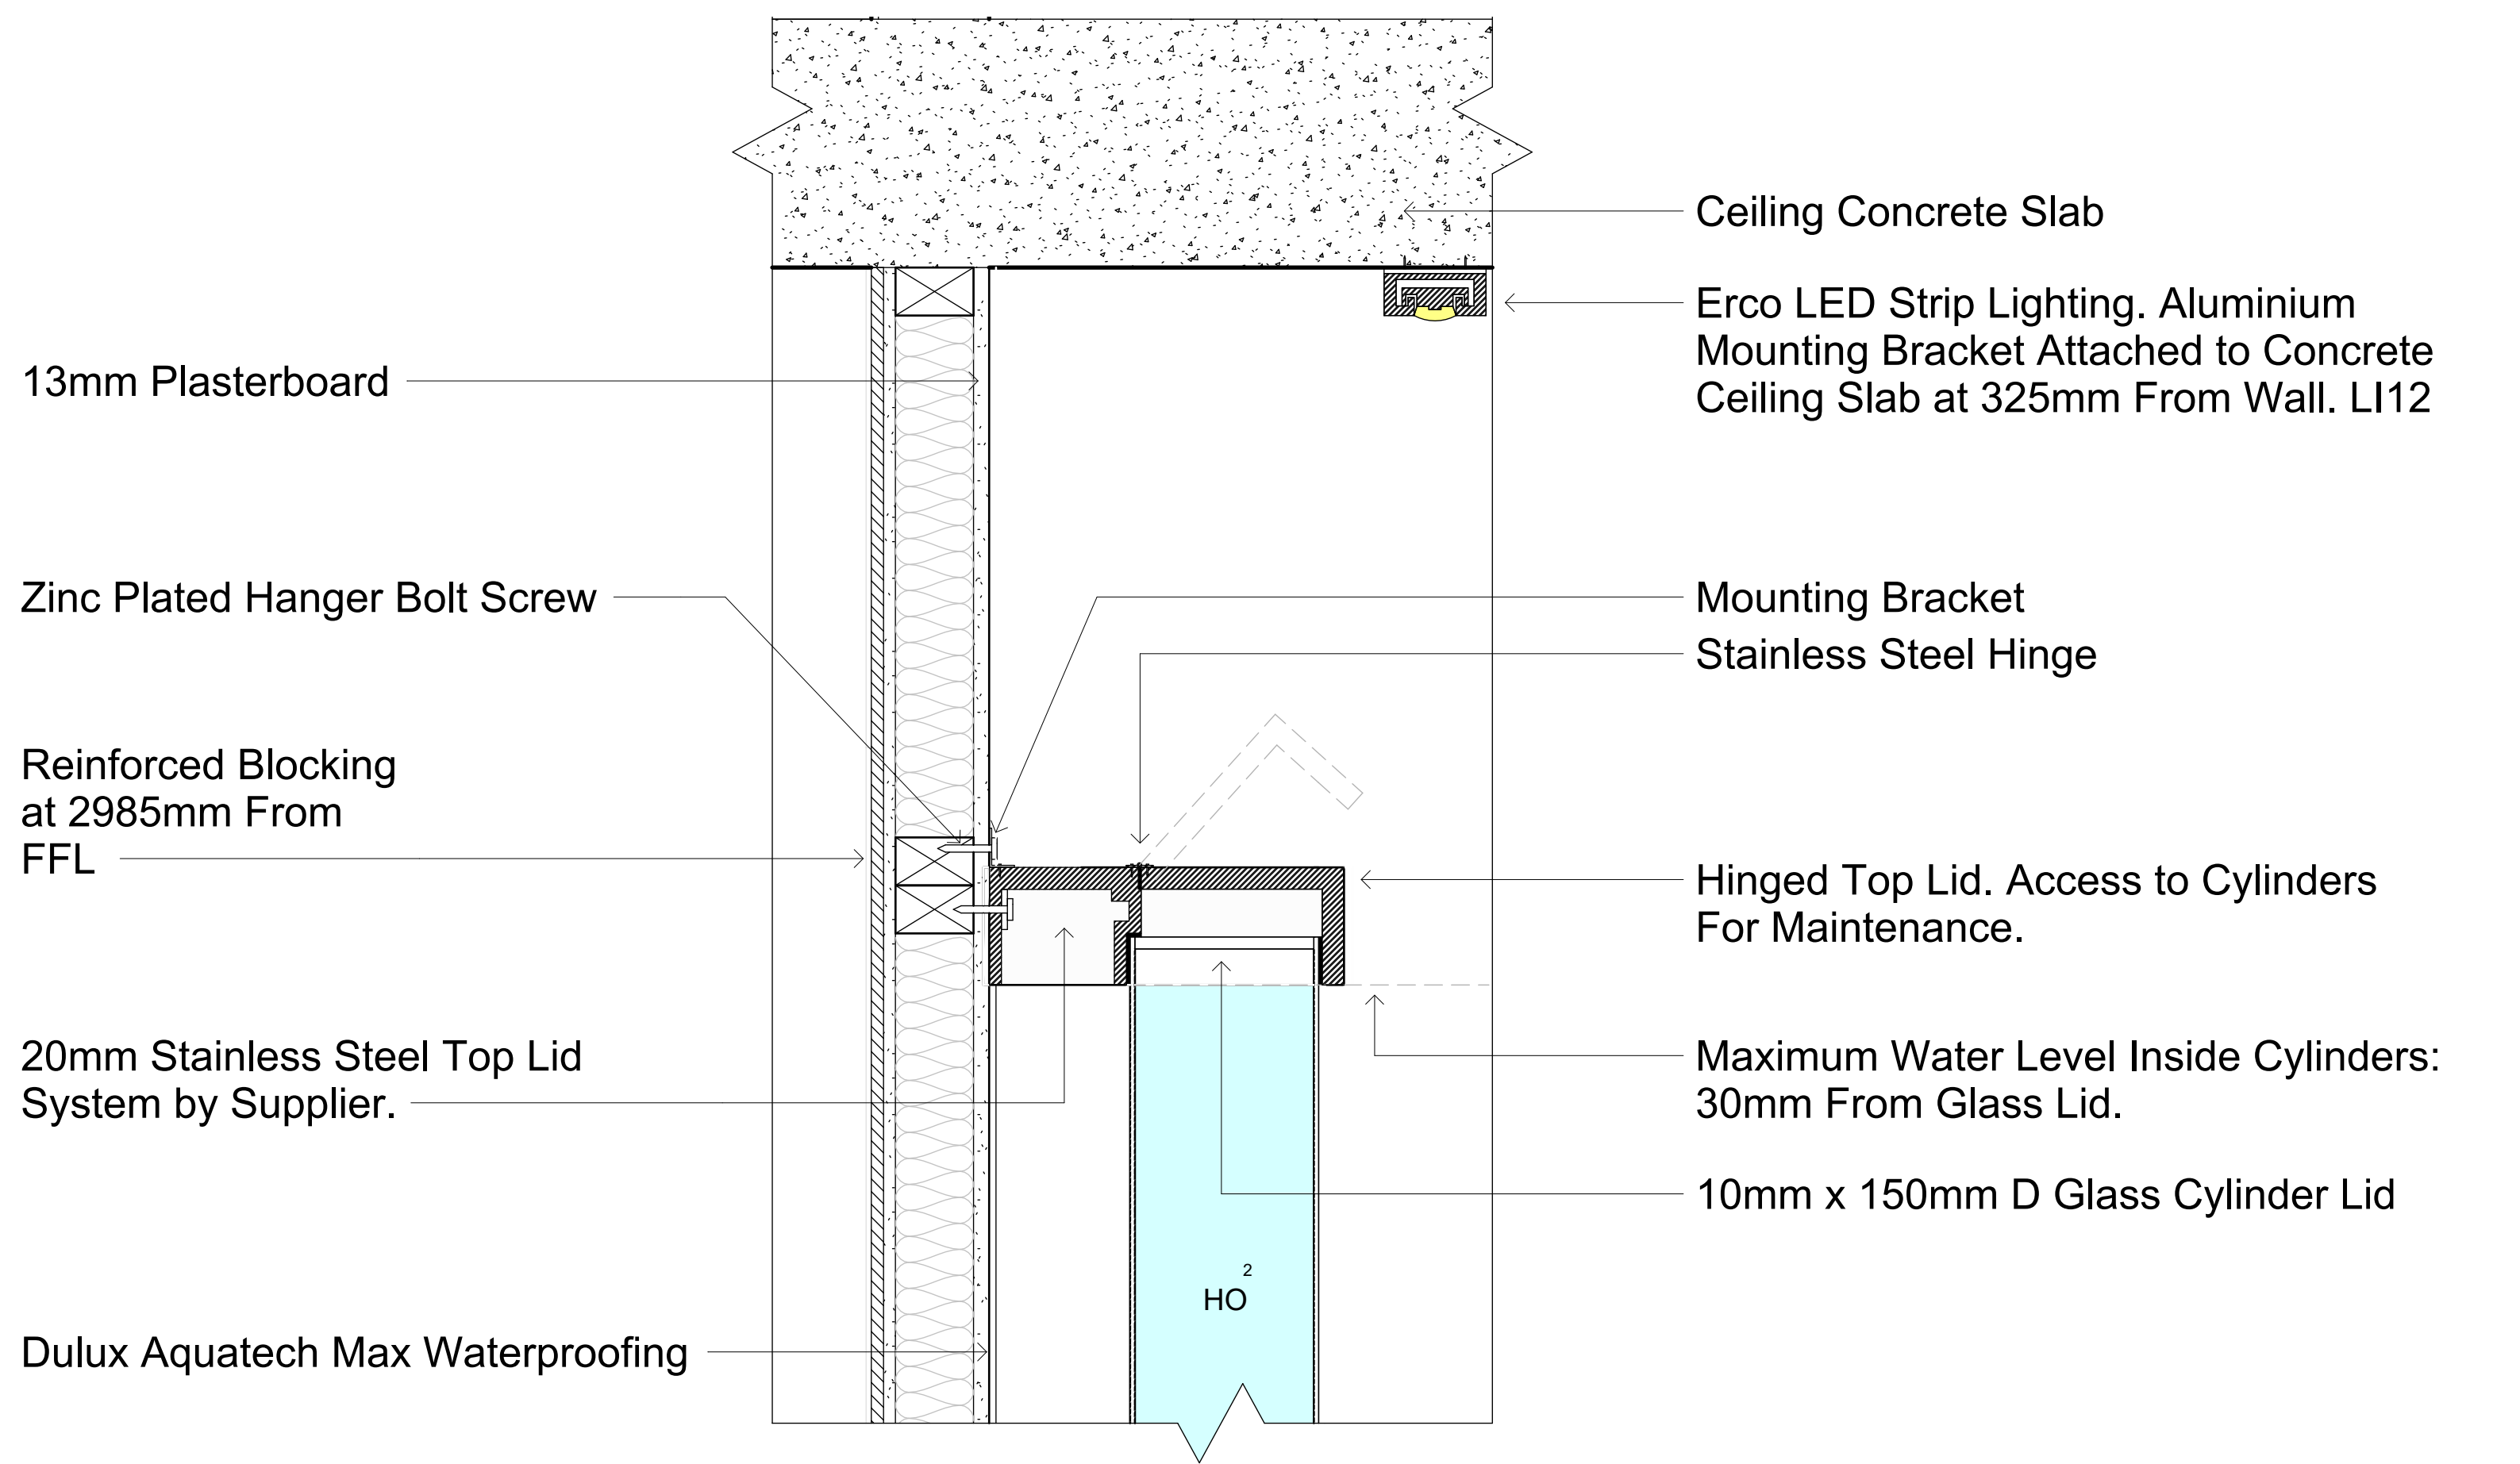

3 Water Feature Wall Section Detail
1 : 5

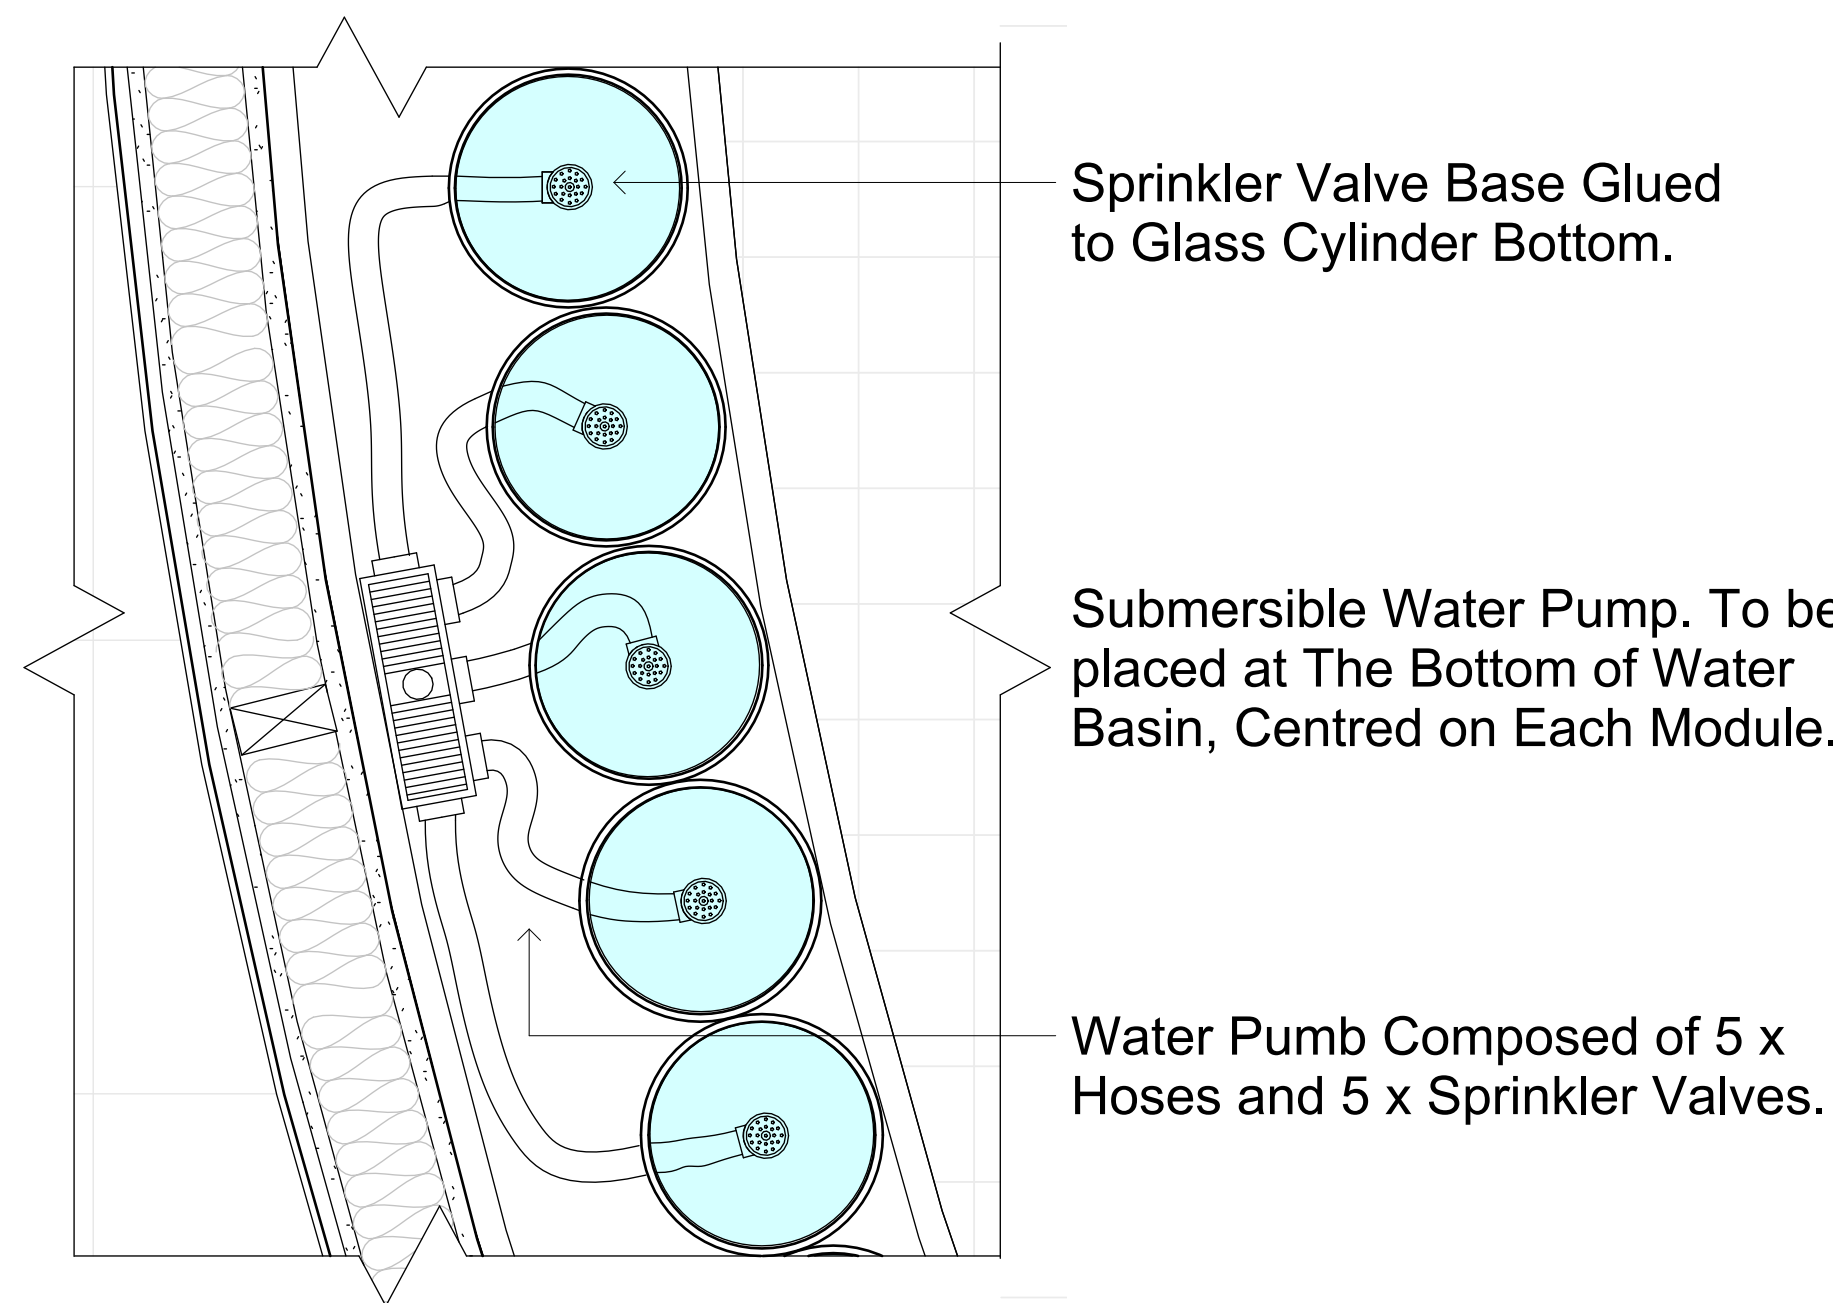

2 Water Feature Wall Plan Detail
1 : 5

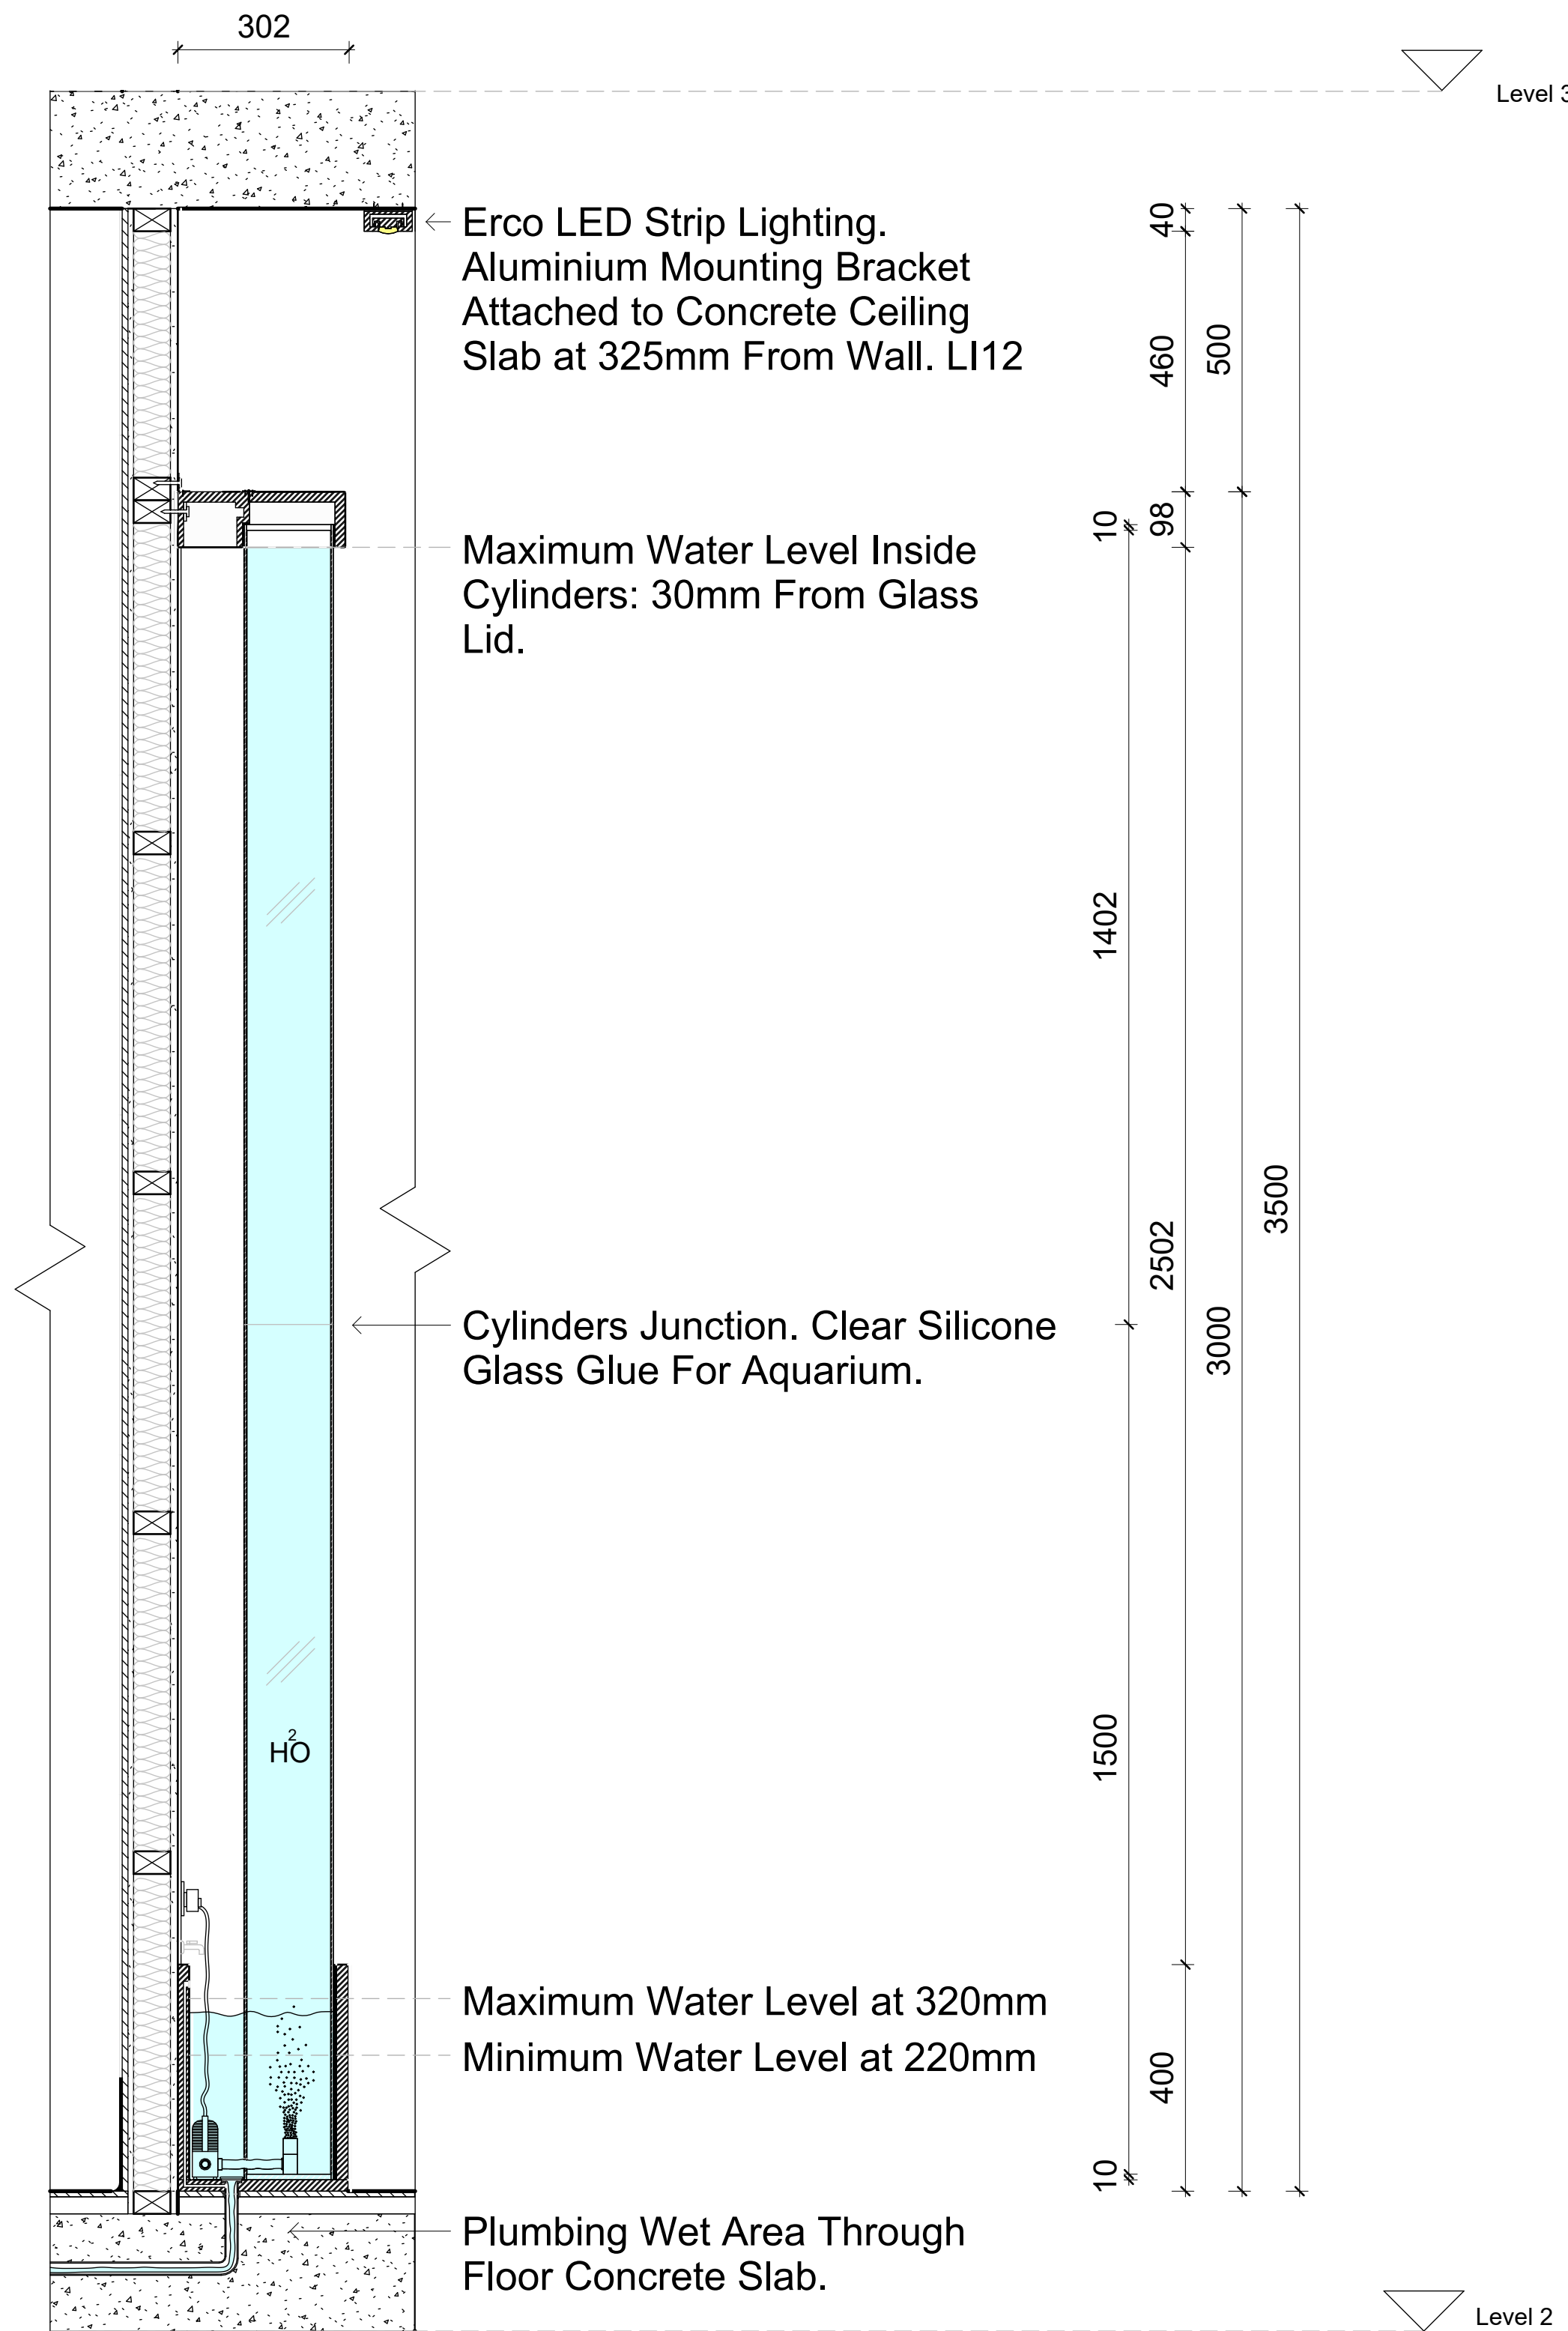

1 Water Feature Wall Section
1 : 10



LEGEND

Hatch Types

	Existing		MDF
	Concrete		Earth
	Tile		Timber
	Plaster Board		Metal

Wall Types

	13mm Plaster Board, 90mm Timber Stud Frame, 13mm Plaster Board
	13mm Plaster Board, 90mm Timber Stud Frame, 13mm FC, 2mm Glue, 10mm Tile
	10mm Tile, 2mm Glue, 13mm FC, 90mm Timber Stud Frame, 13mm FC, 2mm Glue, 10mm Tile

Door Types

	Flush Interior Door 910 x 2110mm
	Flush Interior Door 810 x 2110mm
	Flush Interior Door 1010 x 2110mm
	Double Flush Exterior Door 1510 x 2110mm
	Double Flush Interior Door 1510 x 2110mm
	Curtain Glass Wall Flush Doors (Refer to FF&E for specification)

Abbreviations

FFL	Finished Floor Level
FCL	Finished Ceiling Level
COS	Confirm On Site
MA	Material
FU	Furniture
EQ	Specialty Equipment
AP	Appliances
LI	Lighting Fixture
SA	Plumbing Fixture


Keynote Legend

Key Value	Keynote Text
AP02	MFC Glass Door 400 x 2110mm
AP10	Beach Taps 900mm 1500mm L5 by W&A/DOP
AP11	Beach Taps 900mm 1500mm L5 by W&A/DOP
AP12	800 series 8 Burners stainless steel oven FNS800 by W&A/DOP
EQ07	Professional Workbench 2000mm by MFC
EQ12	Single Sink 800x1500 by MFC
EQ17	Single Sink 800x1500 by MFC
EQ18	Storage Cabinet 800x1500 by MFC
EQ19	Single Sink 800x1500 by MFC
EQ21	Hand Wash Unit 800x1500 by MFC
EQ22	Corner Top 800x1500 by MFC
EQ23	800 series stainless steel sink by Ryn
EQ24	Disinfectant hand basin with sink and splash back 800x1500 by Ryn
EQ25	Hand Wash Unit 800x1500 by Ryn
EQ26	For Extension to MFC
EQ27	For Extension to MFC
EQ28	For Extension to MFC
EQ100	For Extension to MFC

Revisions	Scale	Drawing No	Issue
No Date	1:10 & 1:5	A21	01
01 29/10/23	Date	10/12/23	
02 19/11/23	Drawn by	PS	
03 10/12/23			

Do not scale drawings. Use figured dimensions only. Check and verify levels and dimensions on site prior to commencement of any work, the preparation of drawings or the fabrication of components. This drawing is copyright and can not be reproduced without written consent.	Client Ak	Designed by: PS	NOTES	True North	Billy Blue College of Design 46-52 Mountain Street, Ultimo, NSW 2007, Australia +61 (0)2 9999 9999	Project Akira Back Restaurant Project Address: Level 2 Northern end of the Overseas Passenger Terminal, Circular Quay W, The Rocks NSW 2000 Project number 2023. 002	Drawing Title Water Feature Wall Section & Isometric Drawing Status TENDER ISSUE DRAWINGS NOT FOR CONSTRUCTION
--	--------------	--------------------	-------	------------	--	---	---

05/12/2023 14:36:00

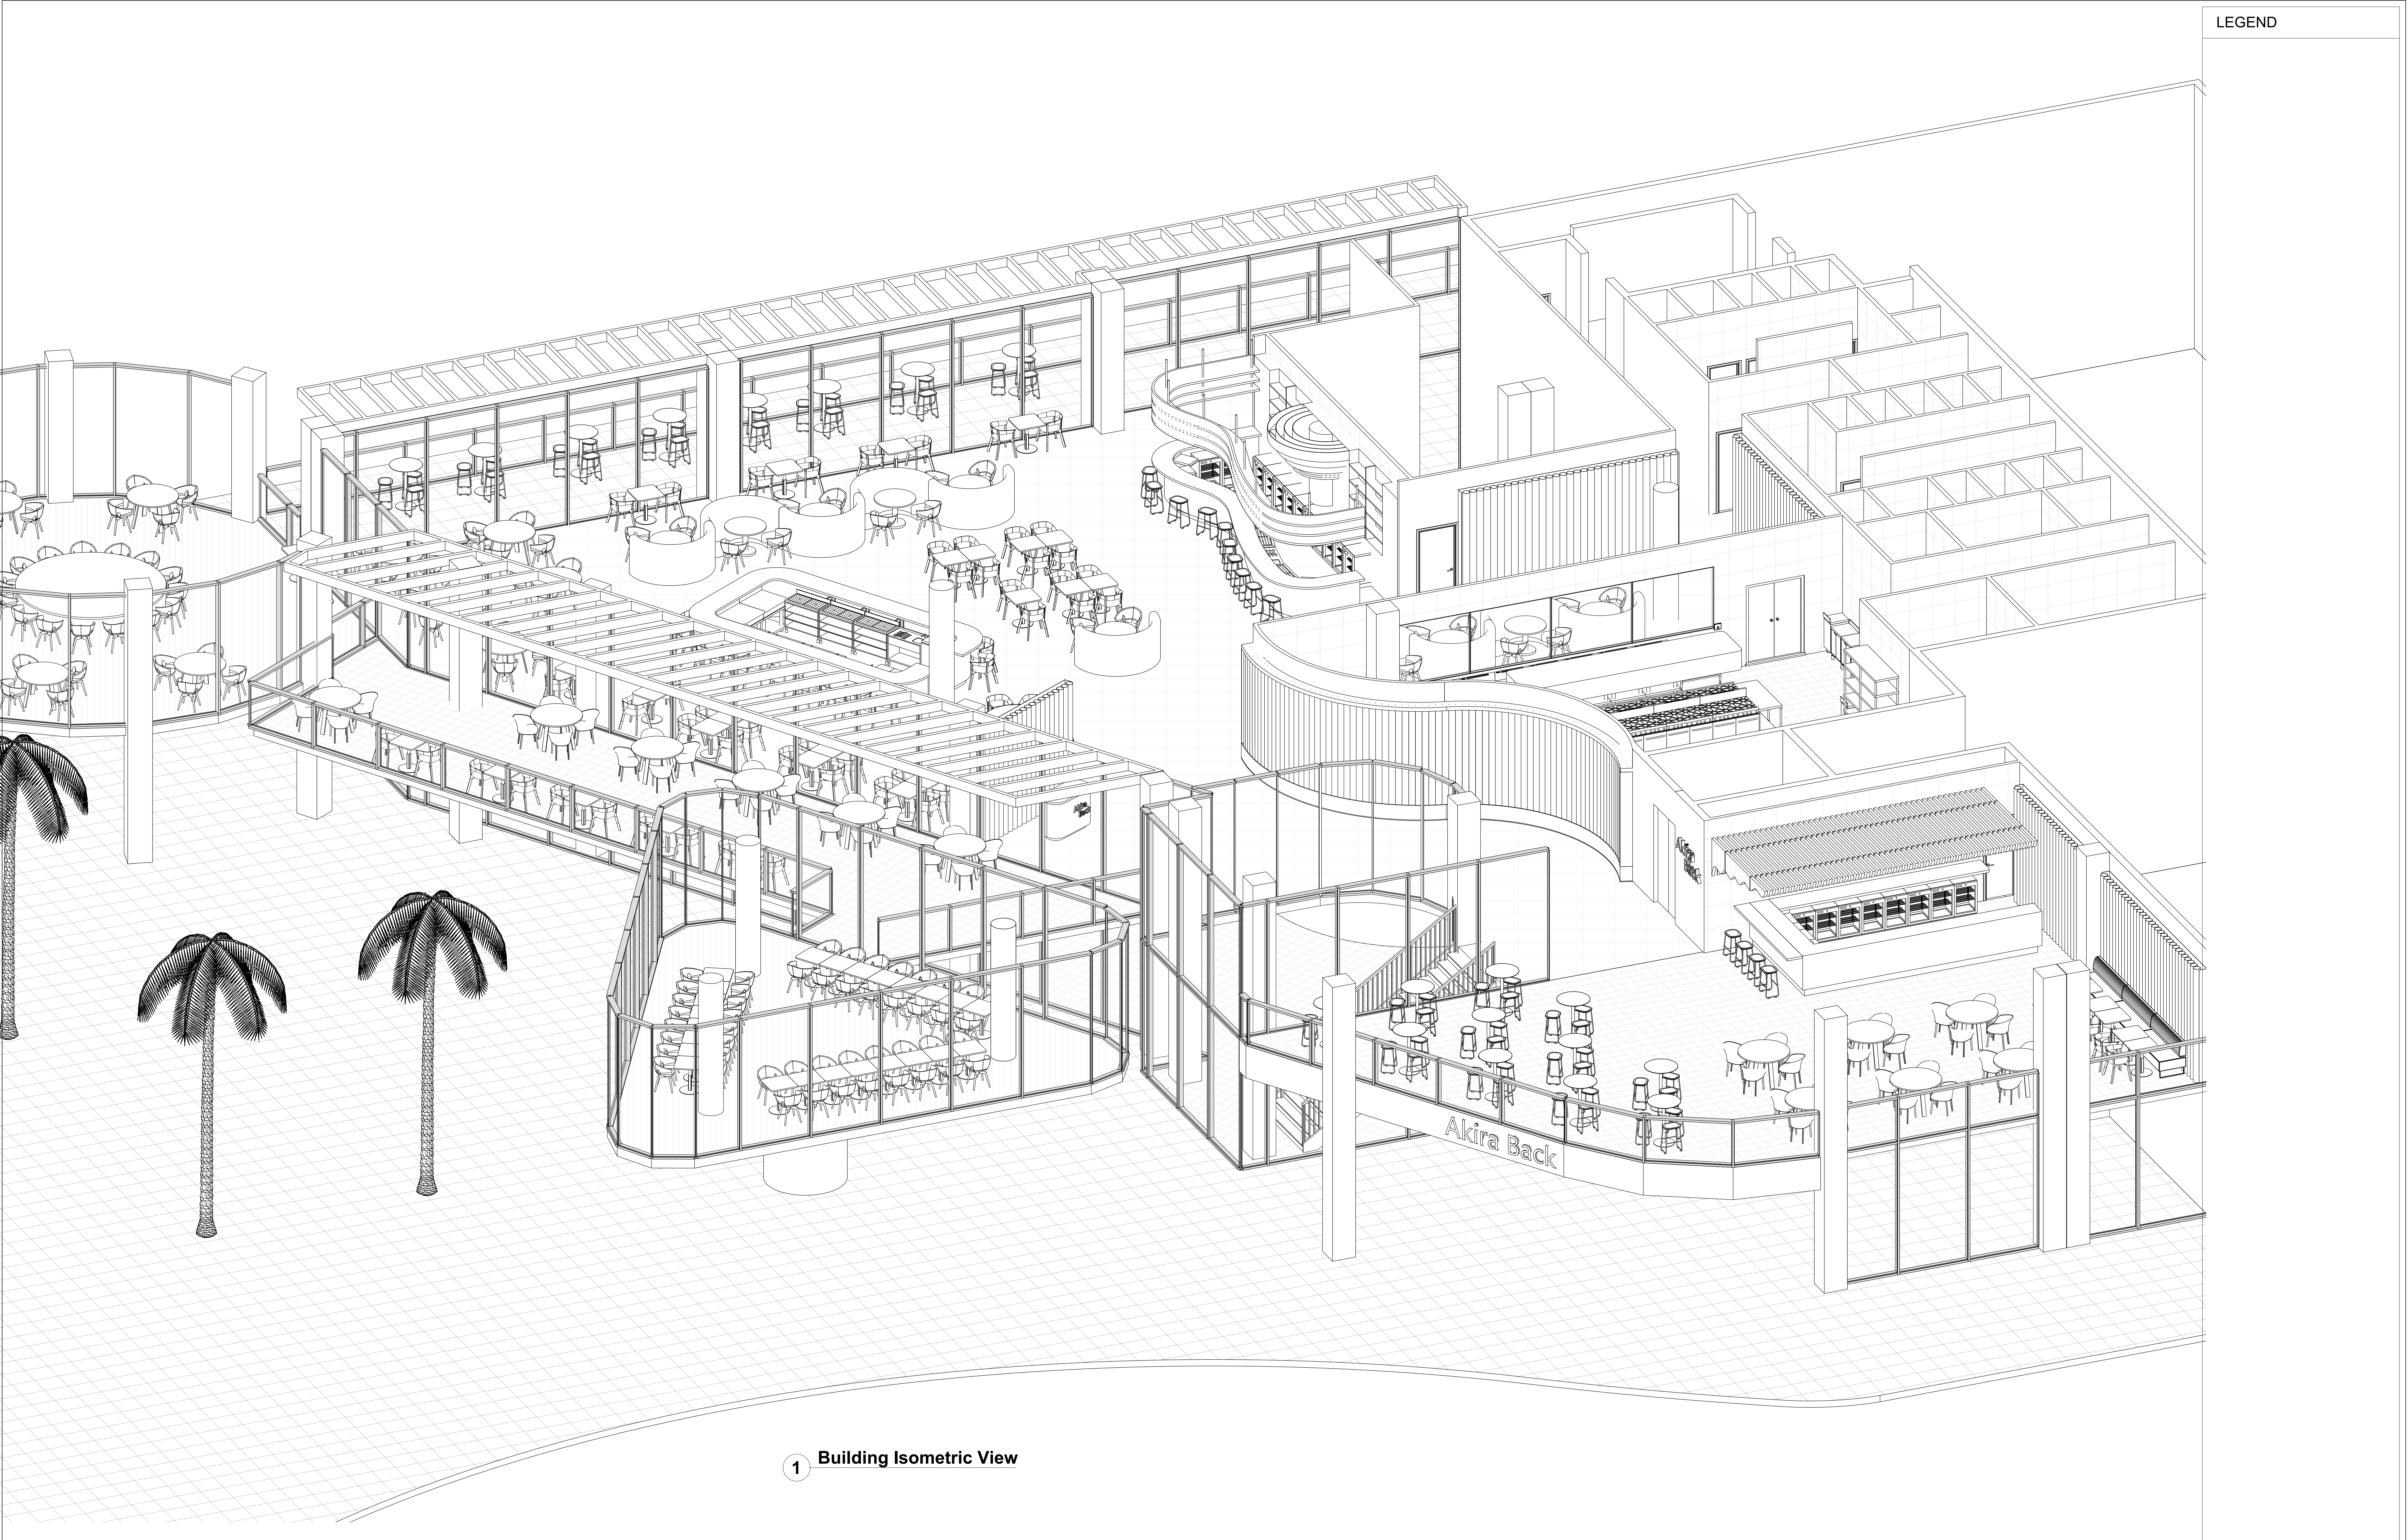

LEGEND

1 Building Isometric View

Revisions

No	Date	Description	Ver.	App'd
01	29/10/23	TENDER DRAWINGS NOT FOR CONSTRUCTION	XX	App'd
02	19/11/23	TENDER DRAWINGS NOT FOR CONSTRUCTION	XX	App'd
03	10/12/23	TENDER DRAWINGS NOT FOR CONSTRUCTION	XX	App'd

Ver. App'd
XX App'd
XX App'd
XX App'd

Do not scale drawings. Use
figured dimensions only. Check
and verify levels and dimensions
on site prior to commencement of
any work, the preparation of
drawings or the fabrication of
components.
This drawing is copyright and can
not be reproduced without written
consent.

Client
Ak

Akira Back

Designed by:
PS

PAMELLA SILVA
INTERIOR DESIGNER

NOTES

True North

Billy Blue College of Design
46-52 Mountain Street, Ultimo, NSW 2007,
Australia
+61 (0)2 9999 9999

BILLY BLUE
COLLEGE OF DESIGN

TORRENS
UNIVERSITY
AUSTRALIA

LAUREATE INTERNATIONAL UNIVERSITIES

Project
Akira Back Restaurant

Project Address:
Level 2 Northern end of the Overseas Passenger
Terminal, Circular Quay W, The Rocks NSW 2000

Project number
2023. 002

Drawing Title
Building Isometric View

Drawing Status
TENDER ISSUE DRAWINGS
NOT FOR CONSTRUCTION

Scale
N/A

Date
10/12/23

Drawn by
PS

Drawing No
A22

Issue
01

05/12/2023 14:39:11

A0